

VALDEZ CITY SCHOOLS
VOLUME 2: HERMON HUTCHENS ELEMENTARY SCHOOL
RESTROOM RENOVATION
CITY OF VALDEZ

1009 W Klutina St, Valdez, AK 99686
CONSTRUCTION DOCUMENTS

SHEET NO.
A001-2



McCOOL CARLSON GREEN
ARCHITECTURE • PLANNING • INTERIORS
HISTORIC ANCHORAGE TRAIN DEPOT
421 W. 1ST AVENUE • SUITE 300 • ANCHORAGE, AK 99501
907.563.8474 PHONE • 907.563.4572 FAX • WWW.MCGALASKA.COM

JOB NO. 2016034.01
PROJ. MGR.: NMH
DRAWN BY: NMH
DATE: 11/15/2017
REVISIONS:

REVIEWED BY:

John T. Weir

ABBREVIATIONS

AB	ACOUST	ADD	ADJ	AFF	AK	ALT	AL/ALUM	APPROX	APT	ARCH	AWW	AT	AWC	B	BD	BDRM	BLD/BLDG	BM	BOD	BOT	BSMT	BTWN	CAB	CAR	CB	CIP	CJ	CLG	CLO	CLR	COL	CONF	CMP	CMU	CONC	CONST	CONT	CONTR	COORD	CORR	CUH	CT	CTSK				
ACRYLIC COATING	ANCHOR BOLT	ACOUSTICAL	ADDITIVE	ADJUSTABLE	ABOVE FINISH FLOOR	ALASKA	ALTERNATE	ALUMINUM	APPROXIMATE	ARCHITECTURAL	ACRYLIC WALL COATING	ACOUSTIC TILE	ALUMINUM WINDOW WALL	BATH	BOARD	BEDROOM	BUILDING	BEAM	BOTTOM OF DECK	BOTTOM	BASEMENT	BETWEEN	CABINET	CARPET	COVE BASE	CAST IN PLACE	CONTROL JOINT	CEILING	CLOSET	CLEAR	COLUMN	CONFERENCE	CORRUGATED METAL PIPE	CONCRETE MASONRY UNITS	CONCRETE	CONSTRUCTION	CONTINUOUS	CONTRACTOR	COORDINATE	CORRIDOR	CABINET UNIT HEATER	CERAMIC TILE	CENTERLINE	COUNTERSUNK			
D	DBL	DF	DIA/O	DIM	DISP	DN	DOT/PF	DTL	DW	DWG	DWR	(E)	EA	E/A	ELEC	EL/ELEV	ELEV	ENCL	EPDM	EQ	ESC	EX/EXIST	EXP	EXT	EXWD	FAF	FD	FDN	FE	FIN	FIXT	FF	FLASH	FLR	FOF	FOS	FPW	FRP	FRT	FT	FTG	FURR					
DEEP	DOUBLE	DRINKING FOUNTAIN	DIAMETER	DIMENSION	DISPENSER	DOWN	ALASKA DEPARTMENT OF	TRANSPORTATION/PUBLIC	FACILITIES	DETAIL	DISHWASHER	DRAWING	DRAWER	EXISTING	EACH	EXHAUST AIR	ELECTRICAL	ELEVATION	ENCLOSURE	ETHYLENE PROPYLENE	DIENE MONOMER	ESCALATOR	EXISTING	EXPOSED STRUCTURE	(NO CEILING)	EXTERIOR	EXISTING WOOD CEILING	FLUID APPLIED SPORTS	FLOORING	FLOOR DRAIN	FOUNDATION	FIRE EXTINGUISHER	FINISH	FIXTURE	FACTORY FINISH	FLASHING	FLOOR	FACE OF FINISH	FACE OF STUD	FIRE RETARDANT	TREATED PLYWOOD	FIBERGLASS REINFORCED	PLASTIC	FIRE RETARDANT TREATED	FOOT OR FEET	FOOTING	FURRING
GA	GALV	GFRC	GL	GW	GYP	H	HDPB	HDW	HDWD	HORIZ	HP	HR	HT	ID	INSUL	INT	IRMA	JAN	JT	KIT	L	LAM	LAV	LS	M	MATL	MAX	MB	MBR	MECH	MFP	MFR	MFRD	MIN	MISC	MO	MTL	MULL	N	NIC	NOM	NTS					
GALVANIZED	GLASS FIBER REINFORCED	CEMENT	GLASS	GYP	GYP	HIGH	HIGH DENSITY PARTICLE BOARD	HARDWARE	HARDWOOD	HORIZONTAL	HORSEPOWER	HOUR	HEIGHT	INSIDE DIAMETER	INCLUDING	INSULATION / INSULATING	INTERIOR	INSULATED ROOF MEMBRANE	JANITOR	JOINT	KITCHEN	LONG	LAMINATED	LAVATORY	LAG SCREW	MEN	MATERIAL	MAXIMUM	MARKER BOARD	MEMBER	MECHANICAL	METAL FACED PLYWOOD	MANUFACTURER	MANUFACTURED	MINIMUM	MISCELLANEOUS	MASONRY OPENING	METAL	MULLION	NONE / NOT APPLICABLE	NOT IN CONTRACT	NOMINAL	NOT TO SCALE				
O/A	O/A	OC	OD	O.F./C.I.	OFD	OFF	OH	OPNG	OPP	P	PC	PERF	P-LAM	PLY	PP	PS	PT	PNL	PR	R	RAF	R/A	RB	RD	REF	REINF	REQD	REV	RG	RF	RM	RO	RT	RTT	RUB	S	SB	SAC	S/A	SCHED	SECT	SF	SHT				
OVER	OUTSIDE AIR	ON CENTER	OUTSIDE DIAMETER	OWNER FURNISHED	CONTRACTOR INSTALLED	OVER FLOW DRAIN	OFFICE	OPPOSITE HAND /OVERHEAD	OPENING	OPPOSITE HAND	PAINT	PORCELAIN CERAMIC TILE	PERFORATED	PLASTIC LAMINATE	PLYWOOD	PLYWOOD WAINSCOT	PLASTIC PANEL WAINSCOT	PROJECTION SCREEN	PRESERVATIVE TREATED	PAIR	RADIUS / RISER	RAISED ACCESS FLOOR	RETURN AIR	RUBBER BASE	ROOF DRAIN	REFERENCE / REFRIGERATOR	REINFORCED	REQUIRED	REVISED/REVISION	REFRIGERATOR	ROOF	ROOM	ROUGH OPENING	RUBBER TILE	RUBBER TIRE TILE	RUBBER ANTI-SLIP	SEALER	SMOKE BARRIER	SUSPENDED ACOUSTICAL	CEILING	SUPPLY AIR	SCHEDULE	SECRETARY	SECTION	SQUARE FOOT	SHEET	
SHTG	SHR	SIM	SM	SPECS	SS	STD	STL	STRUCT	ST STL	SUSP	SV	T	TEL	T&G	TOB	TOD	TOEB	TOED	TOEJ	TOEP	TOJ	TOP	TP	TR	TS	TYP	UBC	UL	UNO	VT	VR	VERT	VEST	VST	W	WI	WC	WD	WFB	WOM	WRGWB	W/O	WP	WWF			
SHEATHING	SHOWER	SIMILAR	SURFACE MOUNT	SPECIFICATIONS	SQUARE	STAINLESS STEEL	STANDARD	STEEL	STRUCTURAL	STAINLESS STEEL	SUSPENDED	SHEET VINYL	TOILET	TELEPHONE	TONGUE & GROOVE	TOP OF BEAM	TOP OF DECK	TOP OF EXISTING BEAM	TOP OF EXISTING DECK	TOP OF EXISTING JOIST	TOP OF EXISTING PARAPET	TOP OF JOIST	TOP OF PARAPET	TOILET PAPER	TREADS	TACK SURFACE	TYPICAL	UNIFORM BUILDING CODE	UNDERWRITERS LABORATORY	UNLESS NOTED OTHERWISE	VINYL TILE	VAPOR RETARDER	VERTICAL	VESTIBULE	STAIR TREAD	WIDE / WOMEN	WITH	WATER CLOSET	WOOD	WOOD FIBER BOARD	WALK OFF ENTRY CARPET	WATER RESISTANT GYPSUM WALLBOARD	WITHOUT	WATERPROOF	WELDED WIRE BOARD		

PROJECT OVERVIEW

THE SCOPE OF THIS PROJECT CONSISTS OF RENOVATING EXISTING TOILET ROOMS AT HERMON HUTCHENS ELEMENTARY SCHOOL

ADD ALTERNATES

ONE: THE BASE BID IS TO INCLUDE PAINTING SELECT EXISTING CMU WALLS IN LOCKER ROOMS 148 AND 157 AS INDICATED ON DRAWINGS. ADD ALTERNATE TO INSTALL TILE ON THESE WALLS WITH PATTERN AND COLOR IDENTICAL TO ADJACENT WALLS IN THE SHOWER AND RESTROOM.

TWO: PAINT EXISTING LOCKERS

DESIGN TEAM

ARCHITECTURAL: MCCOOL CARLSON GREEN - MCG

MECHANICAL: RSA ENGINEERS, INC.

ELECTRICAL: RSA ENGINEERS, INC.

HAZMAT: EHS ALASKA, INC.

INDEX OF DRAWINGS

ARCHITECTURAL	
A001-2	COVER SHEET AND CODE INFORMATION
A100-2	OVERALL REFERENCE PLAN
A111-2	LEVEL 1 DEMOLITION PLANS
A121-2	DEMOLITION REFLECTED CEILING PLANS
A211-2	LEVEL 1 RESTROOM REMODEL PLANS
A301-2	DIMENSION PLANS
A302-2	DIMENSION PLANS
A303-2	ACCESSIBLE FIXTURE MOUNTED HEIGHTS AND ADA CLEARANCES
A701-2	ASSEMBLIES AND FINISH SCHEDULE
I211-2	FINISH AND ACCESSORIES PLAN - LEVEL 1
I311-2	REFLECTED CEILING PLANS
I401-2	INTERIOR ELEVATIONS
I402-2	INTERIOR ELEVATIONS
I501-2	INTERIOR DETAILS
MECHANICAL	
M001 MECHANICAL LEGENDS	
M101	DEMOLITION PLANS
M201	PLUMBING PLAN 148 & 157
M202	PLUMBING PLAN 103 & 105
M301 VENTILATION PLANS	
ELECTRICAL	
E001 ELECTRICAL LEGEND, DETAILS AND FIXTURE SCHEDULES	
E101	LOCKER AND RESTROOM ELECTRICAL DEMOLITION PLANS
E201	LOCKER AND RESTROOM ELECTRICAL REMODEL PLANS

SYMBOLS

WALL SECTION SYMBOL

BUILDING SECTION SYMBOL

ELEVATION SYMBOLS

DOOR KEY

WINDOW KEY

ROOM TAG

SHEET NOTE KEYS


ASSEMBLY TAG


MISCELLANEOUS SYMBOLS

NORTH ARROW


DETAIL SYMBOL

VICINITY MAP

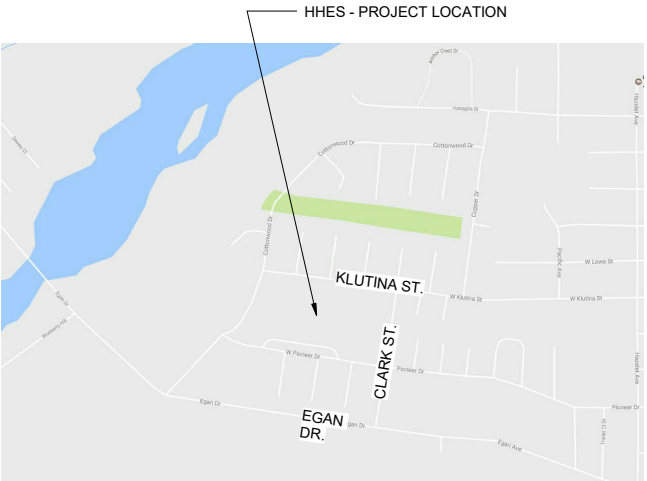

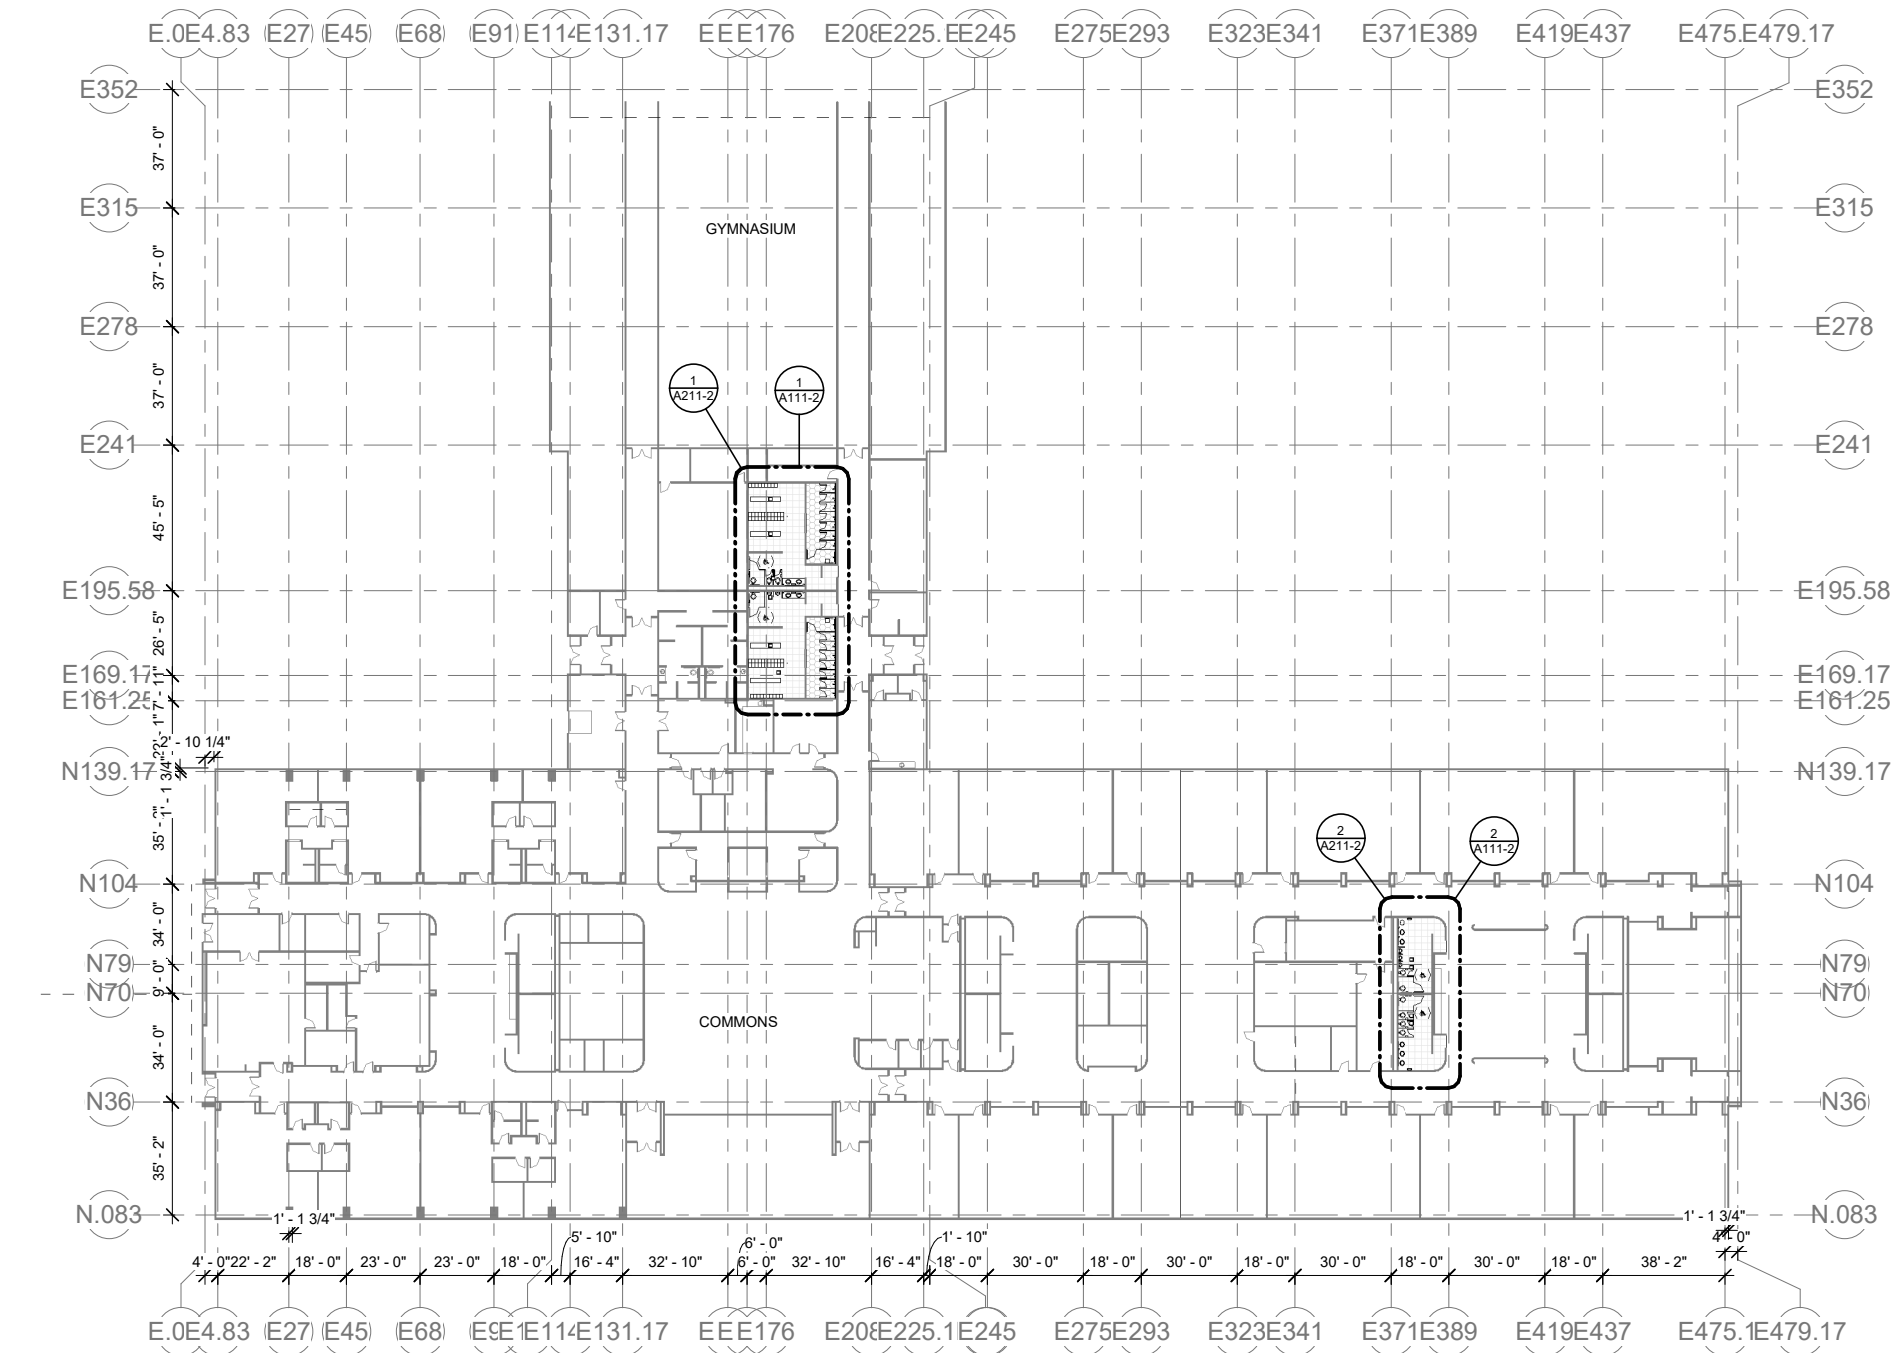

1 FLOOR PLAN - LEVEL 1 - OVERALL PLAN
A100-2 1" = 30'-0"

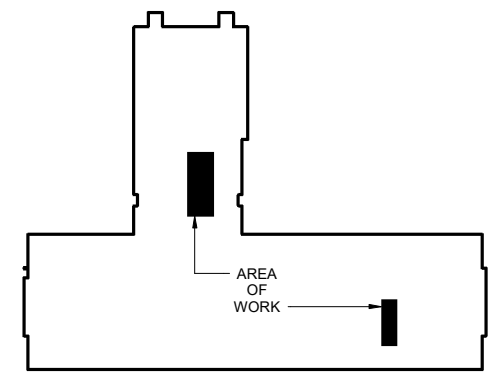

KEY PLAN
N.T.S.




JOB NO. 201004401	REVIEWED BY: <i>[Signature]</i>
PROJ. MGR. NMH	
DRAWN BY: NR	
DATE: 11/15/2017	
REVISIONS:	
	John T. Wall




MCCOOL CARLSON GREEN
ARCHITECTURE • PLANNING • INTERIORS
HISTORIC ANCHORAGE TRAIN DEPOT
421 W. 1ST AVENUE • SUITE 300 • ANCHORAGE, AK 99501
907.563.8474 PHONE • 907.563.4572 FAX • WWW.MCGALASKA.COM

VCS RESTROOM RENOVATION
VOLUME 2 HHES
1009 W Klutina St. Valdez, AK 99686
CITY OF VALDEZ
OVERALL REFERENCE PLAN

SHEET NO.
A100-2

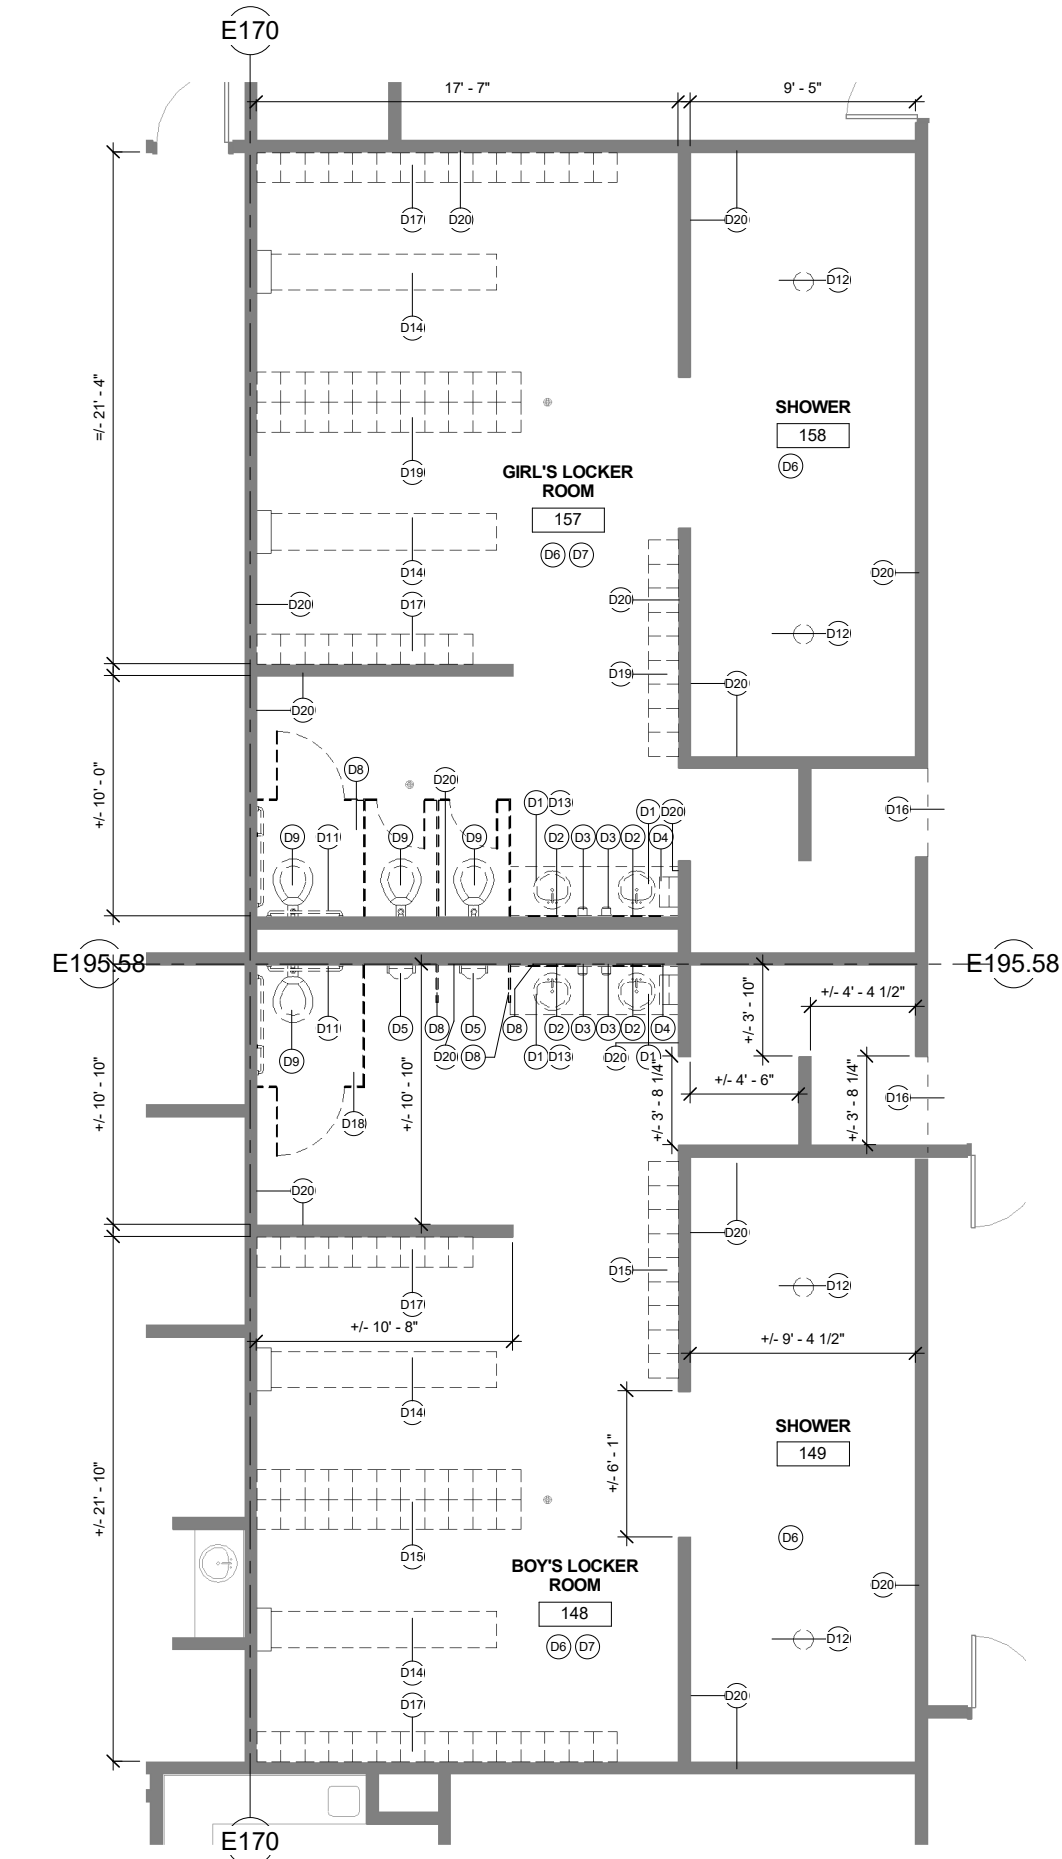

1 FLOOR PLAN - LOCKER ROOMS 148 & 157 DEMO
A111-2 1/4" = 1'-0"

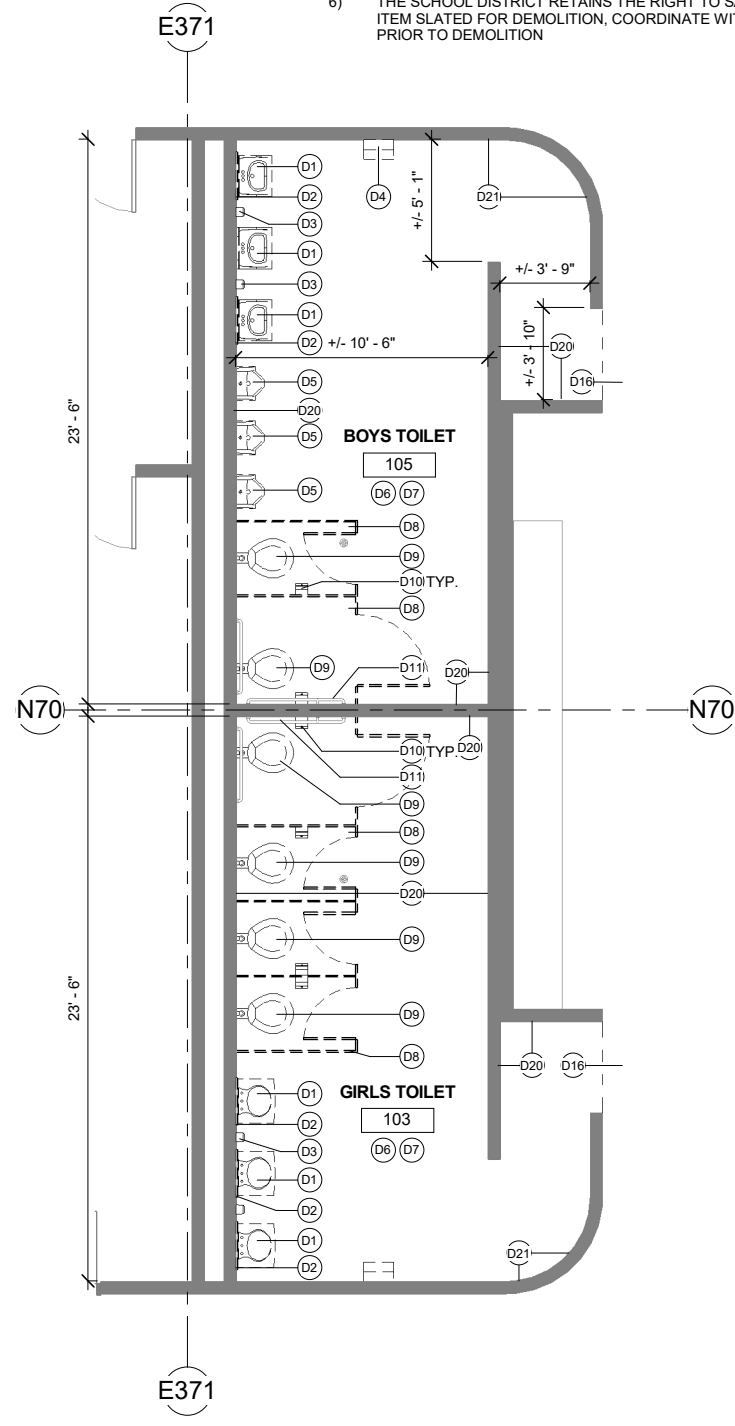

2 FLOOR PLAN - RESTROOMS 103 & 105 DEMO
A111-2 1/4" = 1'-0"

GENERAL NOTES


- 1) THE INFORMATION SHOWN IN THIS DRAWING IS TAKEN FROM AS-BUILT DRAWINGS AND WALK-THRU OF THE EXISTING FACILITY. THERE IS NO WARRANTY OR GUARANTEE AS OF THE ACCURACY OF THE INFORMATION SHOWN. THE CONTRACTOR SHALL FIELD VERIFY ALL ITEMS, AREAS, AND ASSEMBLIES SHOWN FOR DEMOLITION PRIOR TO START OF WORK
- 2) DIMENSIONS ARE BASED ON ASBUILT DRAWINGS AND VARIOUS SITE VISITS. ACCURACY OF CRITICAL DIMENSIONS SHOULD BE VERIFIED BY THE CONTRACTOR
- 3) REFER TO MECHANICAL AND ELECTRICAL SHEETS FOR RELATED DEMOLITION INFORMATION
- 4) THE OWNER SHALL HAVE FIRST RIGHT OF REFUSAL ON ALL SALVAGEABLE MATERIAL, THE CONTRACTOR SHALL DELIVER SALVAGED MATERIALS TO AN AREA AS DIRECTED BY THE OWNER
- 5) DEMOLISH ALL TOILET ROOM ACCESSORIES UNLESS OTHERWISE NOTED.
- 6) THE SCHOOL DISTRICT RETAINS THE RIGHT TO SALVAGE ANY ITEM SLATED FOR DEMOLITION, COORDINATE WITH OWNER PRIOR TO DEMOLITION

SHEET NOTES

- (D1) DEMOLISH EXISTING LAVATORY
- (D2) DEMOLISH EXISTING MIRROR
- (D3) DEMOLISH EXISTING SOAP DISPENSER
- (D4) DEMOLISH EXISTING PAPER TOWEL DISPENSER
- (D5) DEMOLISH EXISTING URINAL
- (D6) DEMOLISH EXISTING FLOOR TILE
- (D7) DEMOLISH EXISTING ACT CEILING
- (D8) DEMOLISH EXISTING TOILET PARTITION
- (D9) DEMOLISH EXISTING TOILET
- (D10) DEMOLISH EXISTING TOILET PAPER DISPENSER
- (D11) DEMOLISH EXISTING GRAB BARS
- (D12) DEMOLISH EXISTING SHOWER FIXTURE
- (D13) DEMOLISH EXISTING COUNTER
- (D14) REMOVE AND SALVAGE EXISTING BENCH
- (D15) REMOVE AND SALVAGE EXISTING LOCKERS
- (D16) LIMIT OF DEMOLITION
- (D17) DEMOLISH EXISTING LOCKERS
- (D18) REMOVE AND SALVAGE TOILET PARTITION
- (D19) REMOVE AND SALVAGE EXISTING LOCKERS
- (D20) DEMOLISH EXISTING CT ON MASONRY WALL
- (D21) DEMOLISH EXISTING CT AND GWB

DEMOLITION PLAN LEGEND

- ① SHEET NOTES
- EXISTING WALLS TO REMAIN UNLESS OTHERWISE NOTED OR REQUIRED TO BE MODIFIED
- EXISTING WALLS TO BE REMOVED
- EXISTING DOOR TO REMOVED
- EXISTING DOOR AND FRAME TO REMAIN

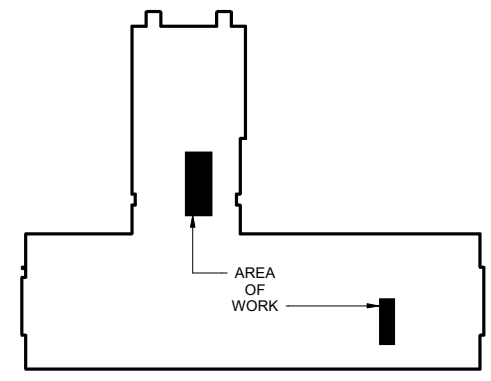

KEY PLAN
N.T.S.



REVIEWED BY:
John T. Wall


JOB NO. 2016034401
PROJ. MGR. NMH
DRAWN BY: NR
DATE: 11/15/2017
REVISIONS:

VCS RESTROOM RENOVATION
VOLUME 2 HHES
1009 W Klutina St. Valdez, AK 99686
CITY OF VALDEZ


SHEET NO.
A111-2

LEVEL 1 DEMOLITION PLANS

McCOOL CARLSON GREEN
ARCHITECTURE • PLANNING • INTERIORS
HISTORIC ANCHORAGE TRAIN DEPOT
421 W. 1ST AVENUE • SUITE 300 • ANCHORAGE, AK 99501
907.563.8474 PHONE • 907.563.4572 FAX • WWW.MCGALASKA.COM

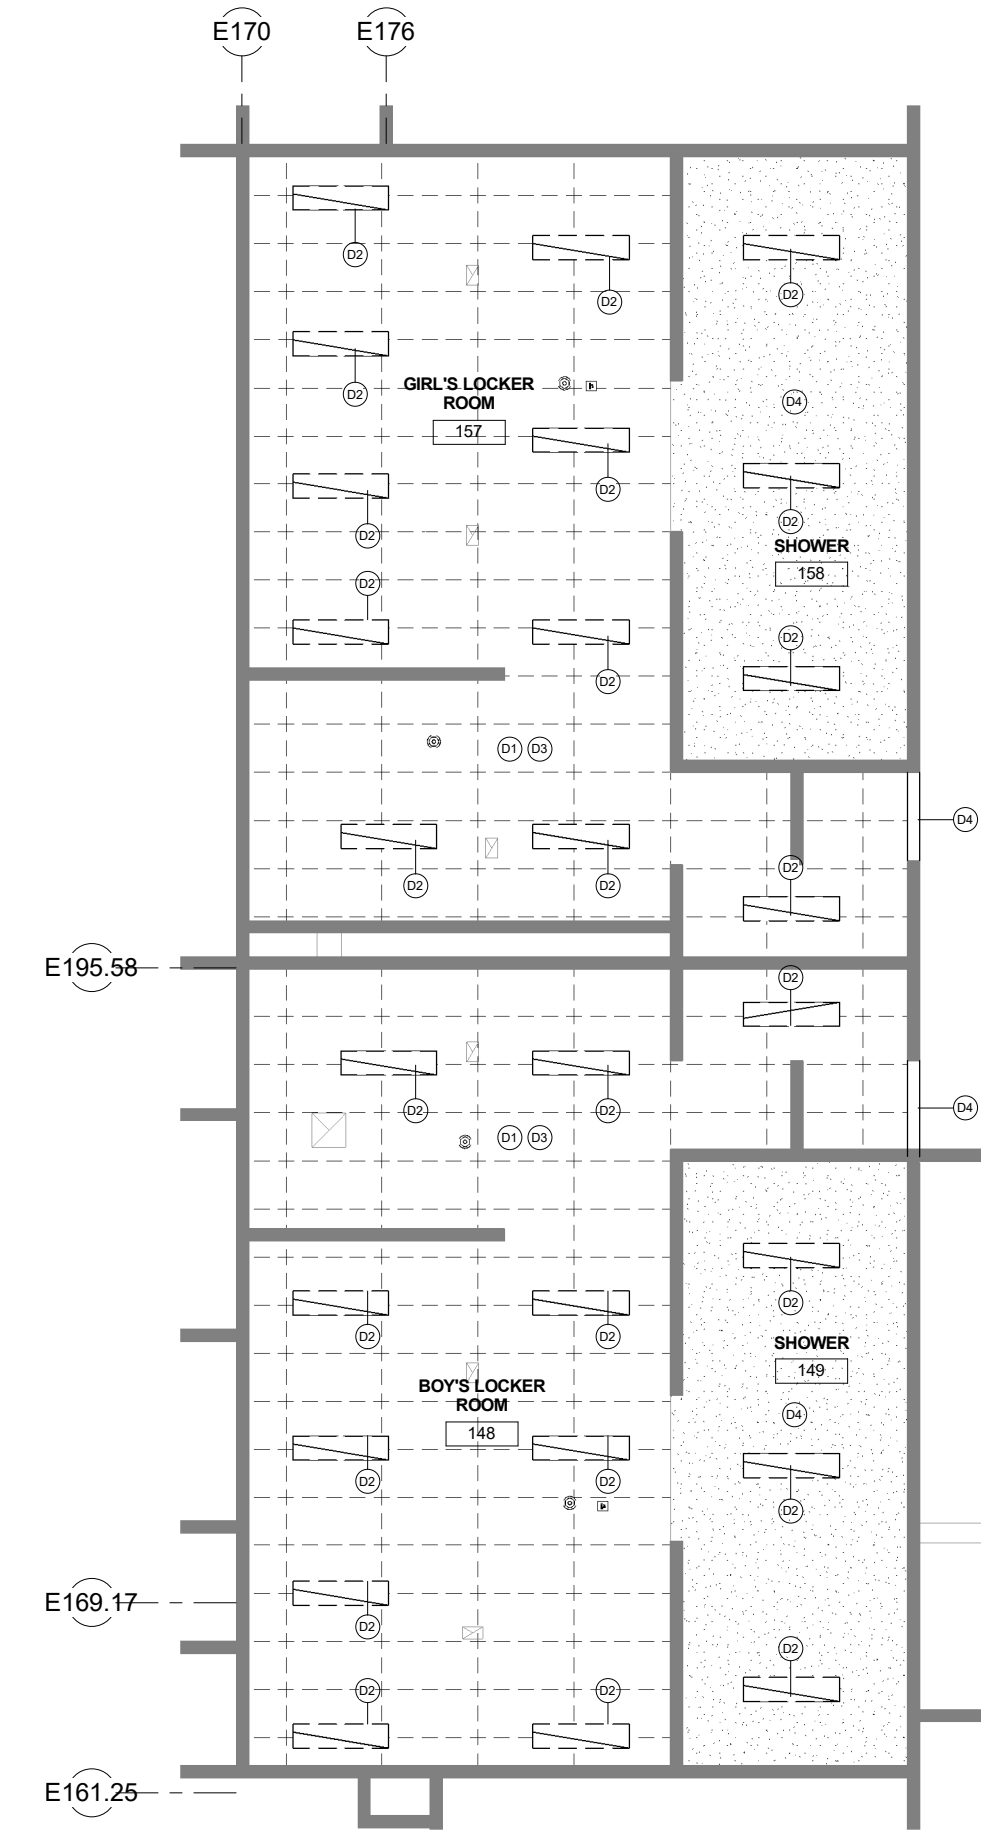

2 REFLECTED CEILING PLAN - LOCKER ROOMS 148 & 157 DEMO
A121-2 1/4" = 1'-0"

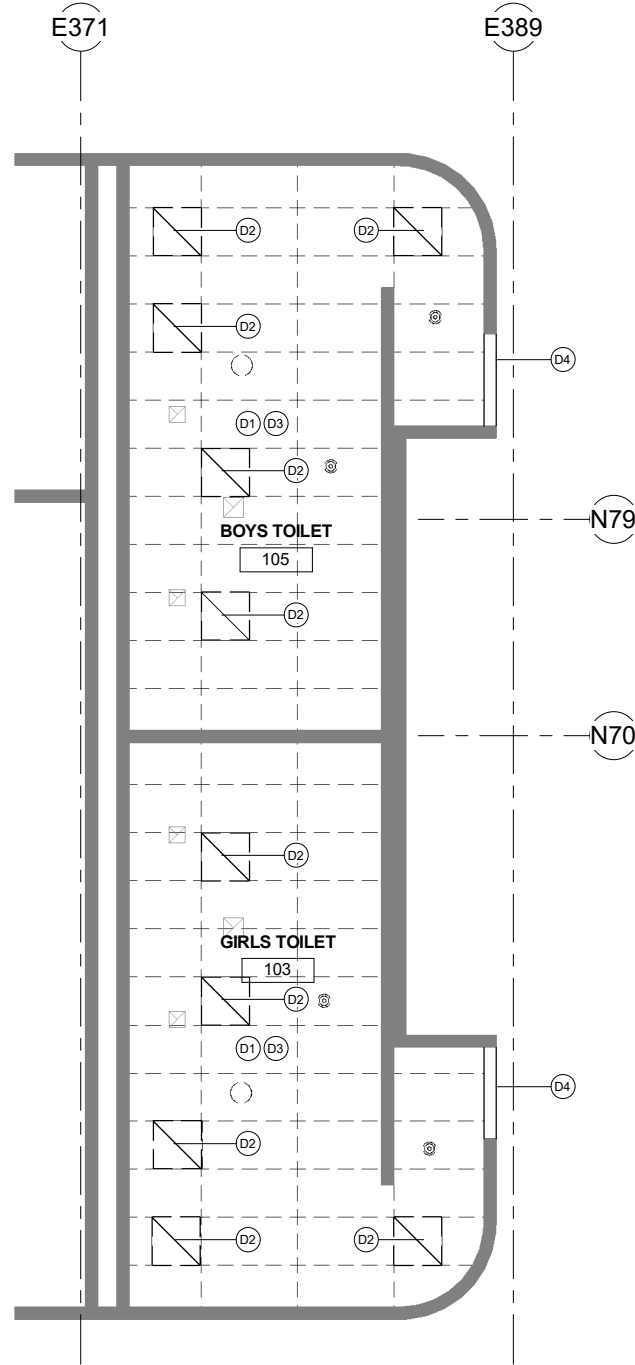

1 REFLECTED CEILING PLAN - DEMO
A121-2 1/4" = 1'-0"

SHEET NOTES


- D1 DEMOLISH EXISTING CEILING
- D2 DEMOLISH EXISTING ELECTRICAL FIXTURES, REF ELECTRICAL
- D3 DEMOLISH EXISTING DIFFUSER, REF MECHANICAL
- D4 PROTECT EXISTING CEILING AND SOFFIT

GENERAL NOTES

- 1) THE INFORMATION SHOWN IN THIS DRAWING IS TAKEN FROM AS-BUILT DRAWINGS AND WALK-THRU OF THE EXISTING FACILITY. THERE IS NO WARRANTY OR GUARANTEE AS OF THE ACCURACY OF THE INFORMATION SHOWN. THE CONTRACTOR SHALL FIELD VERIFY ALL ITEMS, AREAS, AND ASSEMBLIES SHOWN FOR DEMOLITION PRIOR TO START OF WORK
- 2) DIMENSIONS ARE BASED ON ASBUILT DRAWINGS AND VARIOUS SITE VISITS. ACCURACY OF CRITICAL DIMENSIONS SHOULD BE VERIFIED BY THE CONTRACTOR
- 3) REFER TO MECHANICAL AND ELECTRICAL SHEETS FOR RELATED DEMOLITION INFORMATION
- 4) THE OWNER SHALL HAVE FIRST RIGHT OF REFUSAL ON ALL SALVAGEABLE MATERIAL, THE CONTRACTOR SHALL DELIVER SALVAGED MATERIALS TO AN AREA AS DIRECTED BY THE OWNER
- 5) DEMOLISH ALL TOILET ROOM ACCESSORIES UNLESS OTHERWISE NOTED.
- 6) THE SCHOOL DISTRICT RETAINS THE RIGHT TO SALVAGE ANY ITEM SLATED FOR DEMOLITION, COORDINATE WITH OWNER PRIOR TO DEMOLITION

DEMO RCP LEGEND

- 1 SHEET NOTES CALLOUT
- 0'-0" ELEVATION OF CEILING
- Room name 101 ROOM TAG
- EXISTING WALL
- EXISTING ACT CEILING
- EXISTING ACT, DEMOLISH
- EXISTING GYPSUM CEILING,
- LIGHTS, DEMOLISH
- DIFFUSERS, DEMOLISH

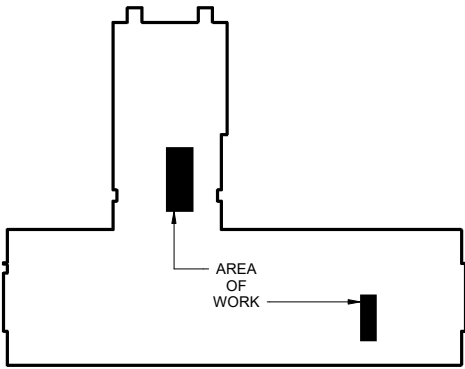

KEY PLAN
N.T.S.


REVIEWED BY: *John T. Wall*
JOB NO: 2010034401
PROJ. MGR: NMH
DRAWN BY: NR
DATE: 11/15/2017
REVISIONS:



MCCOOL CARLSON GREEN
ARCHITECTURE • PLANNING • INTERIORS
HISTORIC ANCHORAGE TRAIN DEPOT
421 W. 1ST AVENUE • SUITE 300 • ANCHORAGE, AK 99501
907.563.8474 PHONE • 907.563.4572 FAX • WWW.MCGALASKA.COM



VCS RESTROOM RENOVATION
VOLUME 2 HHES
1009 W Klutina St, Valdez, AK 99686
CITY OF VALDEZ
LEVEL 1 DEMOLITION REFLECTED
CEILING PLANS

SHEET NO.
A121-2

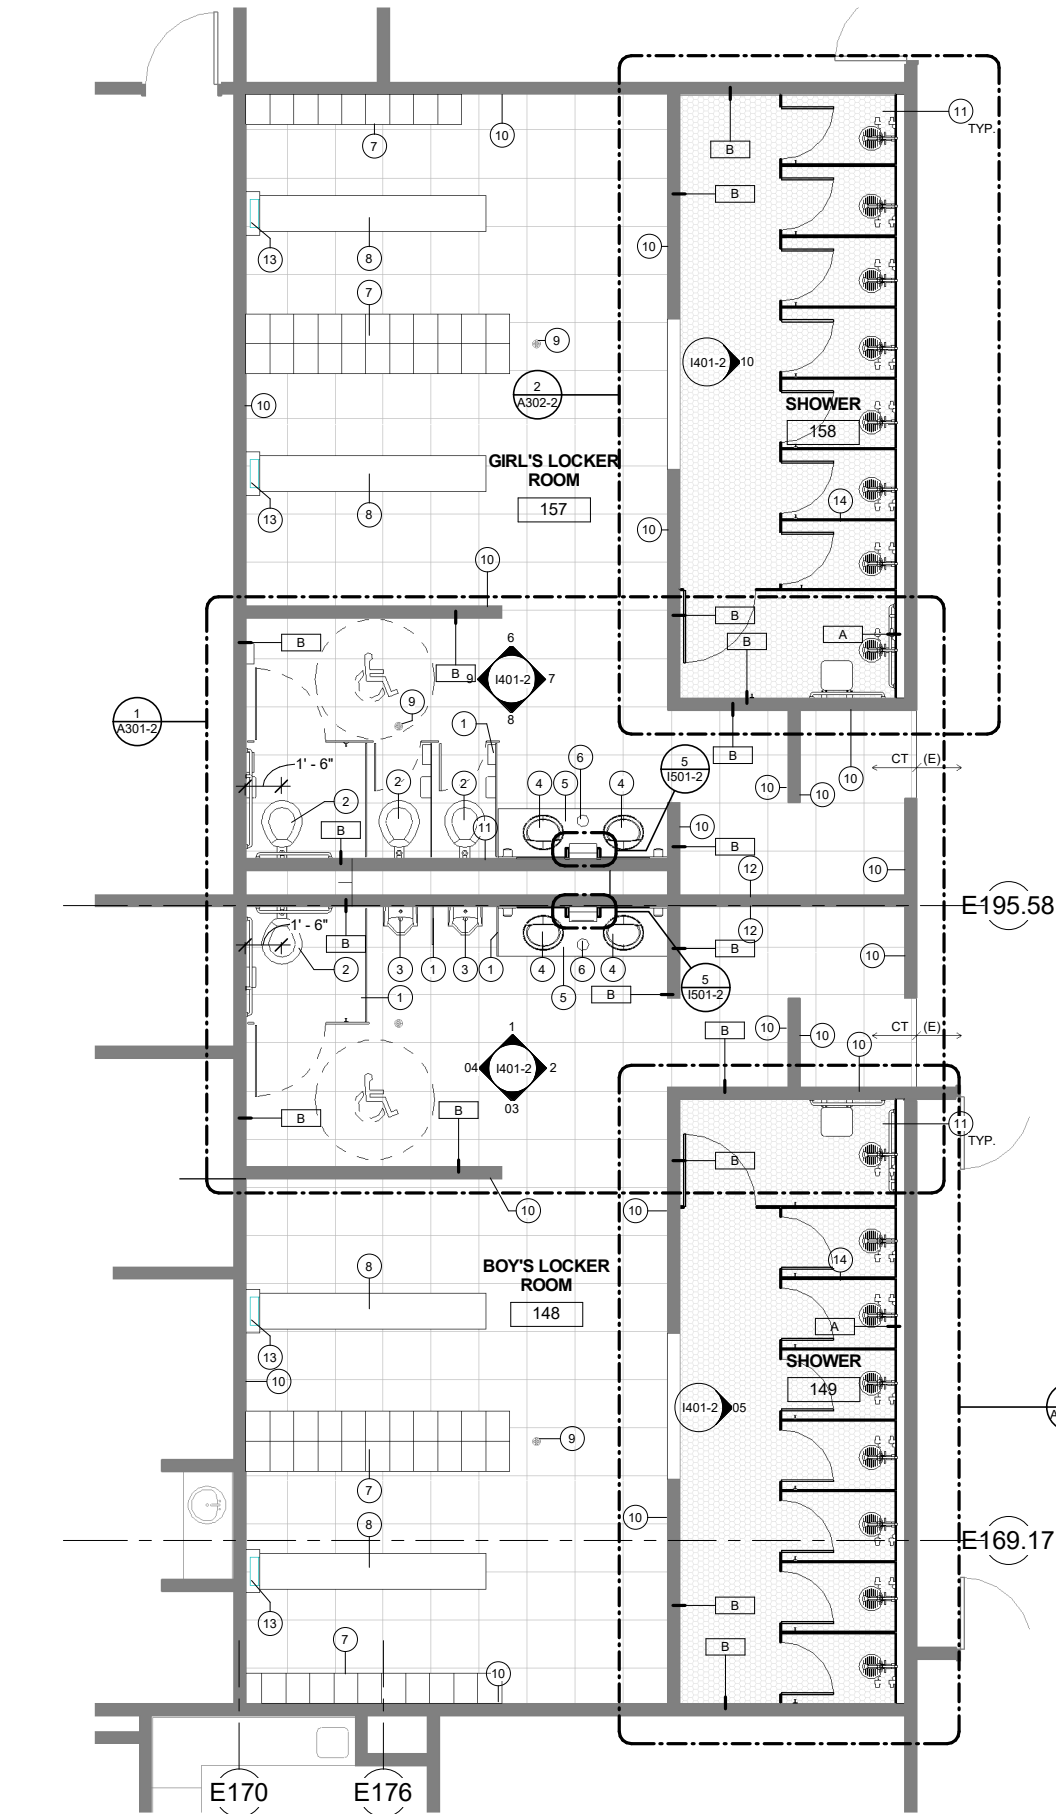

1 FLOOR PLAN - LOCKER ROOMS 148 & 157 REMODEL
A211-2 1/4" = 1'-0"

2 FLOOR PLAN - RESTROOMS 103 & 105 REMODEL
A211-2 1/4" = 1'-0"

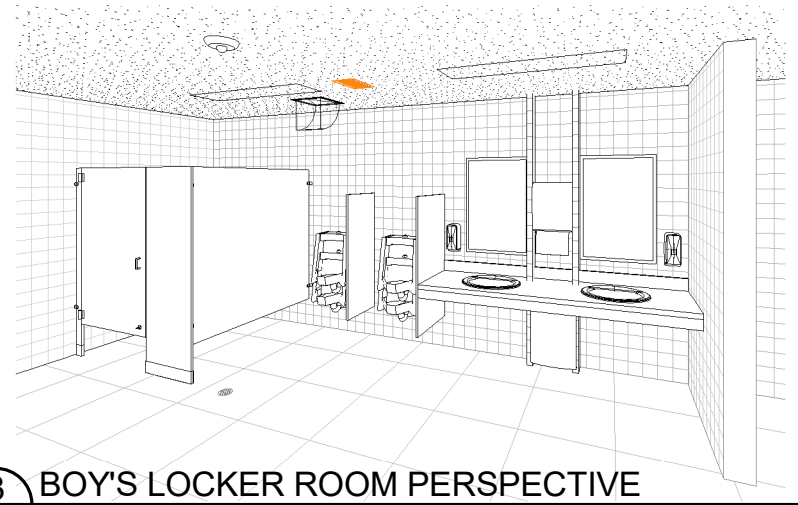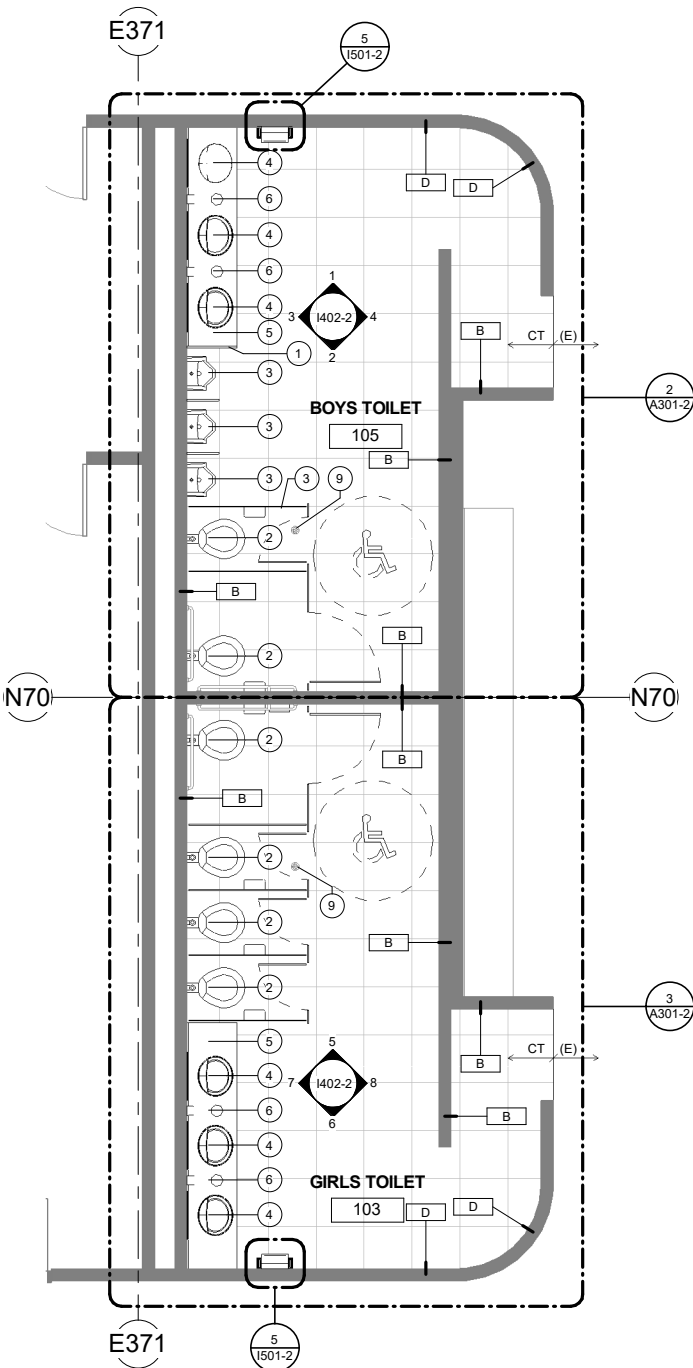


3 BOY'S LOCKER ROOM PERSPECTIVE
A211-2

FLOOR PLAN LEGEND

- 1 SHEET NOTES CALLOUT
- 0'-0" ELEVATION OF FINISH FLOOR
- Room name 101 ROOM TAG
- XXX WALL TAG - REFER TO VERTICAL ASSEMBLIES ON SHEET A060
- EXISTING WALL; SEE SHEET I501-2 FOR WALL TYPES

SHEET NOTES

- 1 INSTALL TOILET PARTITIONS, SPEC 10 21 14
- 2 INSTALL TOILET, REF MECHANICAL
- 3 INSTALL URINAL, REF MECHANICAL
- 4 INSTALL LAVATORY, REF MECHANICAL
- 5 INSTALL SOLID SURFACE COUNTER TOP AND BACKSPLASH
- 6 PROVIDE 6" DIA HOLD IN COUNTER TOP FOR TRASH, TRASH RECEPTACLE LOCATED BELOW; VERIFY LOCATION WITH OWNER
- 7 REINSTALL SALVAGED LOCKERS, ADD ALTERNATE TWO - PAINT LOCKERS
- 8 INSTALL SALVAGED BENCH REFINISH AND SEAL EXISTING WOOD TOP, REINSTALL
- 9 EXISTING DRAIN TO REMAIN
- 10 EXISTING CMU PAINT 3 COLOR SCHEME; ADD ALTERNATE ONE INSTALL TILE WALL TYPE B
- 11 INSTALL FLOOR DRAIN SEE MECHANICAL
- 12 EXISTING GWB WITH PAINT
- 13 TILE ENCLOSURE AT END OF BENCH; MATCH FLOOR TILE
- 14 TOILET PARTITION TYPICAL

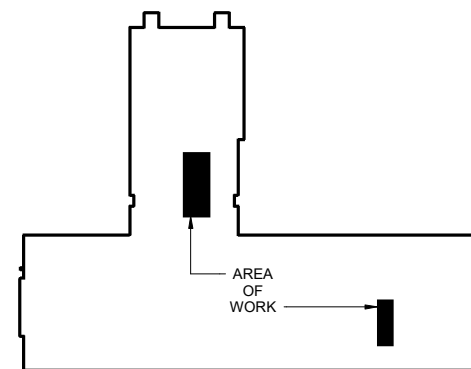

KEY PLAN
N.T.S.

REVIEWED BY: *John T. Wall*

JOB NO: 2010034401

PROJ. MGR: NMH

DRAWN BY: NR

DATE: 11/15/2017

REVISIONS:

STATE OF ALASKA

49TH

John T. Wall

EVELYN F. ROUSO

11/13/17

REGISTERED PROFESSIONAL ARCHITECT

VCS RESTROOM RENOVATION

VOLUME 2 HHES

1009 W Klutina St. Valdez, AK 99686


CITY OF VALDEZ

LEVEL 1 RESTROOM REMODEL



PLANS

SHEET NO.



A211-2

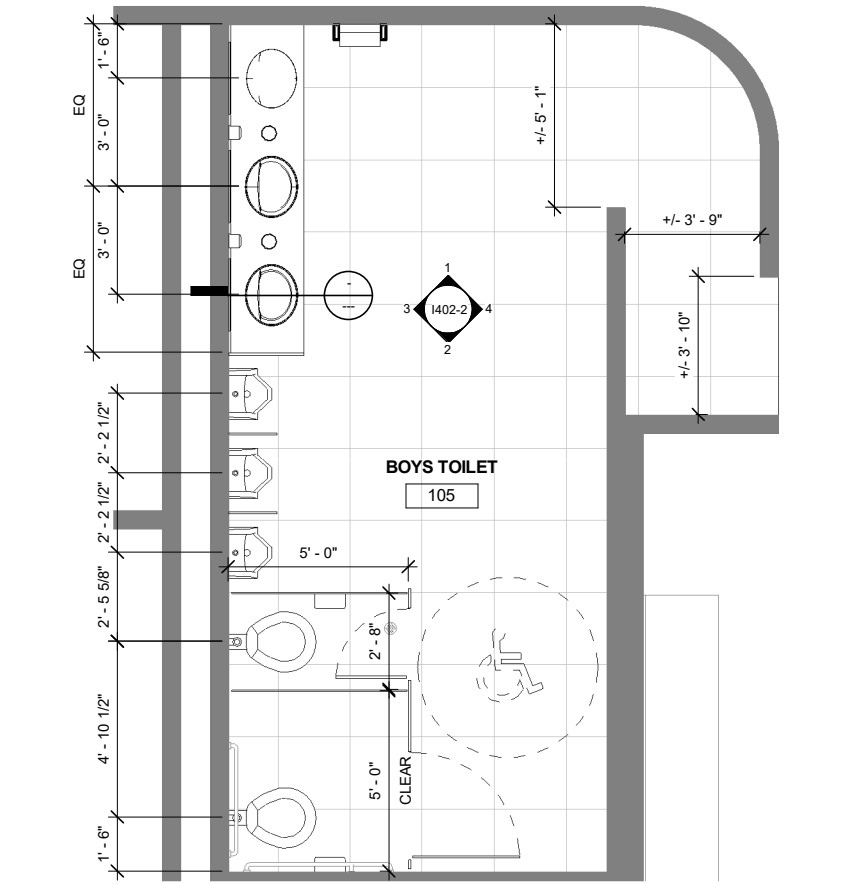


2 RESTROOMS 105 REMODEL DIMENSION PLAN
A301-2 3/8" = 1'-0"

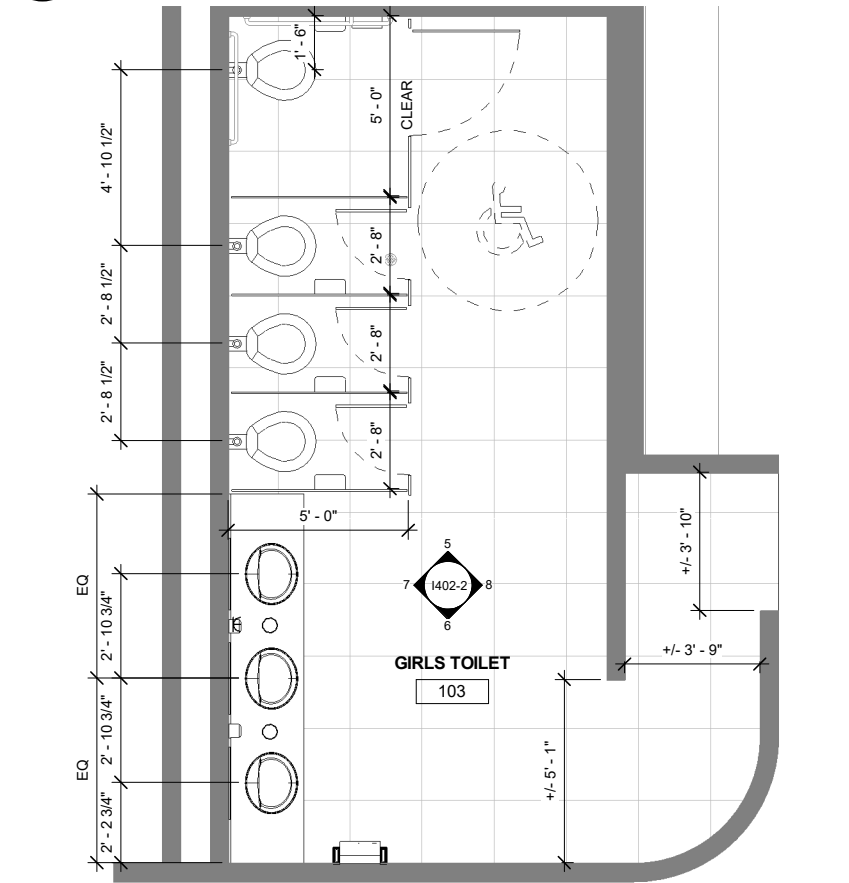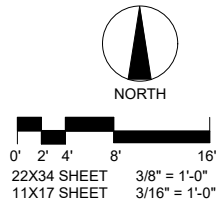

3 RESTROOMS 103 REMODEL DIMENSION PLAN
A301-2 3/8" = 1'-0"

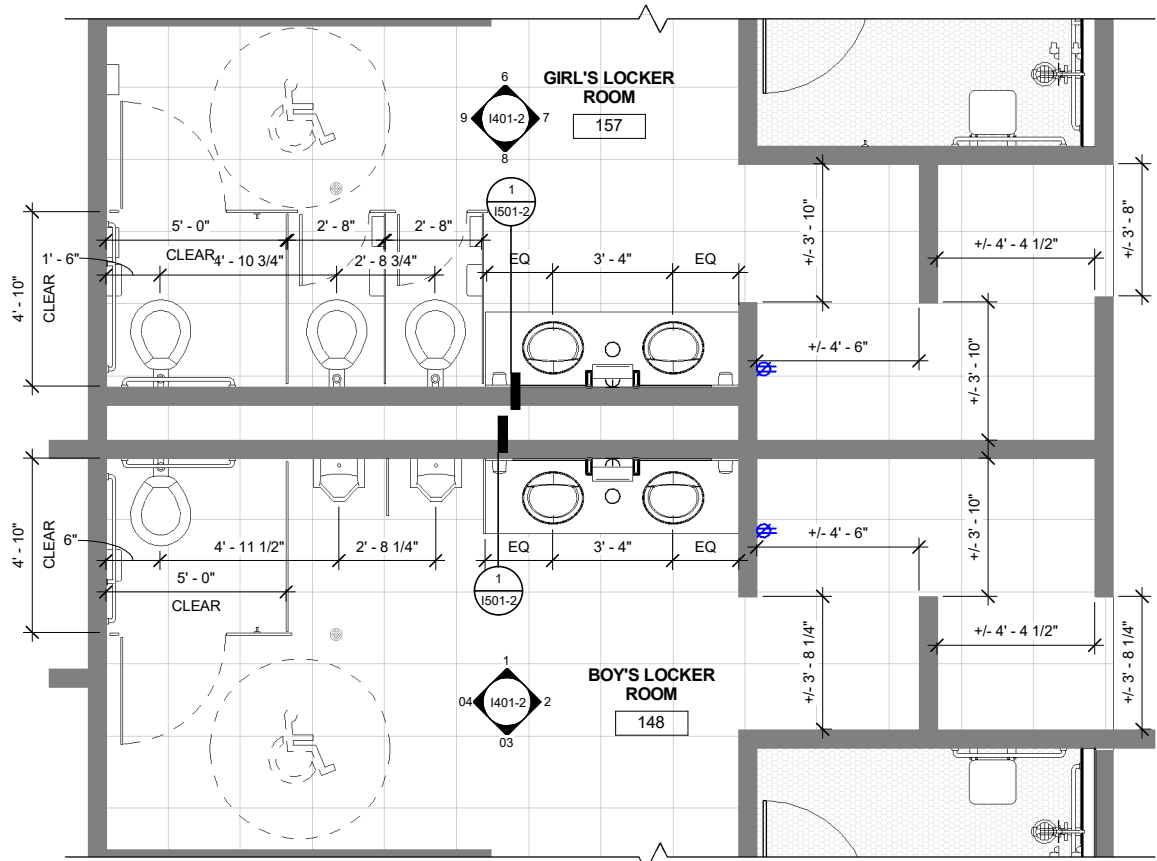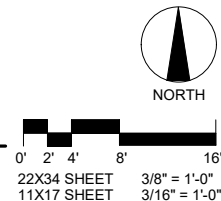

1 LOCKER ROOMS 148 & 157 DIMENSION PLAN
A301-2 3/8" = 1'-0"

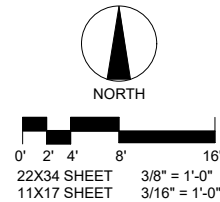

SHEET NO.

A301-2

VCS RESTROOM RENOVATION

VOLUME 2 HHES

1009 W Klutina St. Valdez, AK 99686

CITY OF VALDEZ

DIMENSION PLANS

MCCOOL CARLSON GREEN
ARCHITECTURE • PLANNING • INTERIORS
HISTORIC ANCHORAGE TRAIN DEPOT
421 W. 1ST AVENUE • SUITE 300 • ANCHORAGE, AK 99501
907.563.8474 PHONE • 907.563.4572 FAX • WWW.MCGALASKA.COM



REVIEWED BY:

John T. Wall

DATE: 11/15/2017

REVISIONS:

11/15/2017

 
11/15/2017

11/15/2017

11/15/2017



REVIEWED BY:



JOB NO: 2010034401

PROJ. MGR: NMH

DRAWN BY: NR

DATE: 11/15/2017

REVISIONS:

John T. Wall



McCOOL CARLSON GREEN

ARCHITECTURE • PLANNING • INTERIORS

HISTORIC ANCHORAGE TRAIN DEPOT

421 W. 1ST AVENUE • SUITE 300 • ANCHORAGE, AK 99501

907.563.8474 PHONE • 907.563.4572 FAX • WWW.MCGALASKA.COM

VCS RESTROOM RENOVATION

VOLUME 2 HHES

1009 W Klutina St. Valdez, AK 99686


CITY OF VALDEZ

ACCESSIBLE FIXTURE MOUNTING

HEIGHTS

SHEET NO.

A303-2

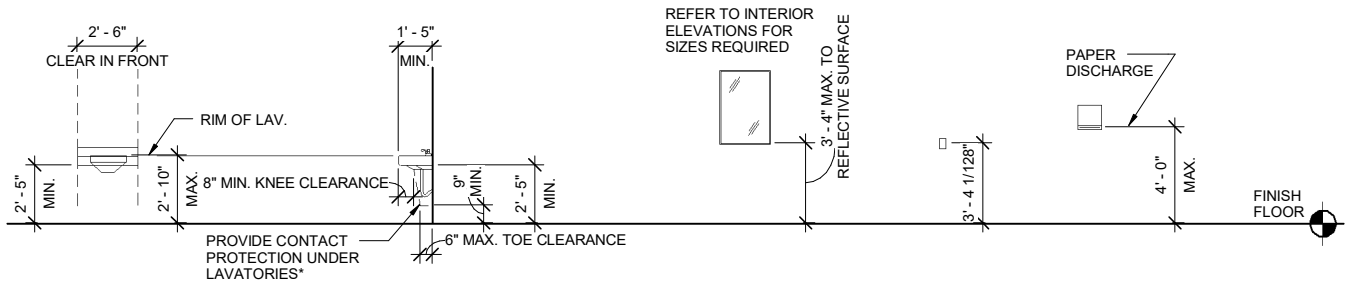


LAVATORY (LAV)

MIRROR (MI)

WALL MOUNT SOAP DISPENSER

TOWEL DISPENSER (TD)

* WATER SUPPLY AND DRAIN PIPES UNDER LAVATORIES AND SINK SHALL BE INSULATED OR OTHERWISE CONFIGURED TO PROTECT AGAINST CONTACT, AND THERE SHALL BE NO ABRASIVE SURFACE UNDER LAVATORIES OR SINKS.



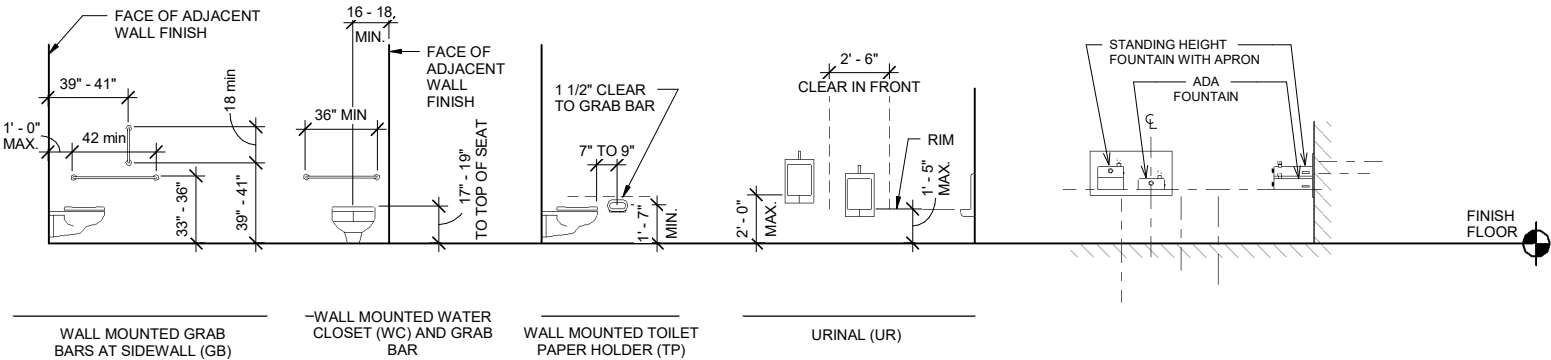


WALL MOUNTED GRAB BARS AT SIDEWALL (GB)

WALL MOUNTED WATER CLOSET (WC) AND GRAB BAR

WALL MOUNTED TOILET PAPER HOLDER (TP)

URINAL (UR)

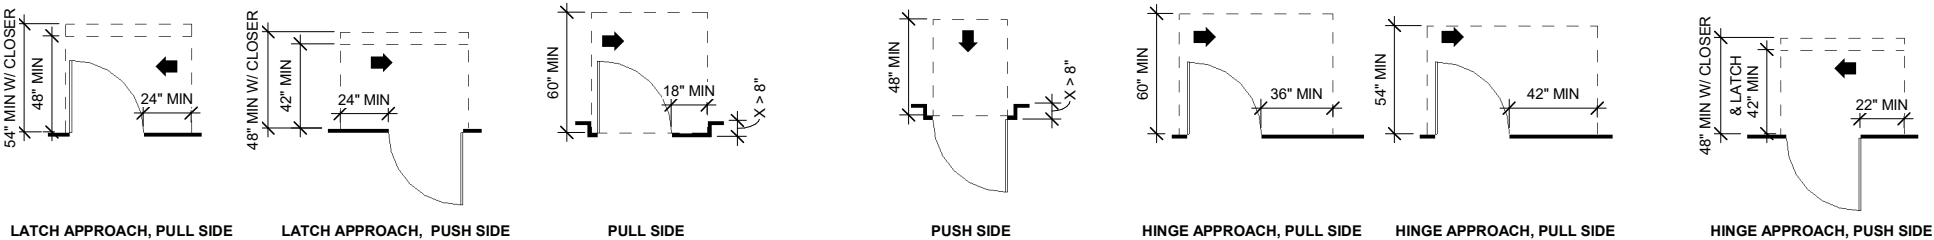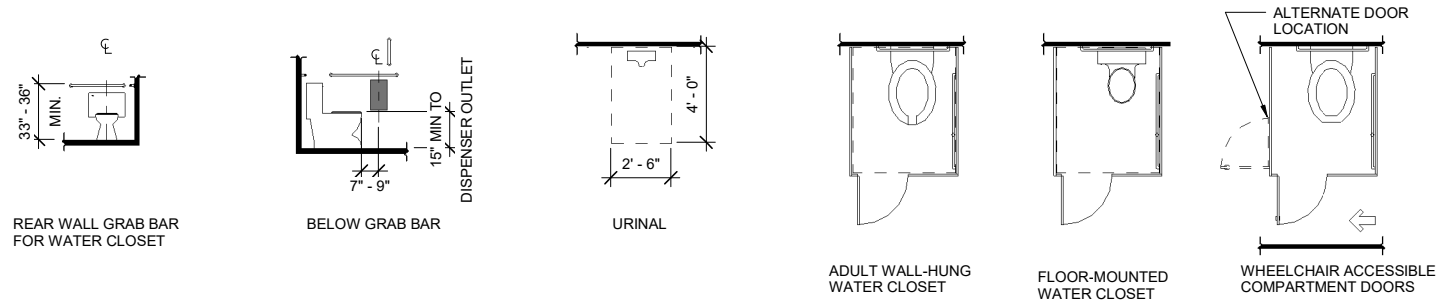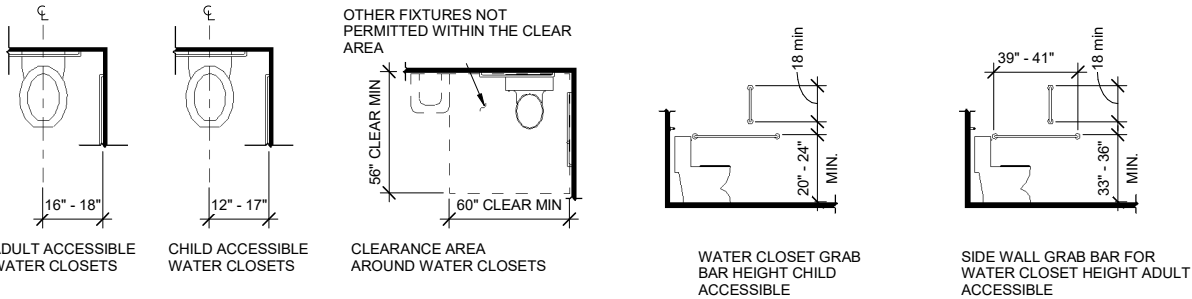

*12 MIN REQUIRED IF BOTH CLOSER AND LATCH ARE PROVIDED

* IF BOTH CLOSER AND LATCH ARE PROVIDED

CERAMIC TILE SCHEDULE - BASIS OF DESIGN TILE PRODUCTS BY DAL TILE															
ROOM NUMBER	NAME	FLOOR				BASE				WALL					
		PRODUCT	SIZE	COMMENTS	COLOR	PRODUCT	TYPE	SIZE	COLOR	PRODUCT	SIZE	FIELD COLOR	ACCENT COLOR 1	ACCENT COLOR 2	ACCENT COLOR 3
103	GIRLS TOILET	AMBASSADOR	12" X 24"	UNPOLISHED	AM 36 WANDERLUST WHITE	TRIM	SCHLUTE R	11/16" RADIUS	ST. STL.	NATURAL HUES	4¼ X 4¼	PEARL WHITE QH 63	ROMA RED QH 96	PINE QH 64	ATLANTIS QH 43
105	BOYS TOILET	AMBASSADOR	12" X 24"	UNPOLISHED	AM 36 WANDERLUST WHITE	TRIM	SCHLUTE R	11/16" RADIUS	ST. STL.	NATURAL HUES	4¼ X 4¼	PEARL WHITE QH 63	ROMA RED QH 96	PINE QH 64	ATLANTIS QH 43
148	BOY'S LOCKER ROOM	AMBASSADOR	12" X 24"	UNPOLISHED	AM 36 WANDERLUST WHITE	TRIM	SCHLUTE R	11/16" RADIUS	ST. STL.	NATURAL HUES	4¼ X 4¼	PEARL WHITE QH 63	ROMA RED QH 96	PINE QH 64	ATLANTIS QH 43
149	SHOWER	KEYSTONES	2" HEXAGON	ABRASIVE CONTENT	PEPPER WHITE DO 37	KEYSTONES	COVE BUILD UP	(2) ROWS 2"	MATCH FLOOR	NATURAL HUES	4¼ X 4¼	PEARL WHITE QH 63	ROMA RED QH 96	PINE QH 64	ATLANTIS QH 43
157	GIRL'S LOCKER ROOM	AMBASSADOR	12" X 24"	UNPOLISHED	AM 36 WANDERLUST WHITE	TRIM	SCHLUTE R	11/16" RADIUS	ST. STL.	NATURAL HUES	4¼ X 4¼	PEARL WHITE QH 63	ROMA RED QH 96	PINE QH 64	ATLANTIS QH 43
158	SHOWER	KEYSTONES	2" HEXAGON	ABRASIVE CONTENT	PEPPER WHITE DO 37	KEYSTONES	COVE BUILD UP	(2) ROWS 2"	MATCH FLOOR	NATURAL HUES	4¼ X 4¼	PEARL WHITE QH 63	ROMA RED QH 96	PINE QH 64	ATLANTIS QH 43

ABBREVIATIONS

TBD - TO BE DECIDED

NOTES

 
1.
- PREP ALL EXISTING WALL SUBSTRATE AS RECOMMENDED BY TILE MANUFACTURER.
2.
- SEE A211 FOR WALL TYPE AT EACH LOCATION

JOB NO: 201003401

PROJ. MGR: NMH

DRAWN BY: NR

DATE: 11/15/2017

REVIEWED BY: 

John T. Wall

REVISIONS:





MCCOOL CARLSON GREEN
ARCHITECTURE • PLANNING • INTERIORS
HISTORIC ANCHORAGE TRAIN DEPOT
421 W. 1ST AVENUE • SUITE 300 • ANCHORAGE, AK 99501
907.563.8474 PHONE • 907.563.4572 FAX • WWW.MCGALASKA.COM

VCS RESTROOM RENOVATION
VOLUME 2 HHES
1009 W Klutina St, Valdez, AK 99686
CITY OF VALDEZ

SCHEDULES

SHEET NO.

A701-2

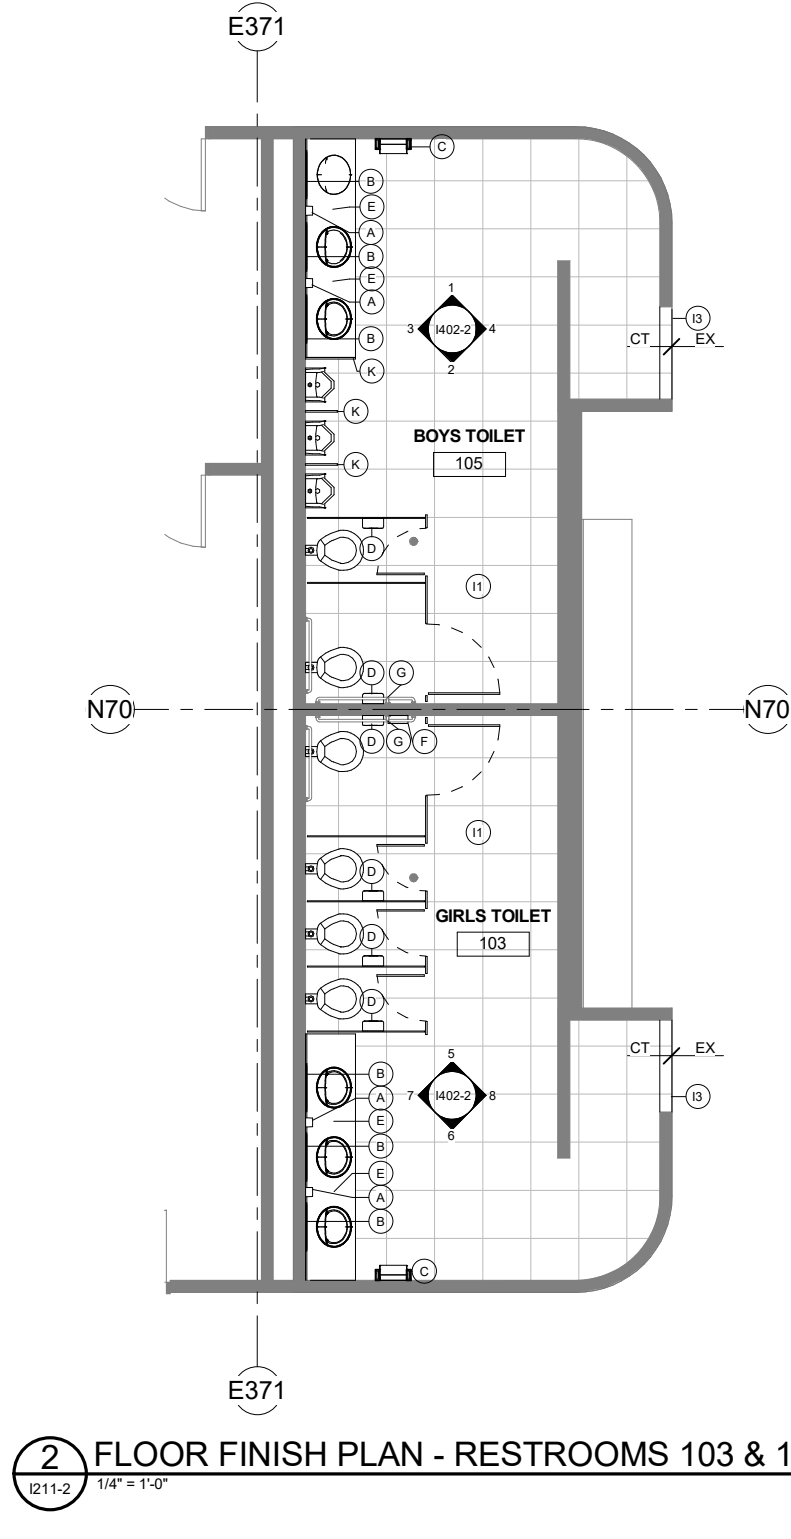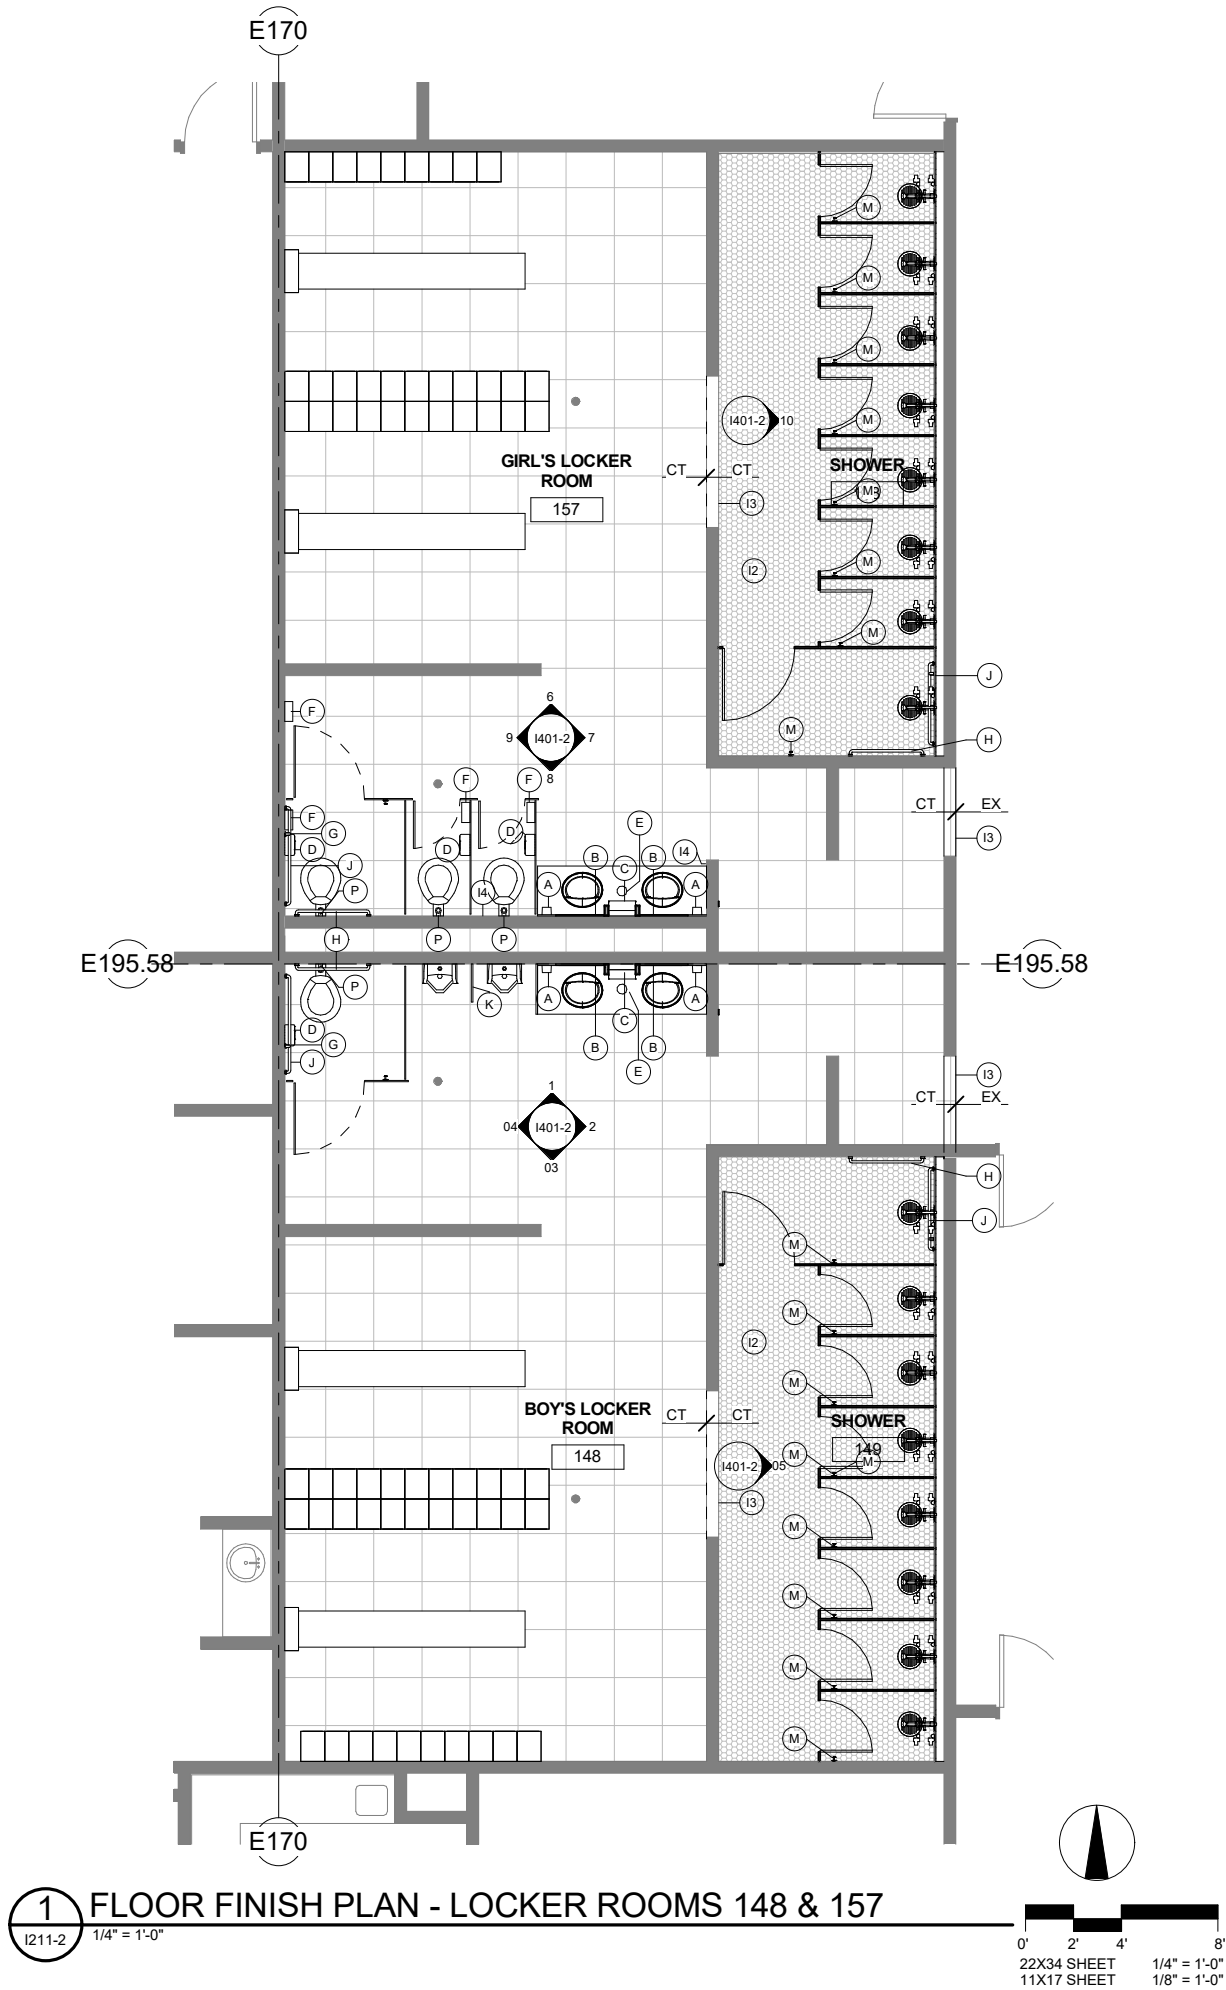

FLOOR FINISH LEGEND

EX	FINISH	STOP/START POINT FOR FLOOR FINISHES
o	FD	FLOOR DRAIN; REFER TO A701-2 FOR MORE INFORMATION
11		CT CERAMIC FLOOR TILE
12		CT2 CERAMIC MOSAIC FLOOR TILE

SHEET NOTES

- 11 INSTALL CERAMIC FLOOR TILE
- 12 INSTALL CERAMIC TILE FLOOR MOSAIC
- 13 STONE THRESHOLD

TOILET ACCESSORIES LEGEND

REFER TO SPEC 10 28 13

- A SOAP DISPENSER
- B 24"X36" MIRROR
- C PAPER TOWEL DISPENSER
- D TOILET PAPER DISPENSER - SEE DETAIL 4 AND 5/1501-2
- E WASTE RECEPTICAL FREE STANDING UNDERCOUNTER
- F FEMININE NAPKIN DISPOSAL
- G 18" VERTICAL BAR
- H 36" LONG - GRAB BAR - CHILD HEIGHT ROOMS 103 AND 105
- J 42" LONG - GRAB BAR - CHILD HEIGHT ROOMS 103 AND 105
- K 12" WIDE X 42" LENGTH - URINAL PARTITION
- L FOLD DOWNSEAT
- M TOWEL HOOK
- O SHOWER PARTITION
- P TOILET SEAT COVER DISPENSER ABOVE TOILET

REVIEWED BY: *John T. Wall*

JOB NO. 2016034401

PROJ. MGR. NMH

DRAWN BY: NR

DATE: 11/15/2017

REVISIONS:

STATE OF ALASKA

49TH

John F. Rouso

EVERLYN F. ROUSSO

A-11472

11/13/17

REGISTERED PROFESSIONAL ARCHITECT

MCCOOL CARLSON GREEN

ARCHITECTURE • PLANNING • INTERIORS

HISTORIC ANCHORAGE TRAIN DEPOT

421 W. 1ST AVENUE • SUITE 300 • ANCHORAGE, AK 99501

907.563.8474 PHONE • 907.563.4572 FAX • WWW.MCGALASKA.COM

VCS RESTROOM RENOVATION

VOLUME 2 HHES

1009 W Klutina St. Valdez, AK 99686


CITY OF VALDEZ

FINISH AND ACCESSORIES PLAN -


LEVEL 1

SHEET NO.

1211-2

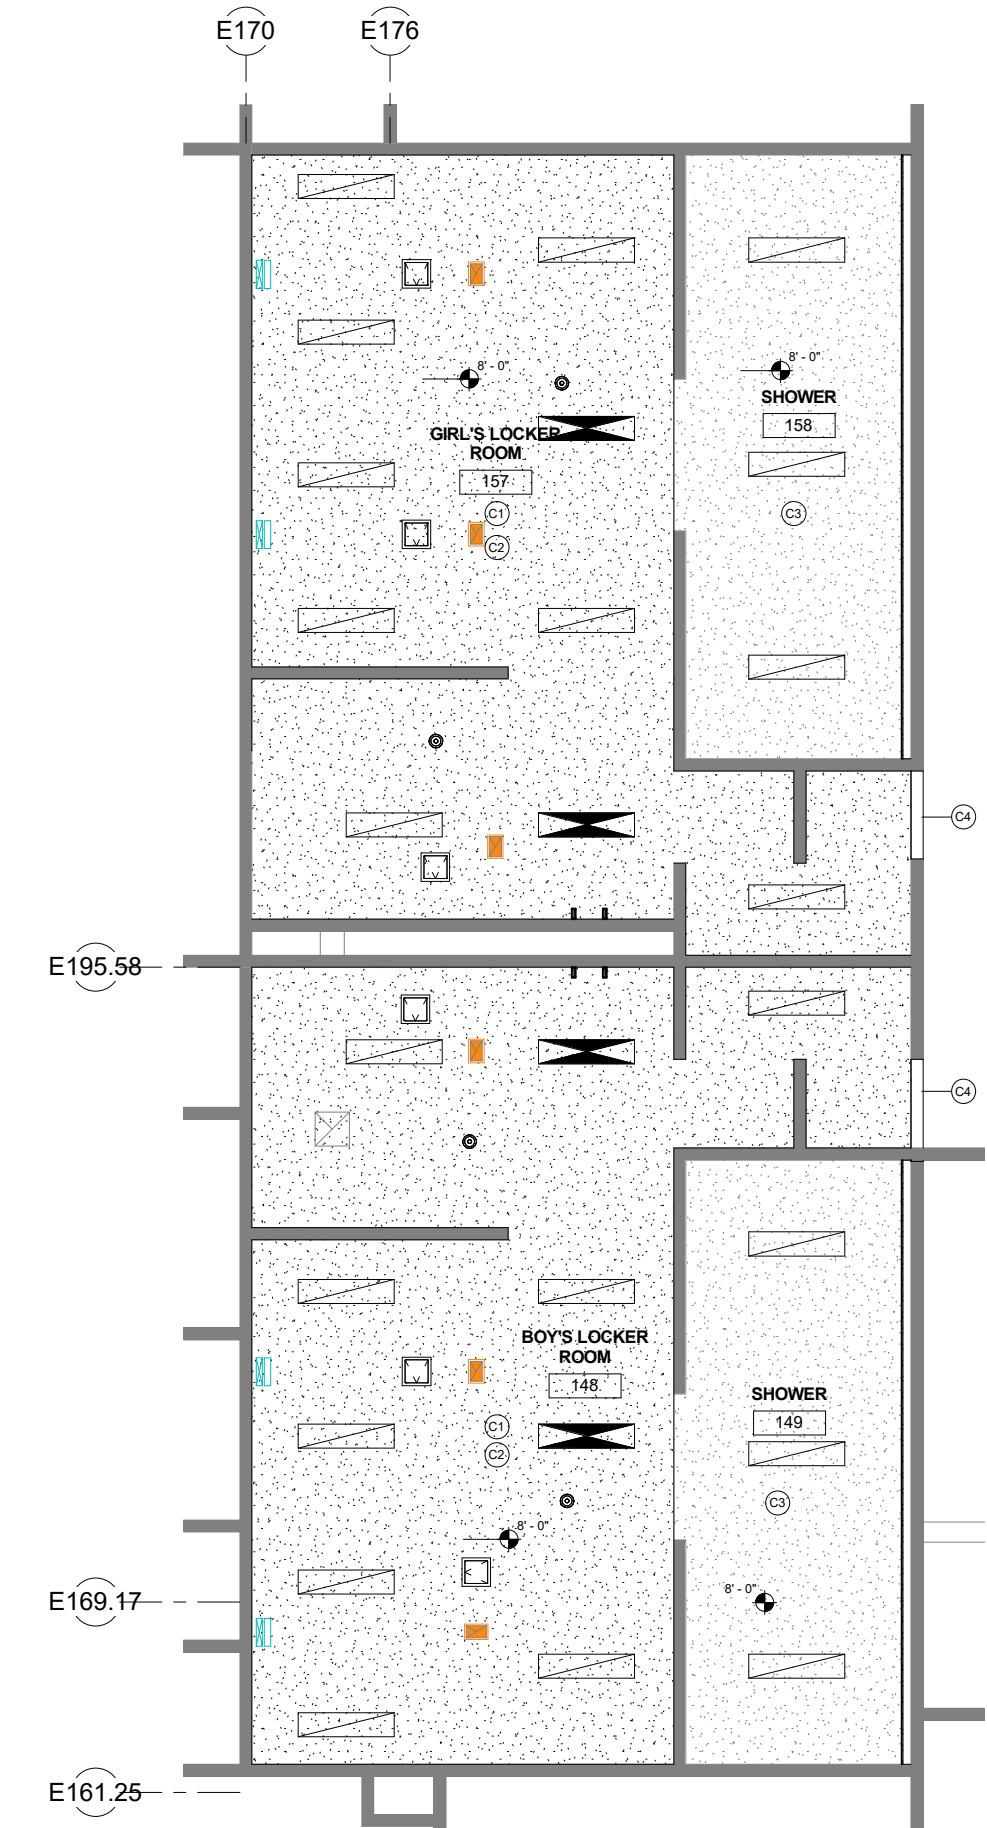

1 REFLECTED CEILING PLAN - LOCKER ROOMS 148 & 157
1/4" = 1'-0"

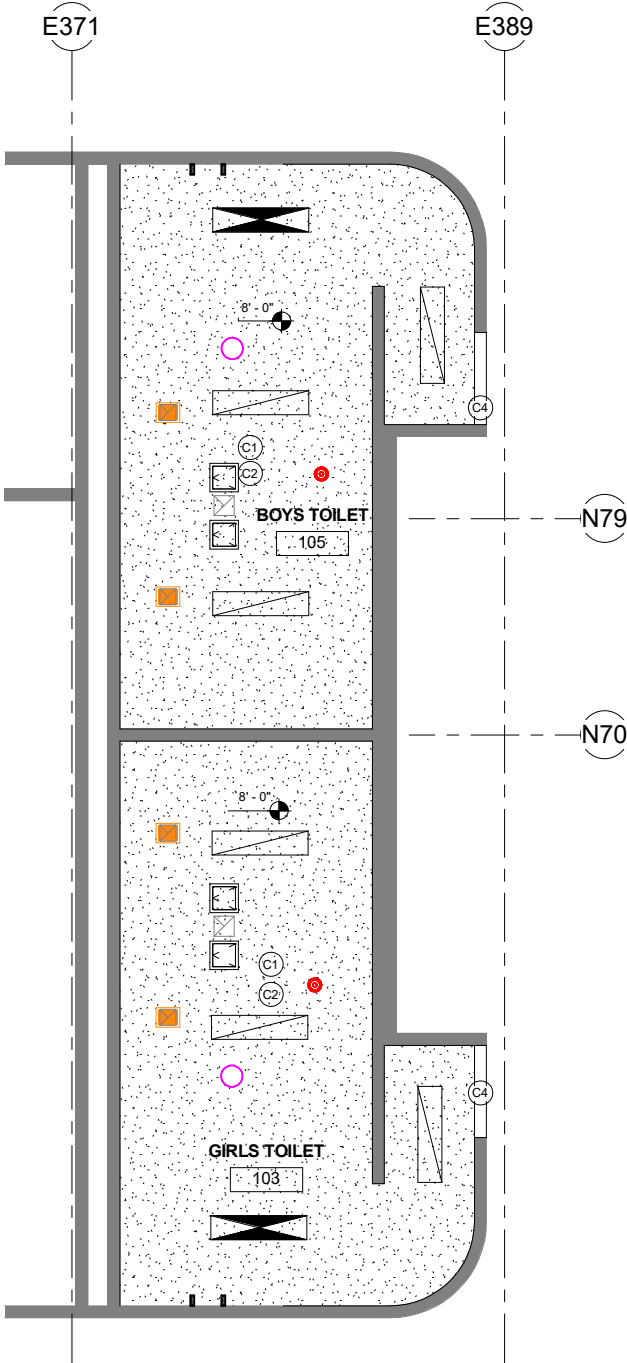

2 REFLECTED CEILING PLAN - 103 & 105
1/4" = 1'-0"

SHEET NOTES

- C1 GYPSUM CEILING, PAINT
- C2 INSTALL LIGHTOMH, ELEC DEVICES, MECH DIFFUSER, REF ELEC. & MECH. DRAWINGS
- C3 FINISH EXISTING CEILING
- C4 FINISH EXISTING SOFFIT

CEILING LEGEND

- 1 SHEET NOTES CALLOUT
- 0'-0" ELEVATION OF CEILING
- Room name 101 ROOM TAG
- EXISTING WALL
- EXISTING CEILING
- EXISTING GYPSUM CEILING
- GYPSUM CEILING
- LIGHTS; REFER TO ELECTRICAL
- FIRE ALARM
- DIFFUSERS; REFER TO MECHANICAL
- 12" x 12" ACCESS PANEL, PT
- DUCT; REFER TO MECHANICAL

JOB NO: 2010034401
PROJ. MGR: NMH
DRAWN BY: NR
DATE: 11/15/2017
REVISIONS:


REVIEWED BY: *John T. Wall*
John T. Wall




MCCOOL CARLSON GREEN
ARCHITECTURE • PLANNING • INTERIORS
HISTORIC ANCHORAGE TRAIN DEPOT
421 W. 1ST AVENUE • SUITE 300 • ANCHORAGE, AK 99501
907.563.8474 PHONE • 907.563.4572 FAX • WWW.MCGALASKA.COM

VCS RESTROOM RENOVATION
VOLUME 2 HHES
1009 W Klutina St, Valdez, AK 99686
CITY OF VALDEZ
REFLECTED CEILING PLAN -
LEVEL 1


SHEET NO.
1311-2

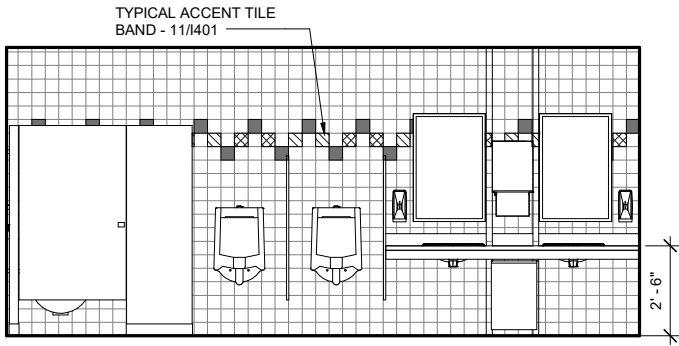


1 LOCKER 148 NORTH
I401-2 3/8" = 1'-0"

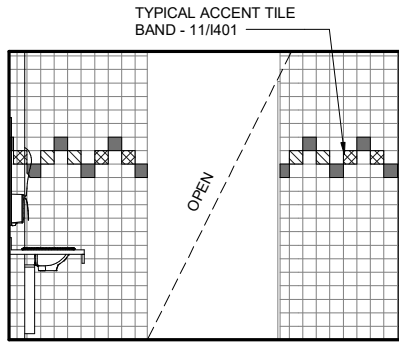


2 LOCKER 148 EAST
I401-2 3/8" = 1'-0"

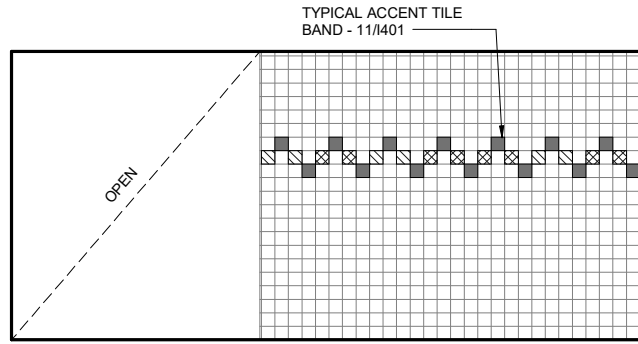


03 LOCKER 148 SOUTH
I401-2 3/8" = 1'-0"

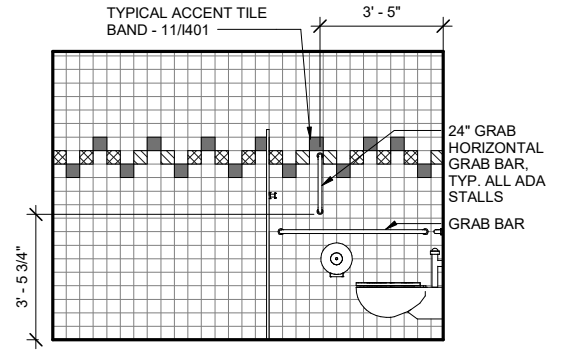


04 LOCKER 148 WEST
I401-2 3/8" = 1'-0"

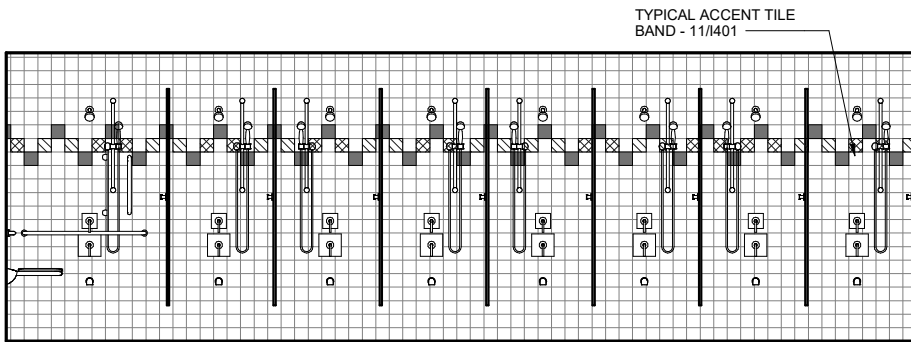


05 SHOWER 149 EAST
I401-2 3/8" = 1'-0"

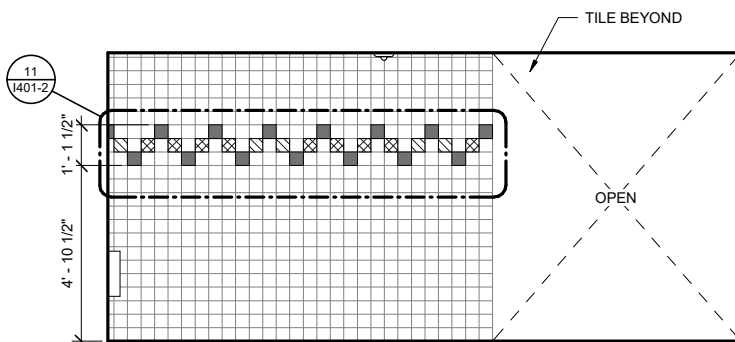


6 LOCKER 157 NORTH
I401-2 3/8" = 1'-0"
TYPICAL TILE PATTERN

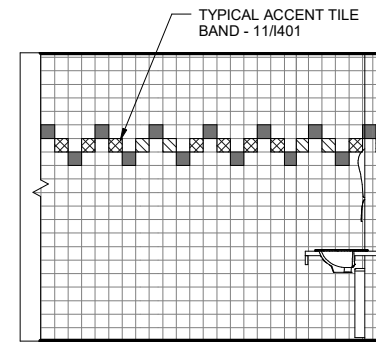


7 LOCKER 157 EAST
I401-2 3/8" = 1'-0"

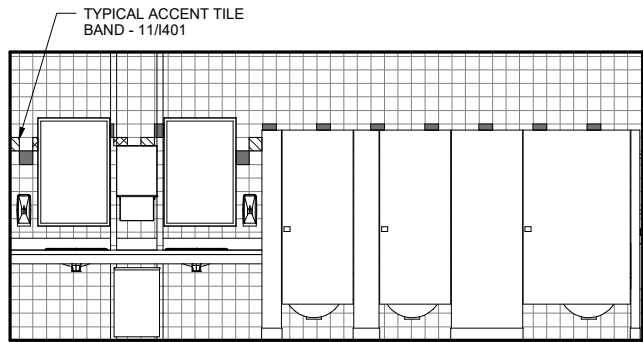


8 LOCKER 157 SOUTH
I401-2 3/8" = 1'-0"

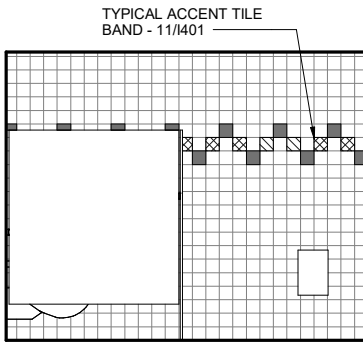

9 LOCKER 157 WEST
I401-2 3/8" = 1'-0"

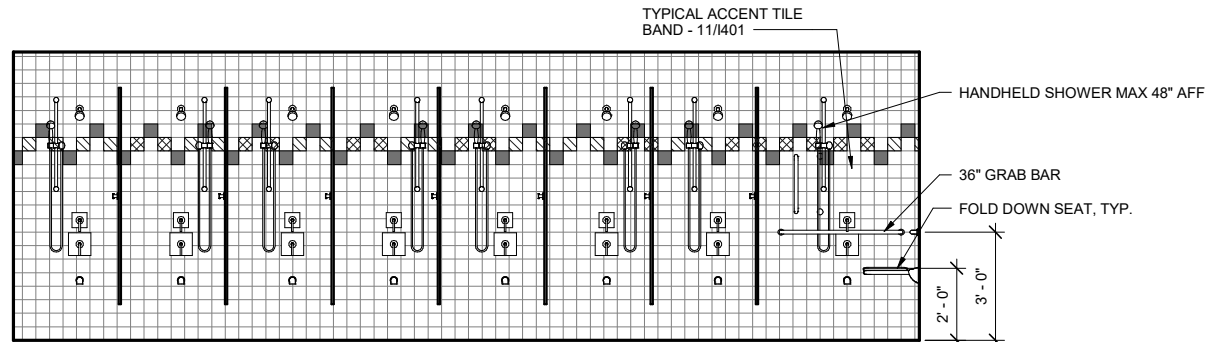

10 SHOWER 158 EAST
I401-2 3/8" = 1'-0"

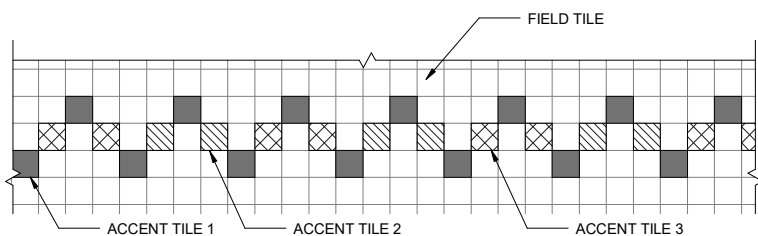

11 TYPICAL TILE PATTERN
I401-2 3/4" = 1'-0"



MCCOOL CARLSON GREEN
ARCHITECTURE • PLANNING • INTERIORS
HISTORIC ANCHORAGE TRAIN DEPOT
421 W. 1ST AVENUE • SUITE 300 • ANCHORAGE, AK 99501
907.563.8474 PHONE • 907.563.4572 FAX • WWW.MCGALASKA.COM

VCS RESTROOM RENOVATION

VOLUME 2 HHES


1009 W Klutina St. Valdez, AK 99686

CITY OF VALDEZ


INTERIOR ELEVATIONS

SHEET NO.


I401-2

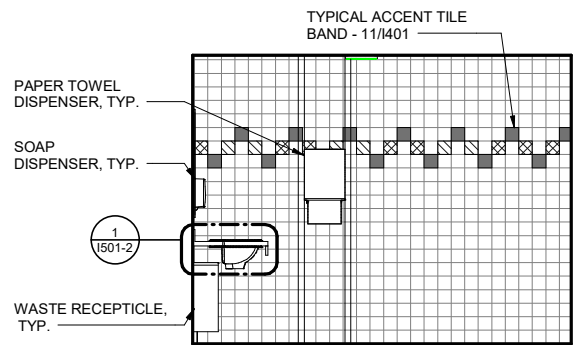


1 TOILET 105 NORTH
I402-2 3/8" = 1'-0"

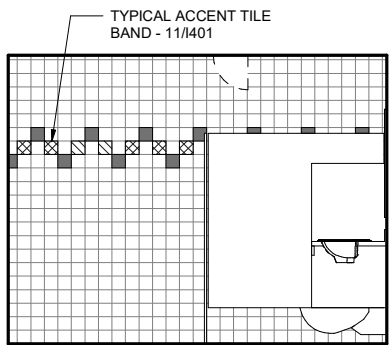


2 TOILET 105 SOUTH
I402-2 3/8" = 1'-0"

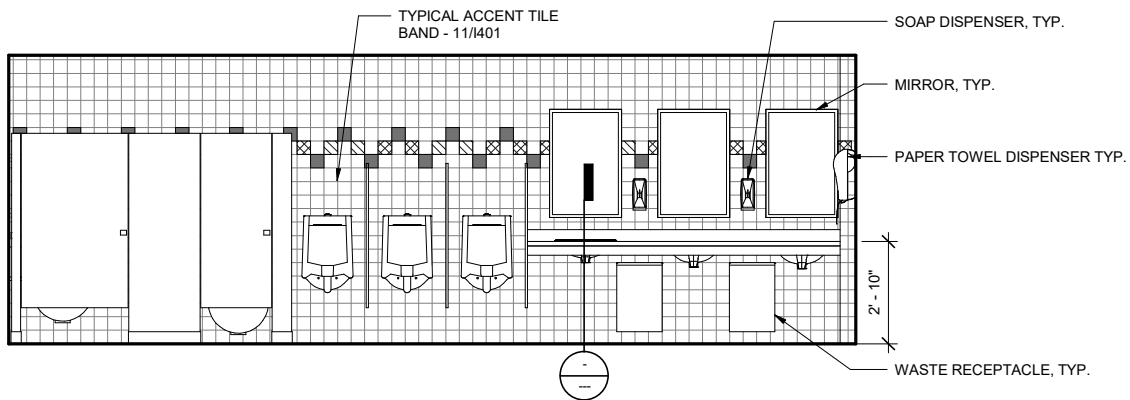


3 TOILET 105 WEST
I402-2 3/8" = 1'-0"

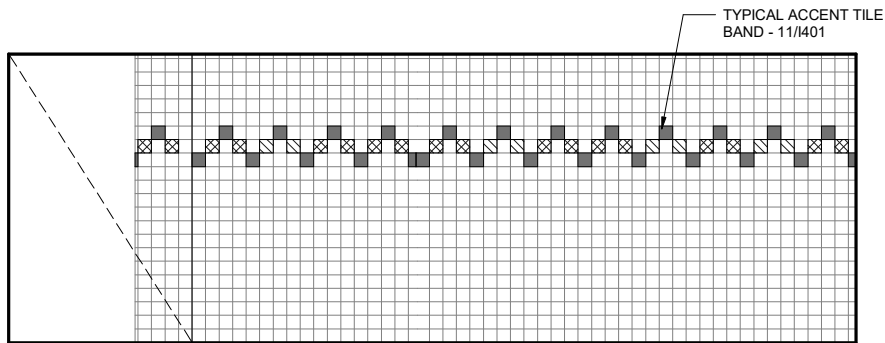


4 TOILET 105 EAST
I402-2 3/8" = 1'-0"

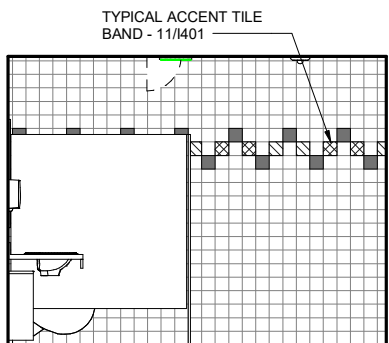


5 TOILET 103 NORTH
I402-2 3/8" = 1'-0"

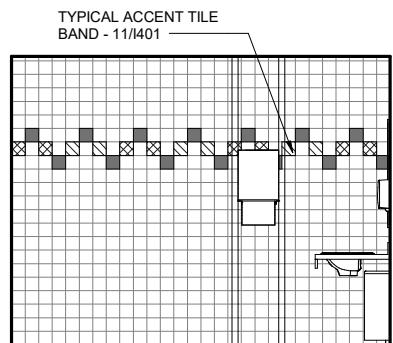

6 TOILET 103 SOUTH
I402-2 3/8" = 1'-0"

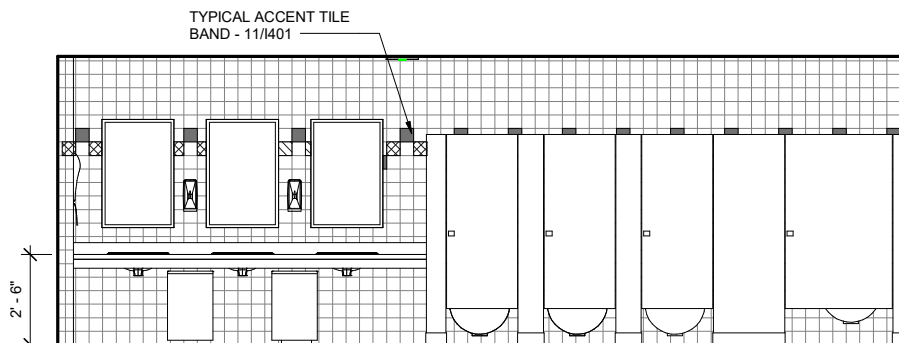

7 TOILET 103 WEST
I402-2 3/8" = 1'-0"

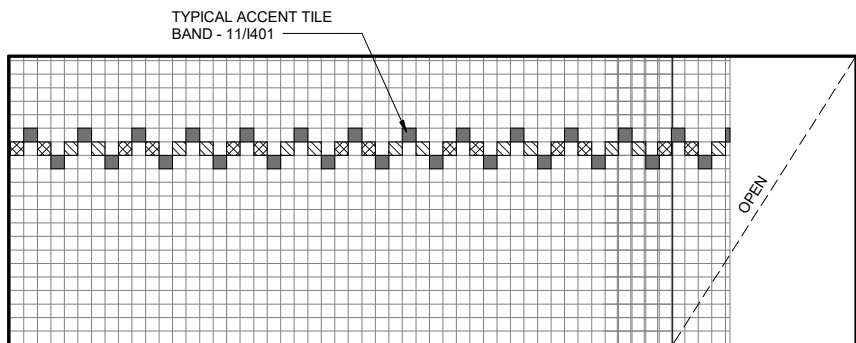

8 TOILET 103 EAST
I402-2 3/8" = 1'-0"

JOB NO. 2010034401	REVIEWED BY: <i>[Signature]</i>
PROJ. MGR.: NMH	DATE: 11/15/2017
DRAWN BY: NR	REVISIONS:
	John T. Wall




MCCOOL CARLSON GREEN
ARCHITECTURE • PLANNING • INTERIORS
HISTORIC ANCHORAGE TRAIN DEPOT
421 W. 1ST AVENUE • SUITE 300 • ANCHORAGE, AK 99501
907.563.8474 PHONE • 907.563.4572 FAX • WWW.MCGALASKA.COM

VCS RESTROOM RENOVATION
VOLUME 2 HHES
1009 W Klutina St. Valdez, AK 99686
CITY OF VALDEZ


INTERIOR ELEVATIONS

SHEET NO.
I402-2

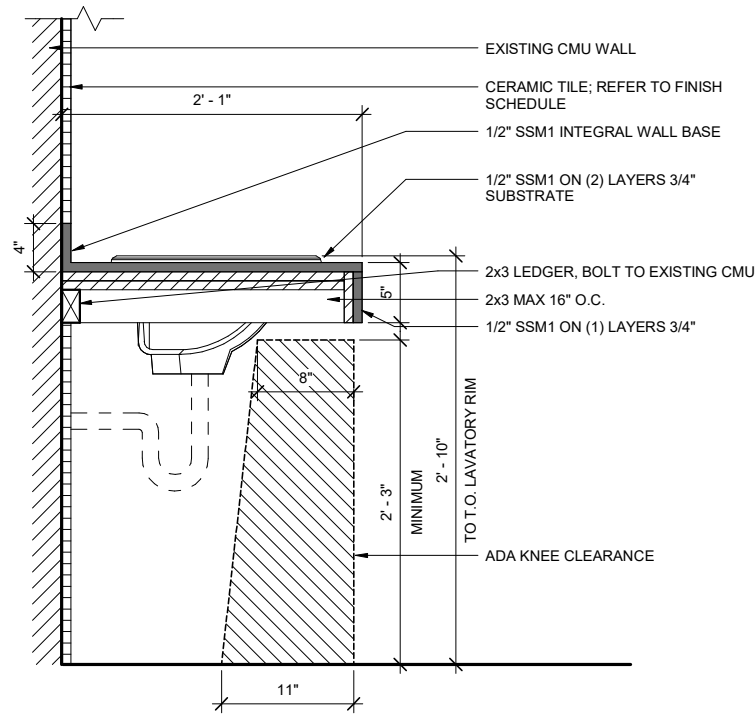


1 COUNTER DETAIL

I501-2 1 1/2" = 1'-0"

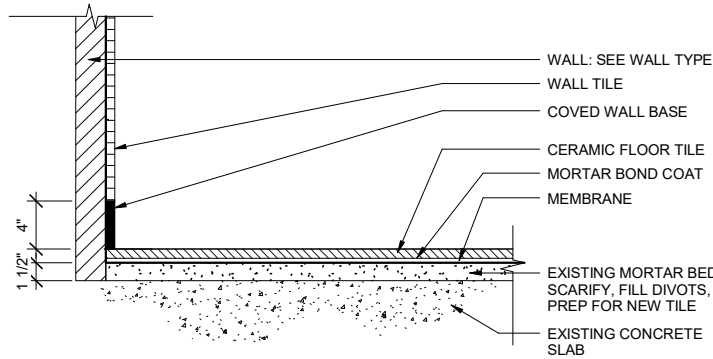


2 CERAMIC TILE FLOOR ASSEMBLY - SHOWER

I501-2 1 1/2" = 1'-0"

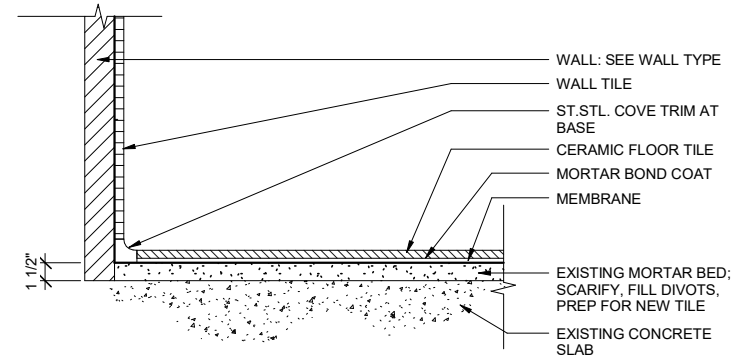


3 CERAMIC TILE FLOOR ASSEMBLY - TOILET ROOMS


I501-2 1 1/2" = 1'-0"

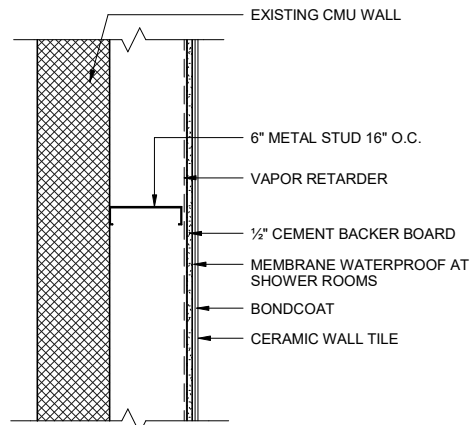


A

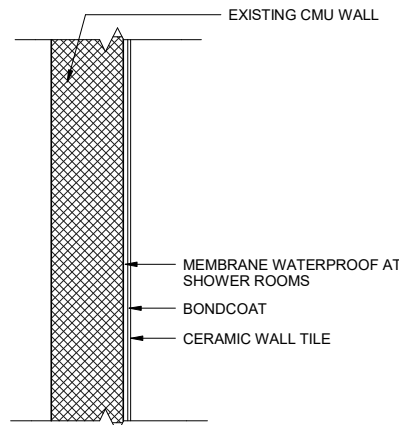

B

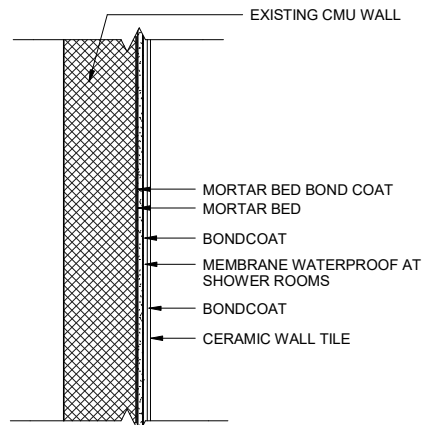

C

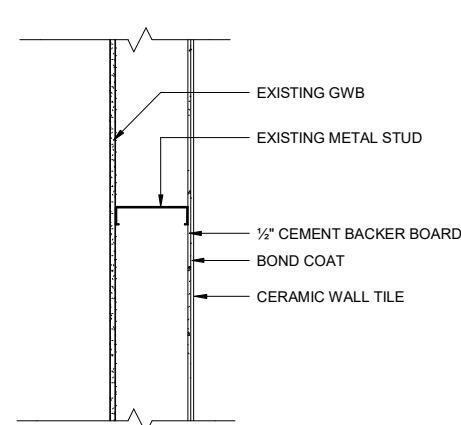


D

4 WALL TYPES


I501-2 1 1/2" = 1'-0"

NOTE: NEW TILE FINISHES TO UNDERSIDE OF GWB CEILING.

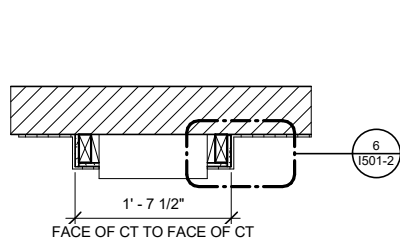

5 PLAN AT PAPER TOWEL DISPENSER

I501-2 1" = 1'-0"

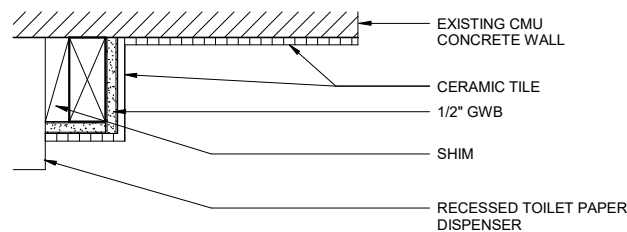

6 DETAIL

I501-2 3" = 1'-0"

REVIEWED BY:	<i>John T. Wall</i>
JOB NO. 201003401	PROJ. MGR. NMH
DRAWN BY: NR	DATE: 11/15/2017
REVISIONS:	



MCCOOL CARLSON GREEN
 ARCHITECTURE • PLANNING • INTERIORS
 HISTORIC ANCHORAGE TRAIN DEPOT
 421 W. 1ST AVENUE • SUITE 300 • ANCHORAGE, AK 99501
 907.563.8474 PHONE • 907.563.4572 FAX • WWW.MCGALASKA.COM

VCS RESTROOM RENOVATION

VOLUME 2 HHES

1009 W Klutina St. Valdez, AK 99686

CITY OF VALDEZ

INTERIOR DETAILS

SHEET NO.

I501-2

PIPING LEGEND

	DENOTES DEMOLITION
	WASTE
	VENT PIPING
	COLD WATER
	HOT WATER
	HOT WATER RECIRCULATED
	SEE ABBREVIATIONS FOR MEDIA
	PIPE UP
	PIPE DOWN
	TEE UP
	TEE DOWN
	CAP
	UNION
	DIRECTION OF FLOW
	BALL VALVE
	BALANCE/GLOBE VALVE
	HOSE BIBB
	WATER HAMMER ARRESTOR
	FLOOR CLEANOUT
	FLOOR DRAIN

DUCTWORK LEGEND


	THERMOSTAT OR SENSOR
	SUPPLY AIR UP & DOWN
	RETURN AIR UP & DOWN
	EXHAUST AIR UP & DOWN
	VOLUME DAMPER
	DUCT SIZE - EXTERIOR INSULATED (1ST FIGURE-SIDE SHOWN) (2ND FIGURE-SIDE NOT SHOWN)

LOGIC

	POINT OF CONNECTION
	DETAIL NUMBER
	SHEET LOCATED ON
	SHEET NOTES
	CONNECTION
	NECK SIZE
	CFM
	DIFFUSER OR GRILLE TYPE

ABBREVIATIONS

ADA	AMERICANS WITH DISABILITIES ACT GUIDELINES
AD	ACCESS DOOR
ARCH	ARCHITECTURAL
CONT	CONTINUED
C.O./CO	CLEANOUT
CFM	CUBIC FEET PER MINUTE
CW	COLD WATER
DEG	DEGREE
DIA	DIAMETER
DWG	DRAWING
E/A	EXHAUST AIR
EXIST	EXISTING
(E)	EXISTING
FCO	FLOOR CLEAN OUT
GAL	GALLONS
GPM	GALLONS PER MINUTE
HB-X	HOSE BIBB DESIGNATOR
HW	HOT WATER
HWC	HOT WATER CIRCULATED
MFGR	MANUFACTURER
NC	NOISE CRITERIA
NTS	NOT TO SCALE
P-X	PLUMBING FIXTURE DESIGNATOR
TYP/TYP.	TYPICAL
V	VENT
VTR	VENT THRU ROOF
W	WASTE
W.C.	WATER COLUMN
WCO	WALL CLEAN OUT
WHA	WATER HAMMER ARRESTOR

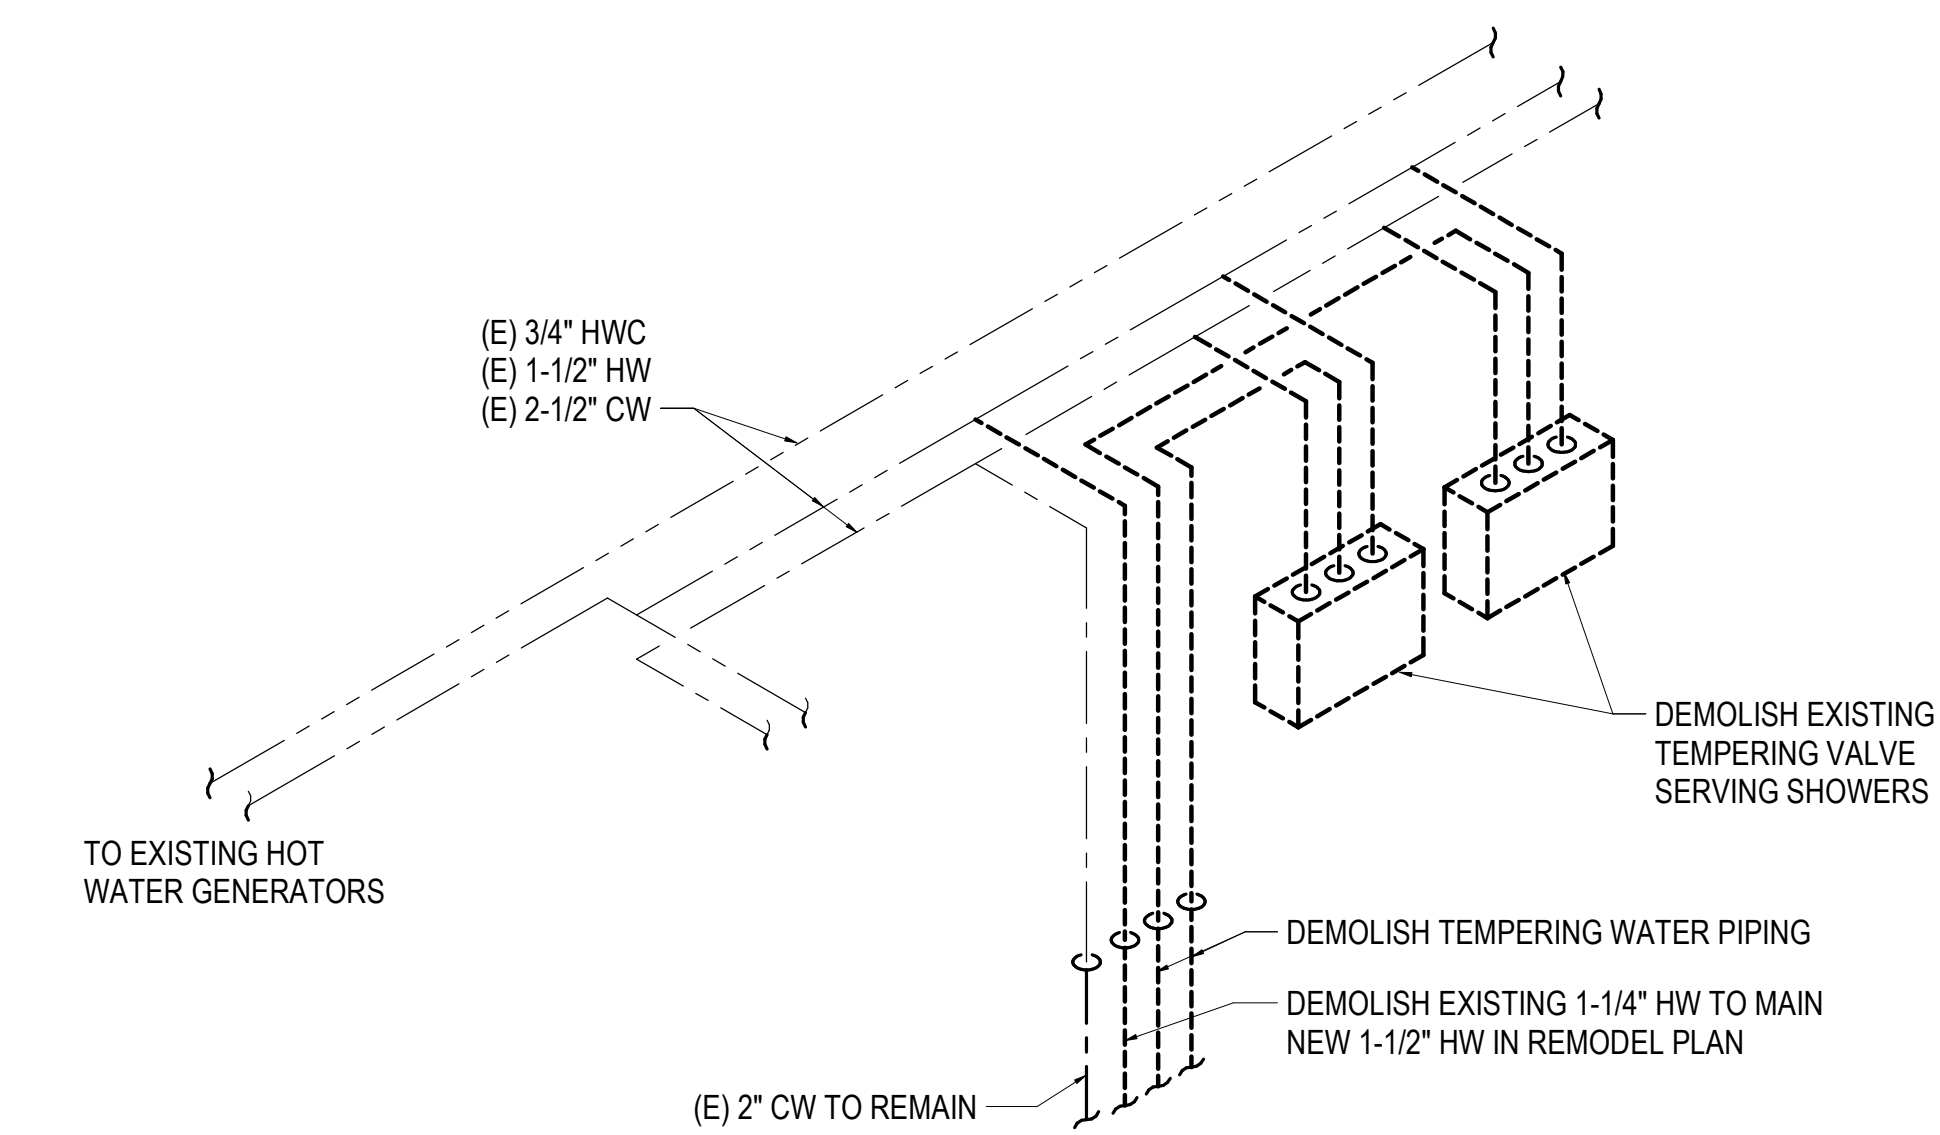

1 TEMPERING VALVE ISOMETRIC - DEMOLITION
1" = 1'-0"

AIR INLET/OUTLET SCHEDULE

SYMBOL	MFGR	MODEL	TYPE	USE	MATERIAL	FINISH	CFM	FACE SIZE (IN)	NC	THROW	REMARKS
A	TITUS	45F	CEILING	E/A	ALUMINUM	PER ARCH	PER PLANS	PER PLANS	<25	--	SURFACE MOUNT.
B	TITUS	CT-PP-O	WALL	S/A	ALUMINUM	PER ARCH	PER PLANS	PER PLANS	<25	1-WAY	FRAME FOR SIDE WALL MOUNTING IN TILE.

PLUMBING FIXTURE SCHEDULE

SYMBOL	FIXTURE	MOUNTING	CW	HW	WASTE	VENT	TRAP	BASIS OF DESIGN	MODEL	FINISH	REMARKS
HB-1	HOSE BIBB	WALL	3/4	3/4	--	--	--	ACORN	8156	BRONZE	FLUSH MOUNT WITH WALL, WITH VACUUM BREAKER AND ACCESS DOOR.
P-1	WATER CLOSET	WALL	1	--	4	2	--	AMERICAN STANDARD	AFWALL	WHITE	PROVIDE WITH WALL CARRIER, ELONGATED SEAT, NO COVER, FLUSH VALVE SLOAN SOLIS MODEL 8111-1.6.
P-1A	WATER CLOSET - ADA	WALL	1	--	4	2	--	AMERICAN STANDARD	AFWALL	WHITE	PROVIDE WITH WALL CARRIER FOR ADA MOUNTING HEIGHT, ELONGATED SEAT, NO COVER, FLUSH VALVE SLOAN SOLIS MODEL 8111-1.6.
P-1B	WATER CLOSET - CHILD HEIGHT AGES 5-8	WALL	1	--	4	2	--	AMERICAN STANDARD	AFWALL	WHITE	PROVIDE WITH WALL CARRIER FOR LOW ROUGH-IN 14" RIM HEIGHT, ELONGATED SEAT, NO COVER, FLUSH VALVE SLOAN SOLIS MODEL 8111-1.6.
P-2	URINAL	WALL	3/4	--	2	1-1/2	--	AMERICAN STANDARD	WASHBROOK	WHITE	PROVIDE WITH WALL CARRIER, FLUSH VALVE SLOAN SOLIS MODEL 8186.
P-2A	URINAL	WALL	3/4	--	2	1-1/2	--	AMERICAN STANDARD	WASHBROOK	WHITE	PROVIDE WITH WALL CARRIER FOR ADA MOUNTING HEIGHT, FLUSH VALVE SLOAN SOLIS MODEL 8186.
P-3	LAVATORY	COUNTER	1/2	1/2	1-1/2	1-1/4	1-1/4	AMERICAN STANDARD	0475	WHITE	DROP IN SINK, MODEL 8554 FAUCET, WATTS LFUSG-B, ASSE 1070 TEMPERING VALVE.
P-4	SHOWER VALVE	WALL	1/2	1/2	2	1-1/2	2	SYMMONS	C-96-1-151-X	CHROME	PRESSURE BALANCE MIXING VALVE, INTEGRAL SERVICE AND CHECK STOPS, ANCHOR PLATE FOR TILE MOUNTING, INSTITUTIONAL 2.5 GPM SPRAY HEAD.
TD-1	LINEAR SHOWER DRAIN	FLOOR	--	--	2	1-1/2	1-1/2	ZURN	ZS880-28-TG	STAINLESS	30" WIDE LINEAR DRAIN. PROVIDE WITH TILE EDGE LEVELING.
TD-2	LINEAR SHOWER DRAIN	FLOOR	--	--	2	1-1/2	1-1/2	ZURN	ZS880-40-TG	STAINLESS	42" WIDE LINEAR DRAIN. PROVIDE WITH TILE EDGE LEVELING.

REVIEWED BY:
PROJECT MGR: **CMR**
DRAWN BY: **CMR**
DATE: **11/15/2017**
REVISIONS:


MCCOOL CARLSON GREEN
ARCHITECTURE • PLANNING • INTERIORS
HISTORIC ANCHORAGE TRAIN DEPOT
421 W. 1ST AVENUE • SUITE 300 • ANCHORAGE, AK 99501
907.563.8474 PHONE • 907.563.4572 FAX • WWW.MCGALASKA.COM

VCS RESTROOM RENOVATION
VOLUME 2 HHES
1009 W Klutina St, Valdez, AK 99686
CITY OF VALDEZ


MECHANICAL LEGENDS

SHEET NO.

M001-2

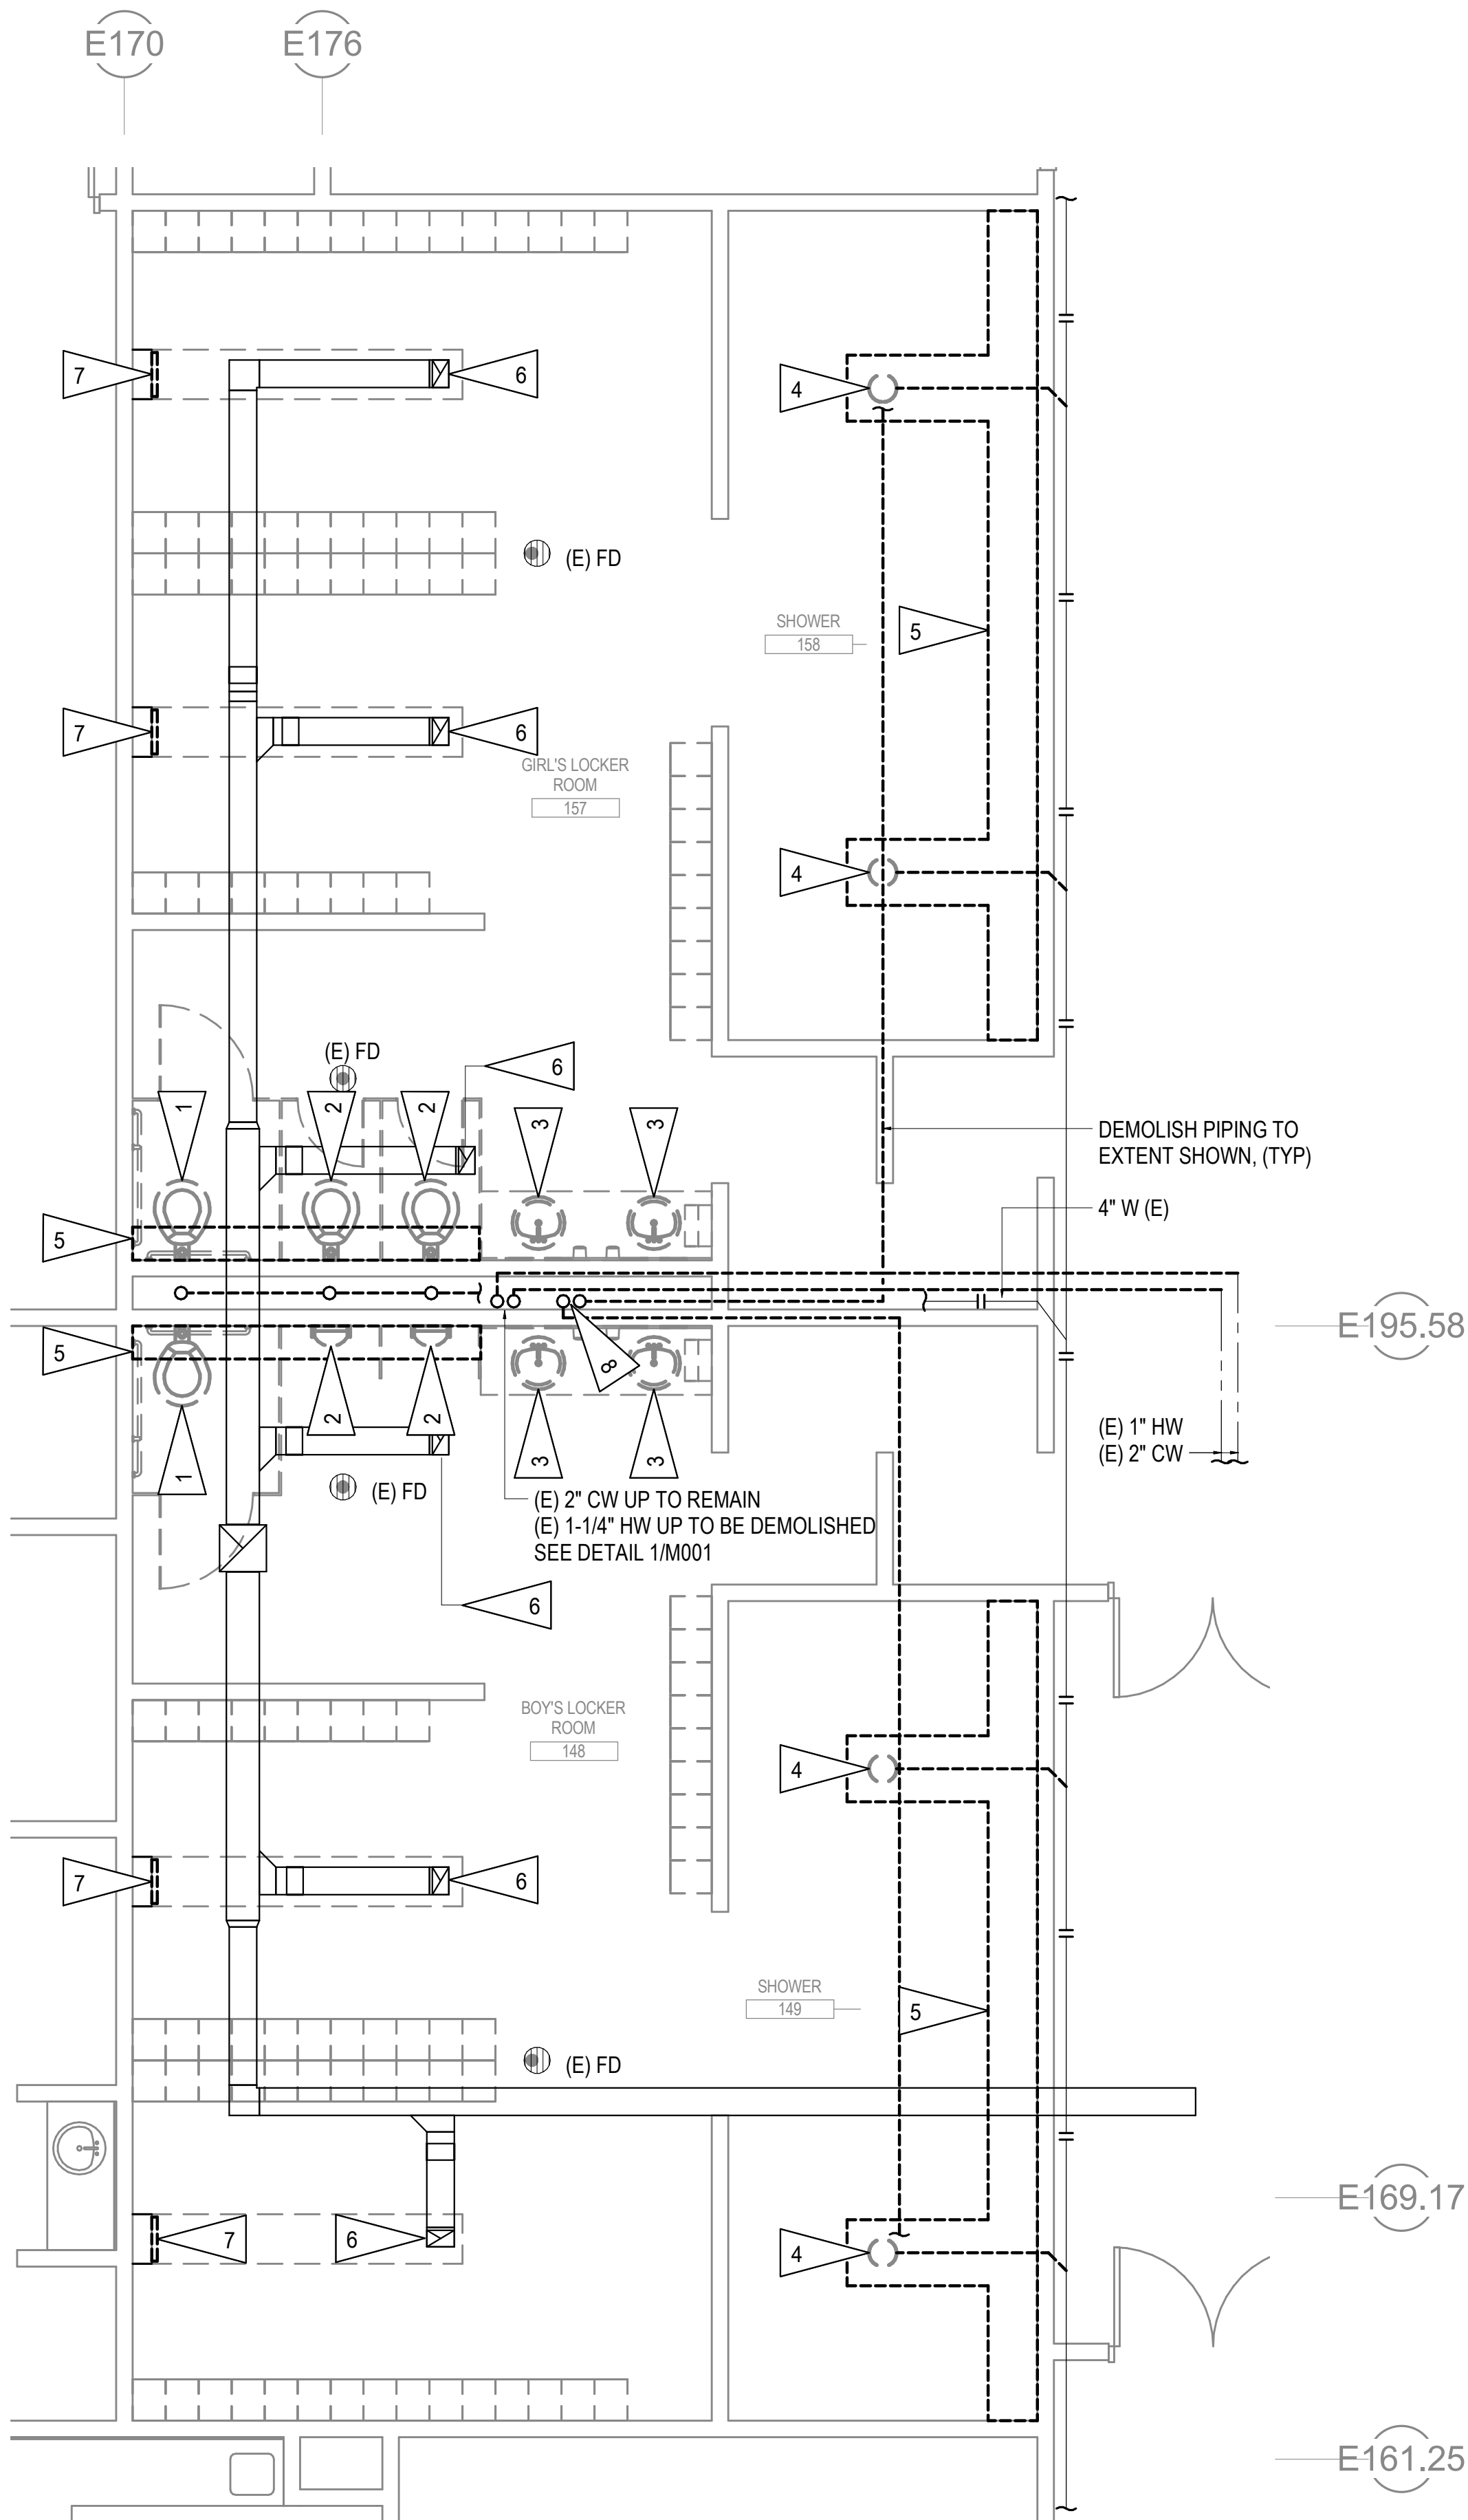

1 DEMOLITION 148 & 157
1/4" = 1'-0"

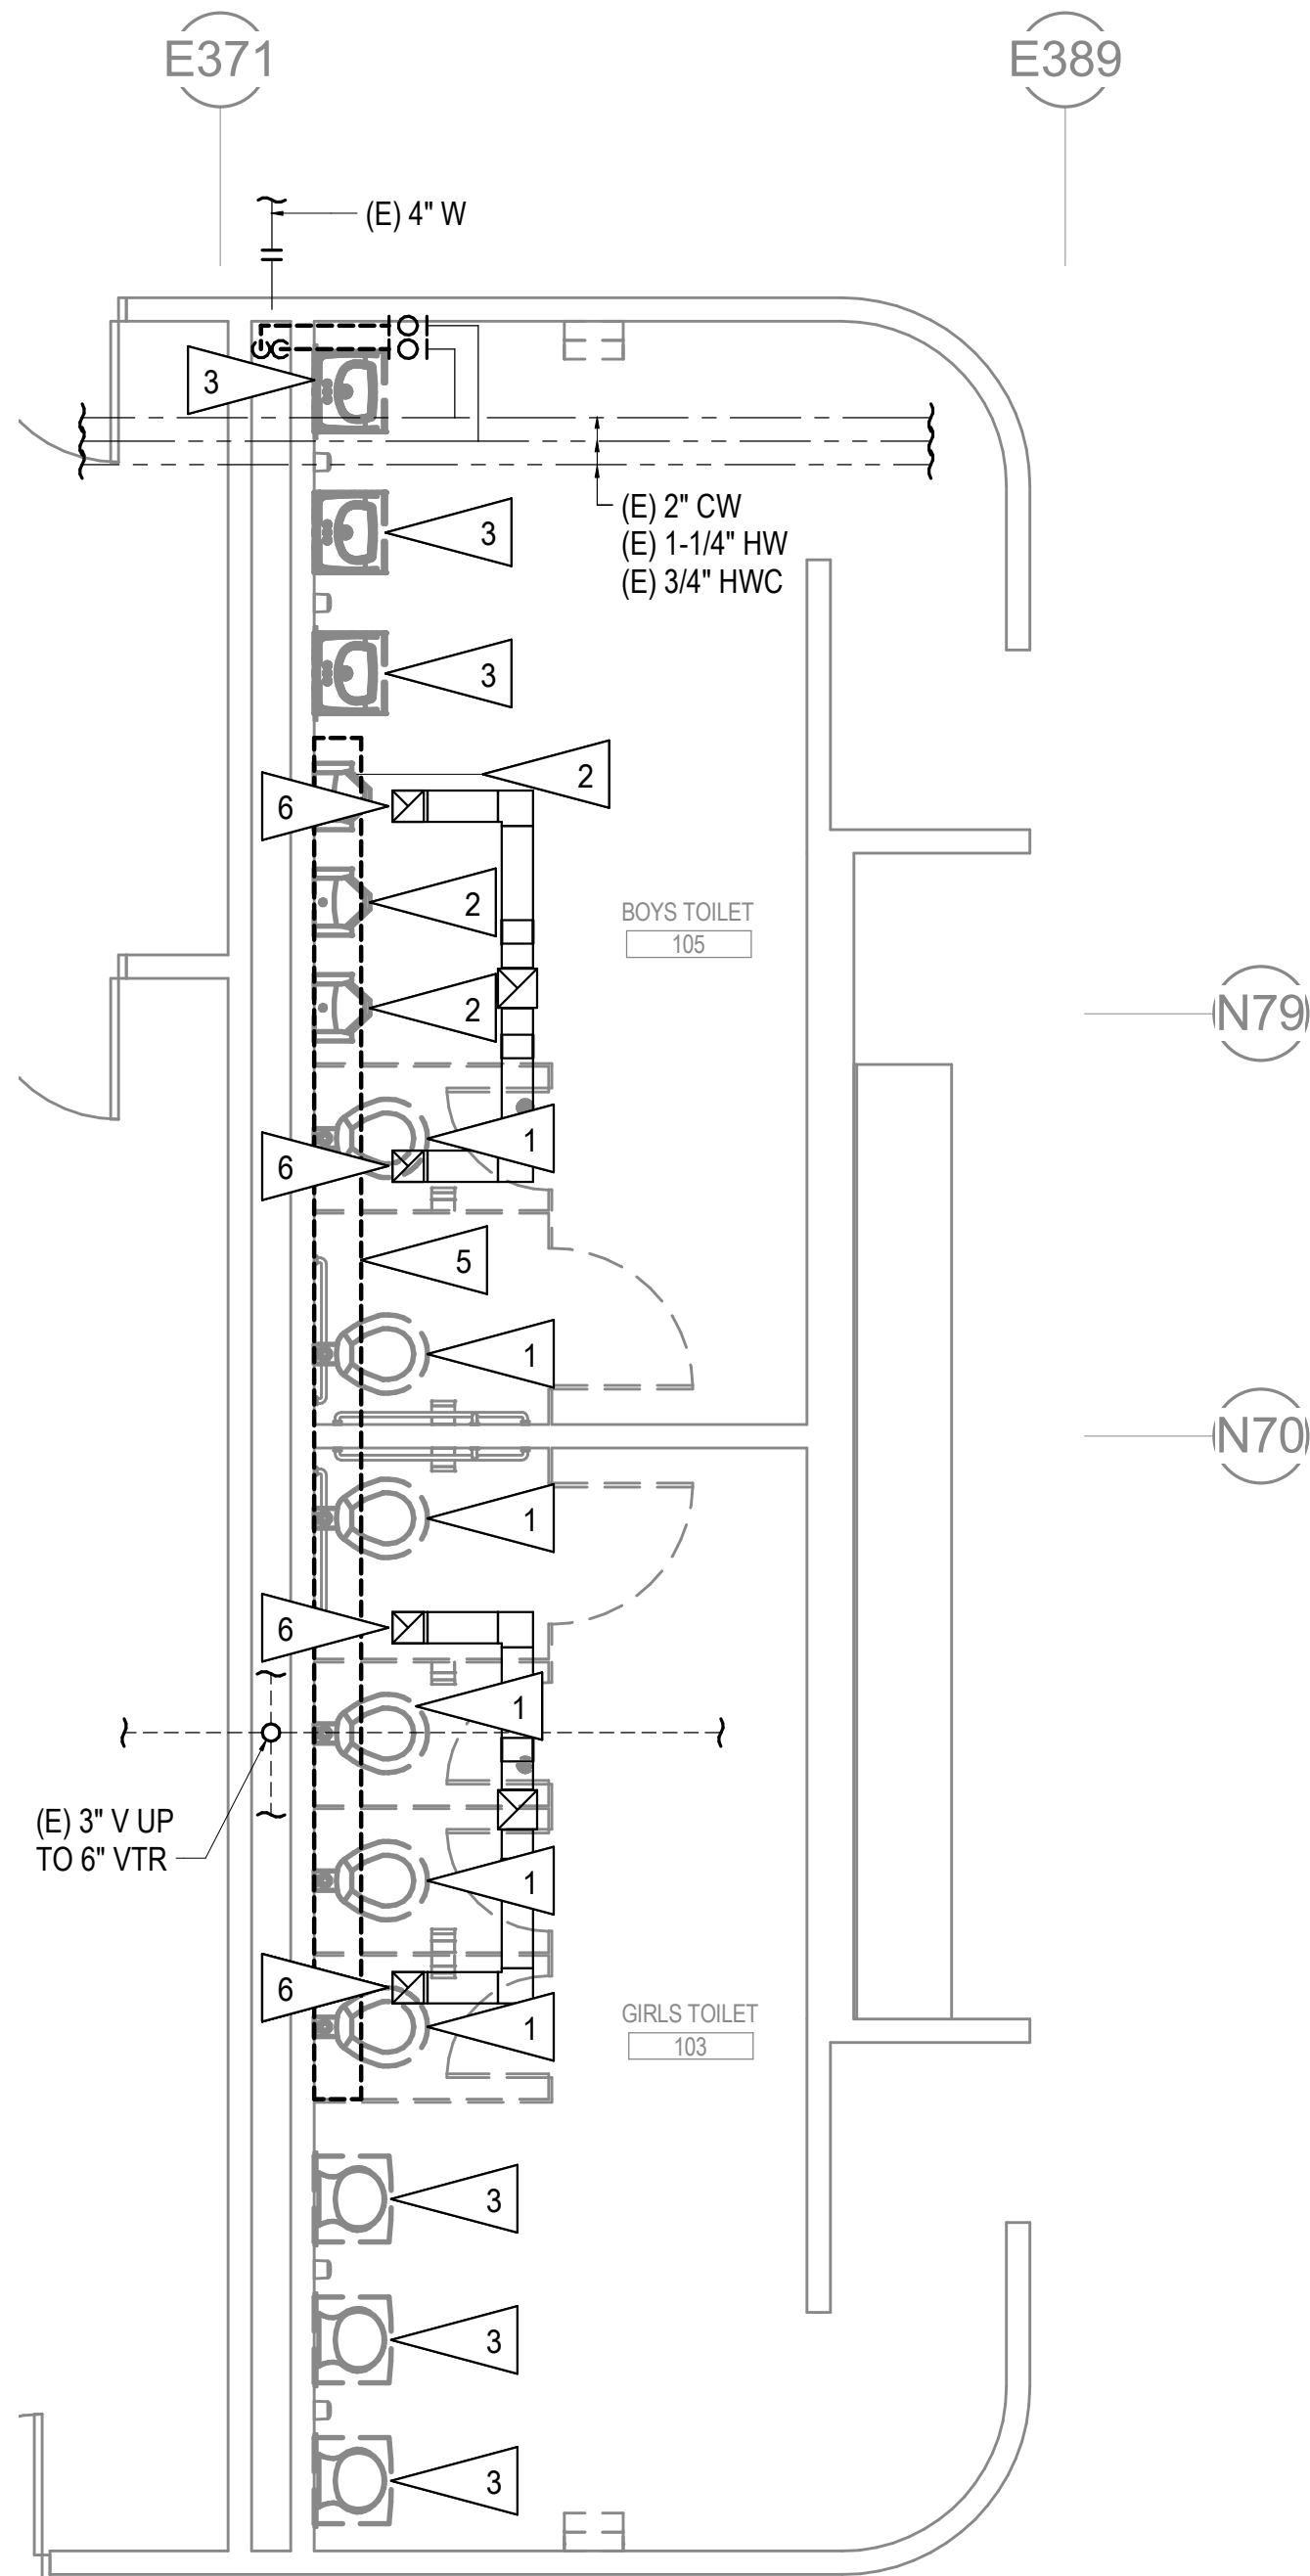


2 DEMOLITION 103 & 105
1/4" = 1'-0"

GENERAL NOTES:


- A. THE INFORMATION SHOWN ON THIS DRAWING IS TAKEN FROM AS-BUILT DRAWINGS AND A NON-DESTRUCTIVE WALK-THROUGH OF THE FACILITY. THERE IS NO WARRANTY OR GUARANTEE AS TO THE ACCURACY OF THE INFORMATION SHOWN HERE-IN. THE CONTRACTOR SHALL FIELD VERIFY ALL ITEMS SCHEDULED FOR DEMOLITION PRIOR TO START OF WORK.
- B. THE OWNER SHALL HAVE FIRST RIGHT OF REFUSAL ON ALL SALVAGEABLE MATERIALS. THE CONTRACTOR SHALL DELIVER SALVAGED MATERIALS TO A LOCATION MUTUALLY AGREED UPON BY CONTRACTOR AND OWNER. THE CONTRACTOR SHALL DISPOSE OF, OFF SITE, ALL UNWANTED MATERIALS.
- C. DASHED OR DOTTED LINES INDICATE ITEMS TO BE REMOVED. SOLID LINES INDICATE EXISTING ITEMS TO REMAIN.
- D. ALL EXISTING HOT & COLD WATER PIPING SHALL BE DEMOLISHED BACK TO ISOLATION VALVES SERVING EACH RESTROOM. DEMOLISH WASTE AND VENT PIPING AS REQUIRED TO INSTALL NEW PLUMBING FIXTURES AS SHOWN ON REMODEL PLANS AND ALL CARRIERS PROVIDED FOR NEW PLUMBING FIXTURES.
- E. DEMOLISH ALL EXISTING SPRINKLER HEADS IN REMODEL AREA.

SHEET NOTES:

- 1 DEMOLISH EXISTING WATER CLOSET AND ASSOCIATED PIPING.
- 2 DEMOLISH EXISTING URINAL AND ASSOCIATED PIPING.
- 3 DEMOLISH EXISTING LAVATORY AND ASSOCIATED PIPING.
- 4 DEMOLISH EXISTING COLUMN SHOWER. DEMOLISH PIPING BACK TO MAIN AS SHOWN.
- 5 APPROXIMATE AREA OF SLAB DEMOLITION. CONTRACTOR TO FIELD VERIFY EXACT LOCATION OF EXISTING WASTE PIPE. DEMOLISH SLAB AS REQUIRED FOR NEW PLUMBING PIPING. SEE REMODEL PLANS. DEMOLISH EXISTING DRAIN AND PIPING AS REQUIRED TO INSTALL NEW PIPING PER REMODEL PLANS.
- 6 DEMOLISH EXISTING EXHAUST AIR GRILLE.
- 7 DEMOLISH EXISTING SUPPLY AIR GRILLES LOCATED IN CHASE NEAR THE BENCH. PROVIDE NEW GRILLE PER REMODEL PLANS.
- 8 DEMOLISH TEMPERED WATER PIPING UP TO MECHANICAL ROOM ABOVE. DEMOLISH EXISTING TEMPERING VALVES IN THE MECHANICAL ROOM. SEE DETAIL - 1/M001

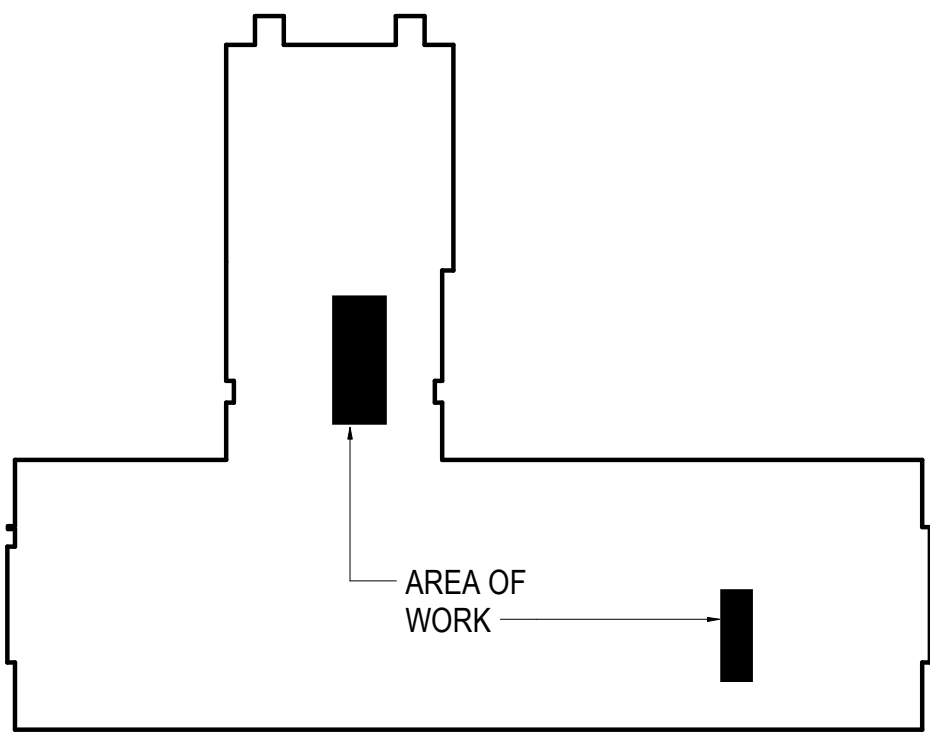

KEY PLAN
N.T.S.

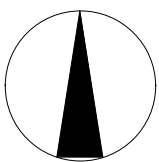


REVIEWED BY:
JOB NO. L7052.00
PROJ. MGR. CMR
DRAWN BY CMR
DATE: 11/15/2017
REVISIONS:
BRIAN P. PEKAR
ME-11249

STATE OF ALASKA
49th
BRIAN P. PEKAR
ME-11249
REGISTERED PROFESSIONAL ENGINEER
12/16/17


MCCOOL CARLSON GREEN
ARCHITECTURE • PLANNING • INTERIORS
HISTORIC ANCHORAGE TRAIN DEPOT
421 W. 1ST AVENUE • SUITE 300 • ANCHORAGE, AK 99501
907.563.6474 PHONE • 907.563.4572 FAX • WWW.MCGALASKA.COM

VCS RESTROOM RENOVATION
VOLUME 2 HHES
1009 W Klutina St, Valdez, AK 99686
CITY OF VALDEZ
DEMOLITION PLANS

SHEET NO.
M101-2

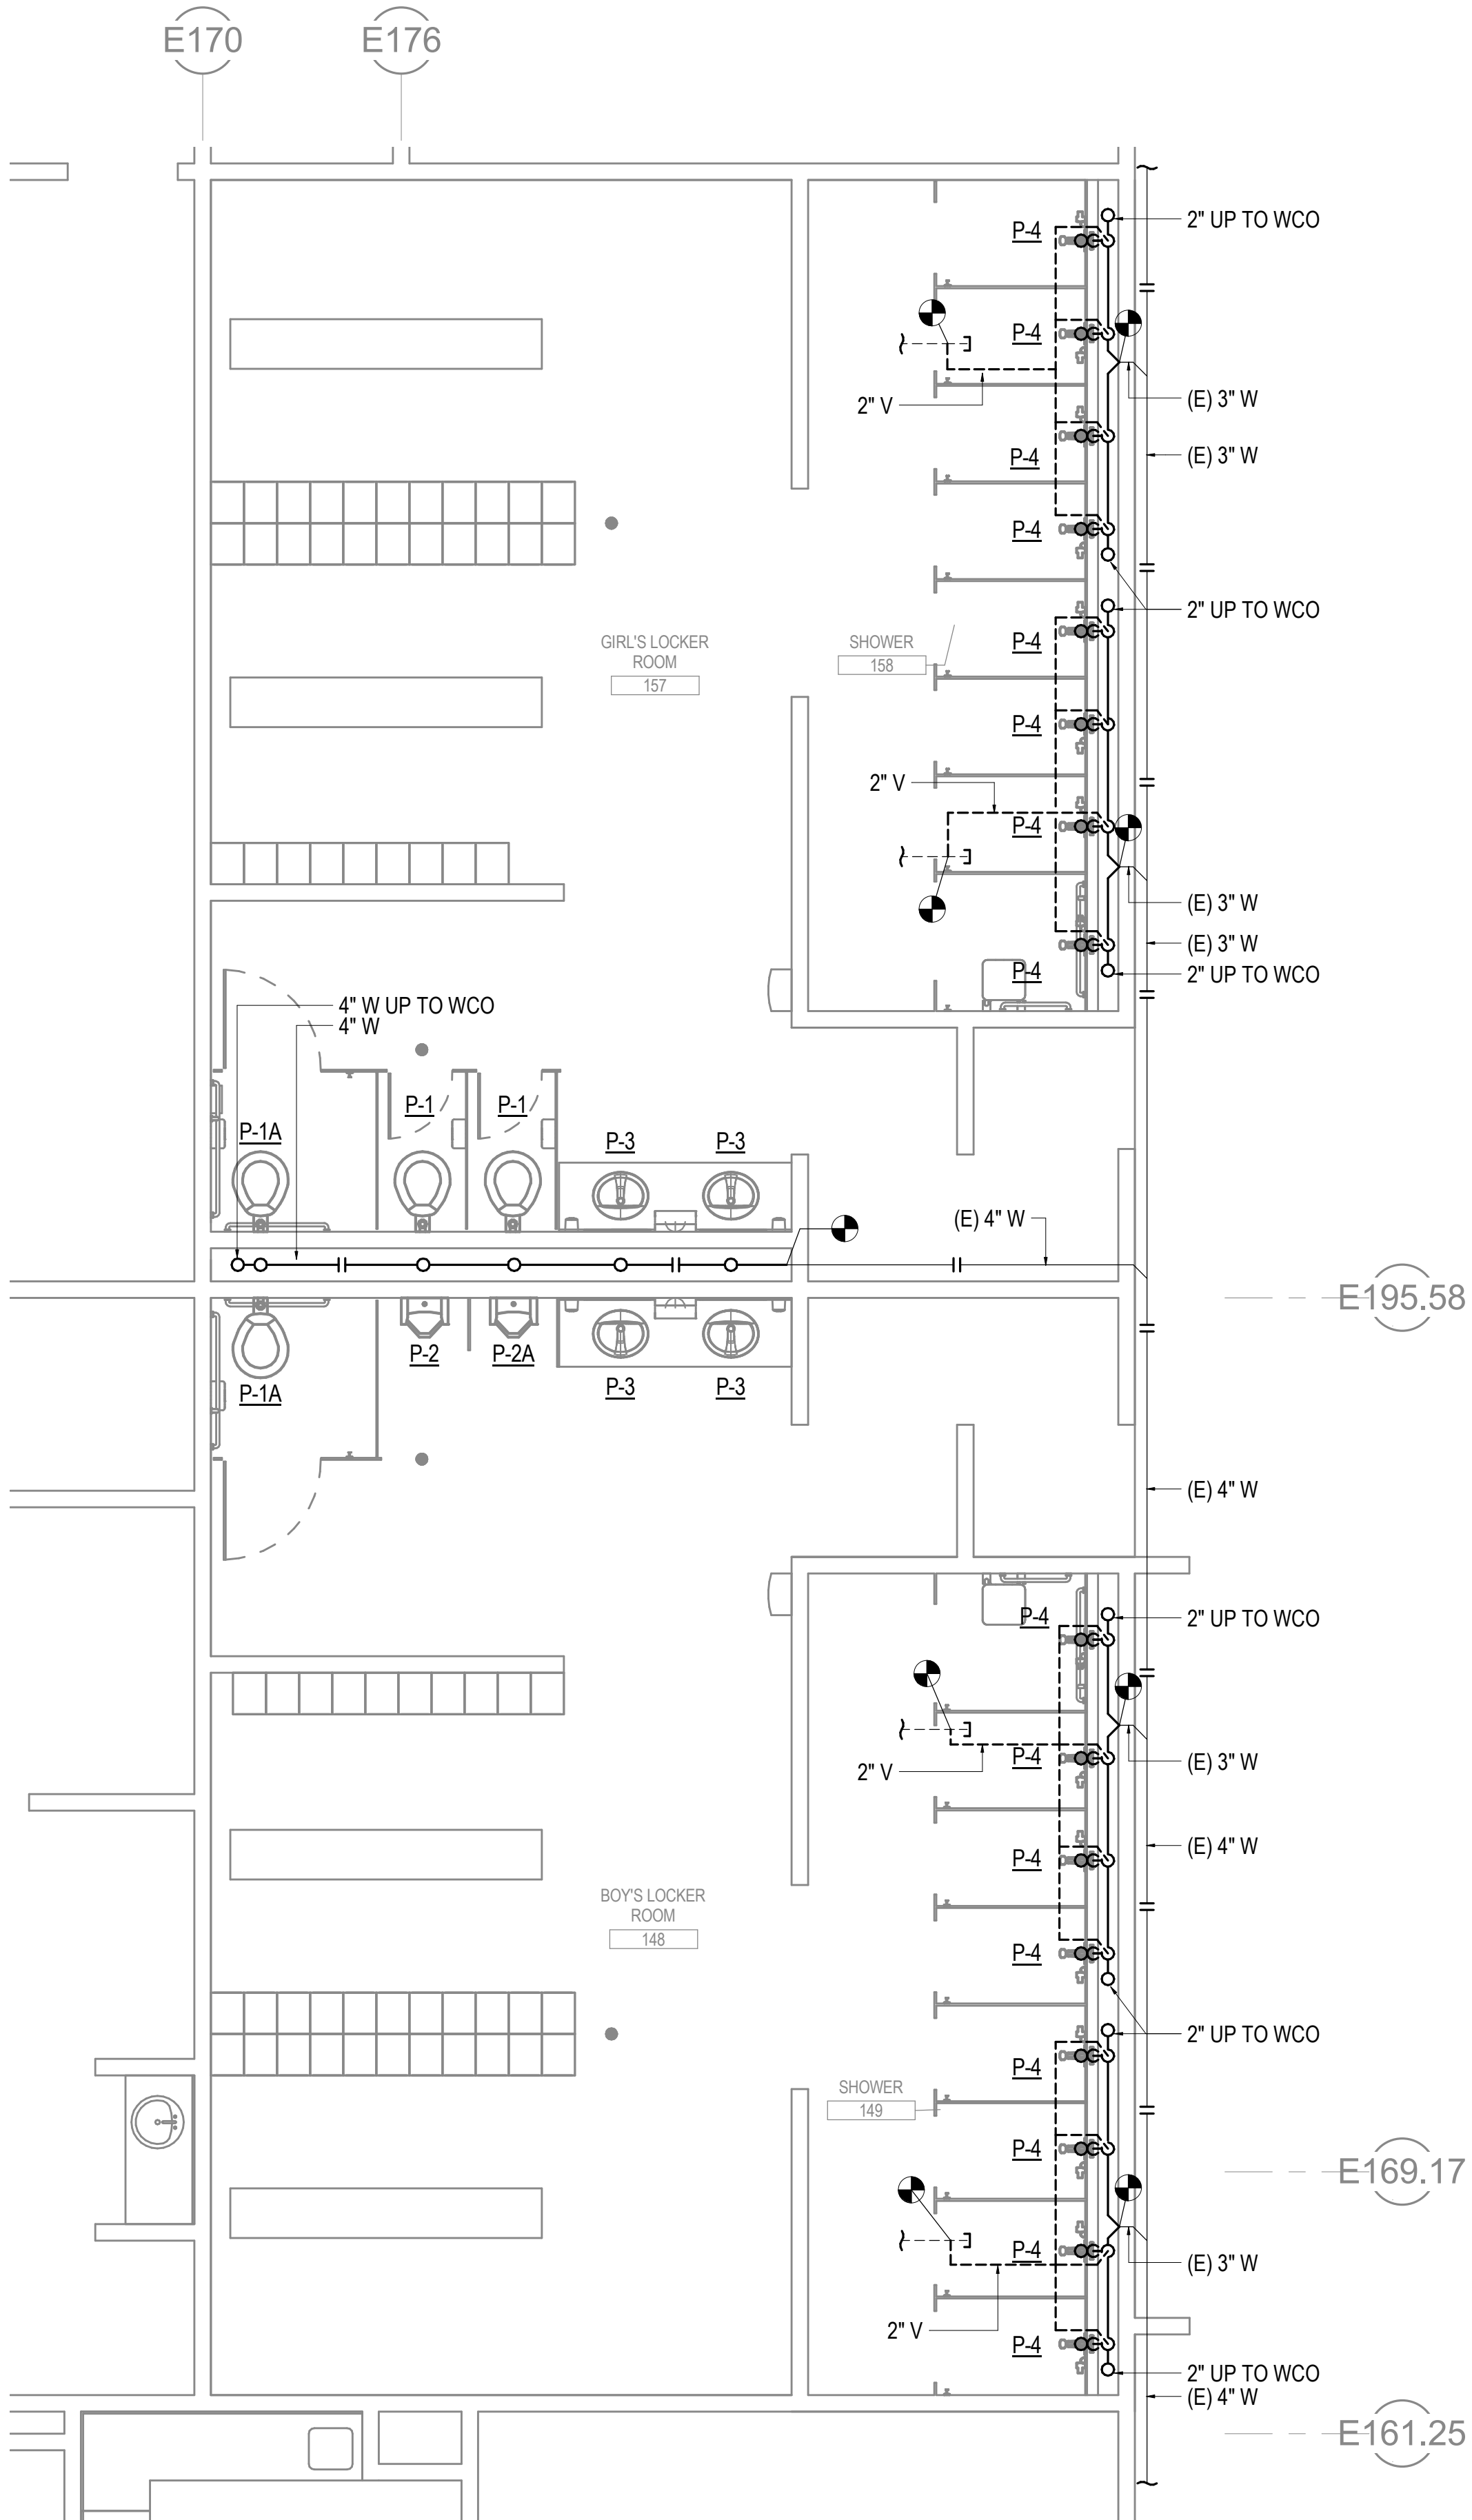

1 UNDERFLOOR PLAN - REMODEL 148 & 157
1/4" = 1'-0"

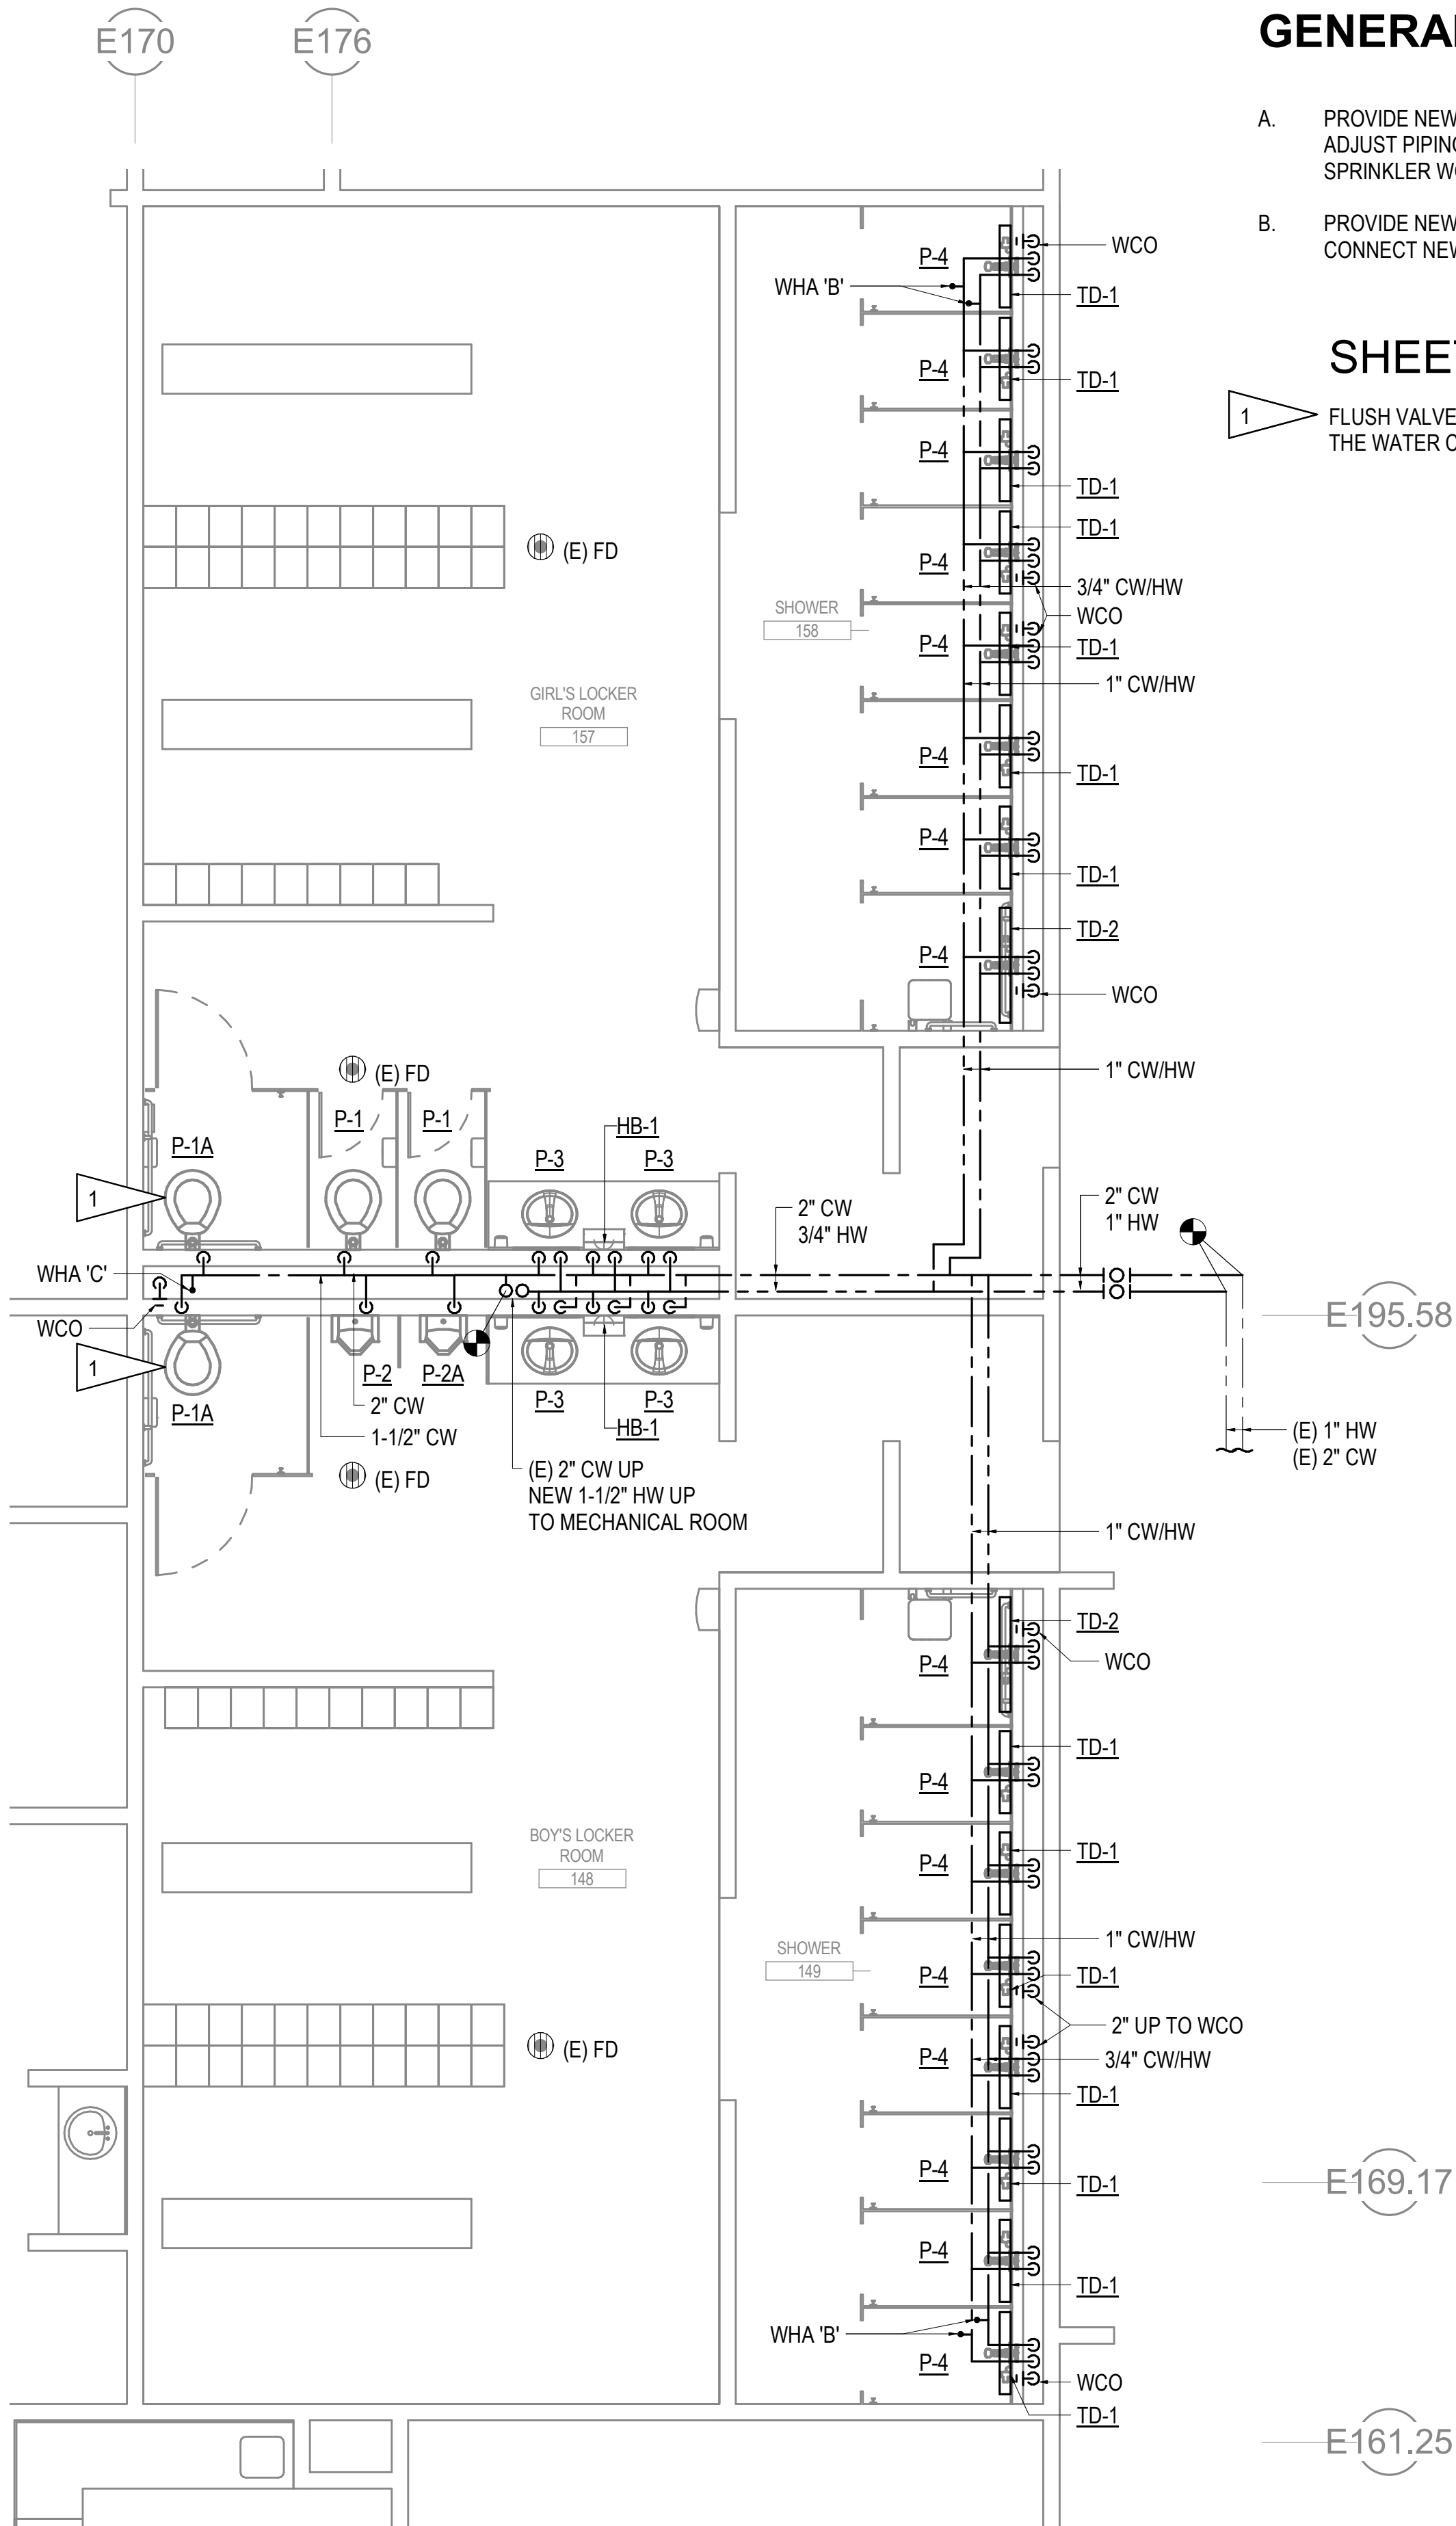

2 PLUMBING PLAN - REMODEL 148 & 157
1/4" = 1'-0"

GENERAL NOTES:


- A. PROVIDE NEW QUICK RESPONSE SPRINKLER HEADS FOR THE REMODEL AREA. ADJUST PIPING DROPS AS REQUIRED TO INSTALL HEADS IN NEW CEILINGS. ALL SPRINKLER WORK TO BE PERFORMED IN ACCORDANCE WITH NFPA 13.
- B. PROVIDE NEW WALL CARRIERS, WASTE AND VENT PIPING FOR ALL FIXTURES. CONNECT NEW PIPING TO EXISTING PIPING.

SHEET NOTE:

1 FLUSH VALVE OPERATOR TO BE LOCATED ON WIDE SIDE OF THE WATER CLOSET.

WHA SCHEDULE

SYMBOL	SIZE	FIXTURE UNITS
WHA-A	1/2"	1-11
WHA-B	3/4"	12-32
WHA-C	1"	33-60
WHA-D	1-1/4"	61-113
WHA-E	1-1/2"	114-154
WHA-F	2"	155-330

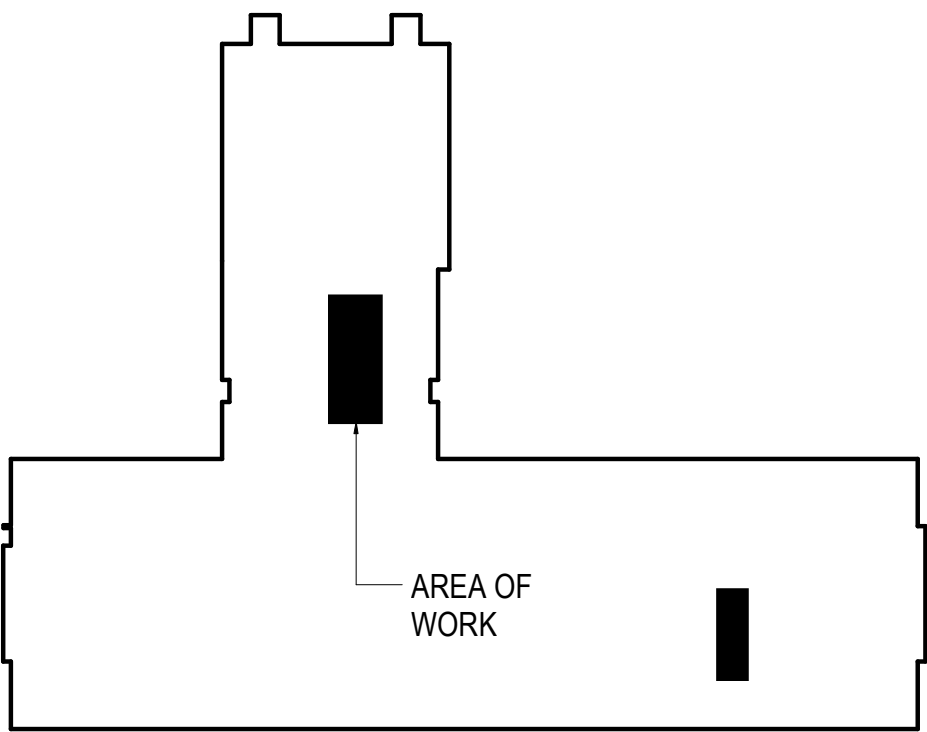

KEY PLAN

N.T.S.

RSA Engineering, Inc.
MECHANICAL AND ELECTRICAL CONSULTING ENGINEERS
670 West Fireweed Lane, Suite 200 - Anchorage, AK 99503 - (907) 276-0821
191 East Swanson Ave., Suite 101 - Wasilla, AK 99654 - (907) 357-1521
Corporate No.: AECC542

REVIEWED BY:
PROJECT MGR: CMR
DRAWN BY: CMR
DATE: 11/15/2017
REVISIONS:

MCCOOL CARLSON GREEN
ARCHITECTURE • PLANNING • INTERIORS
HISTORIC ANCHORAGE TRAIN DEPOT
421 W. 1ST AVENUE • SUITE 300 • ANCHORAGE, AK 99501
907.563.6474 PHONE • 907.563.4572 FAX • WWW.MCGALASKA.COM

VCS RESTROOM RENOVATION
VOLUME 2 HHES
1009 W Klutina St, Valdez, AK 99686
CITY OF VALDEZ
PLUMBING PLAN - 148 & 157


SHEET NO.
M201-2

GENERAL NOTES:


- A. PROVIDE NEW QUICK RESPONSE SPRINKLER HEADS FOR THE REMODEL AREA. ADJUST PIPING DROPS AS REQUIRED TO INSTALL HEADS IN NEW CEILINGS. ALL SPRINKLER WORK TO BE PERFORMED IN ACCORDANCE WITH NFPA 13.
- B. PROVIDE NEW WALL CARRIERS, WASTE AND VENT PIPING FOR ALL FIXTURES. CONNECT NEW PIPING TO EXISTING PIPING.

SHEET NOTE:


1 FLUSH VALVE OPERATOR TO BE LOCATED ON WIDE SIDE OF THE WATER CLOSET.

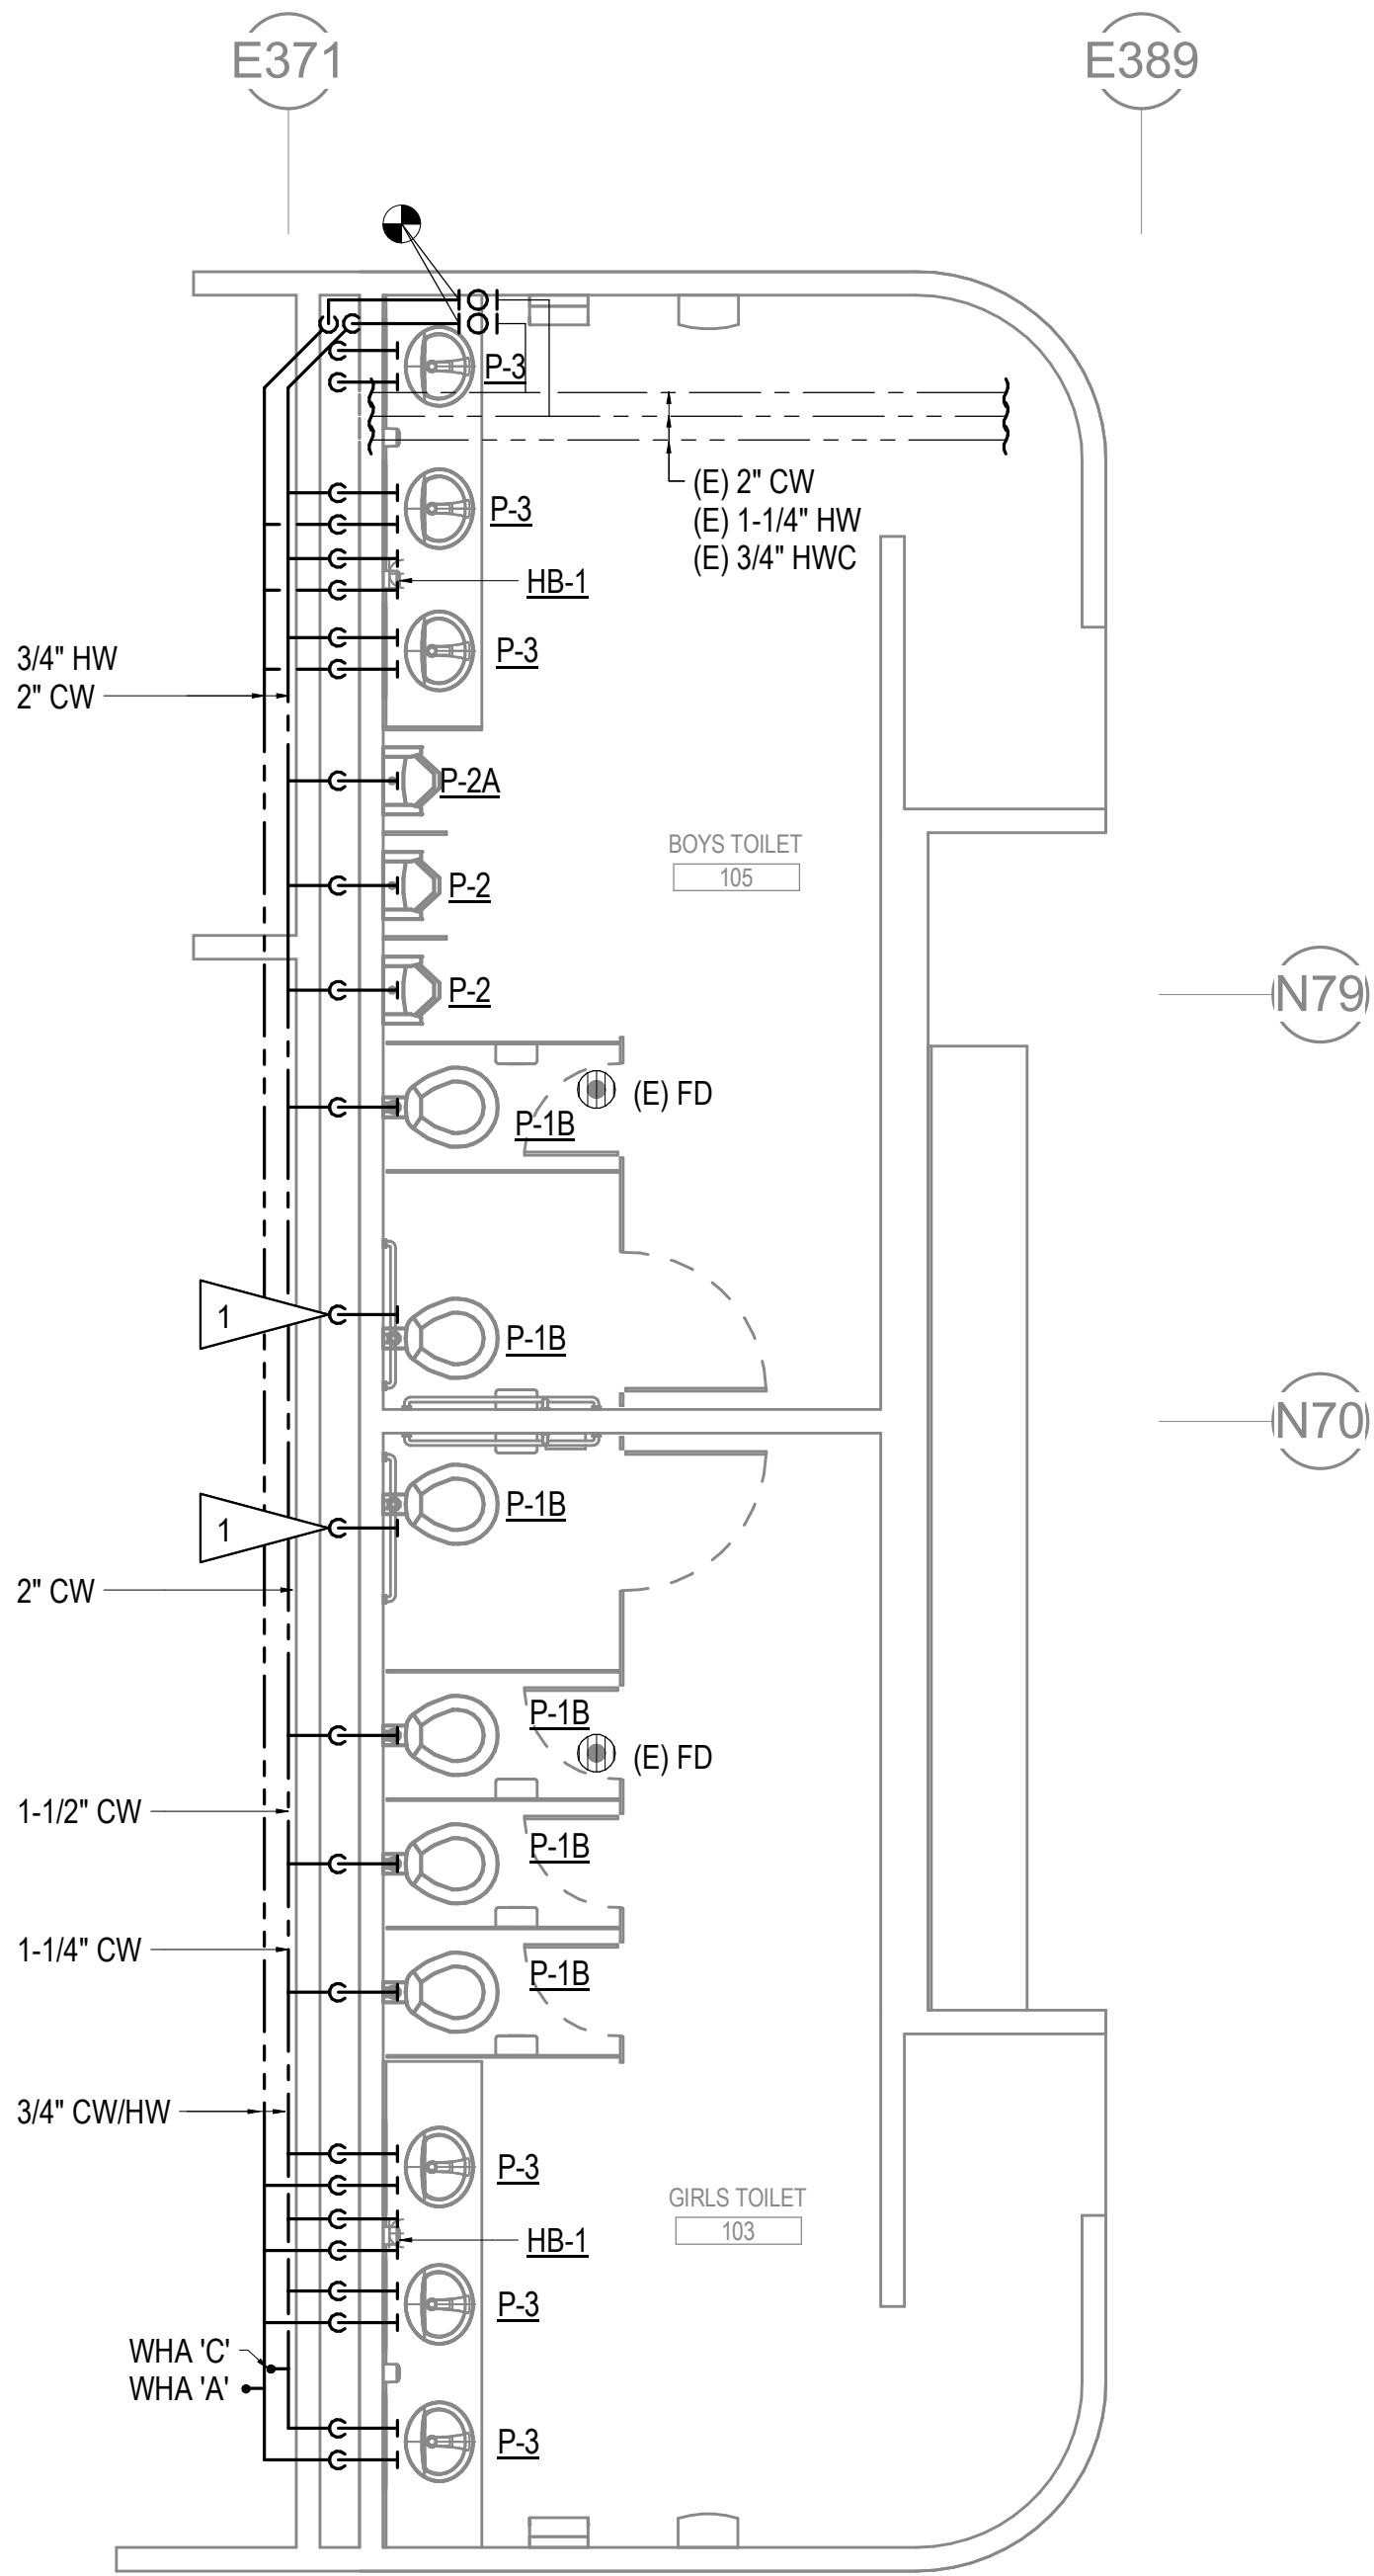

WHA SCHEDULE		
SYMBOL	SIZE	FIXTURE UNITS
WHA-A	1/2"	1-11
WHA-B	3/4"	12-32
WHA-C	1"	33-60
WHA-D	1-1/4"	61-113
WHA-E	1-1/2"	114-154
WHA-F	2"	155-330

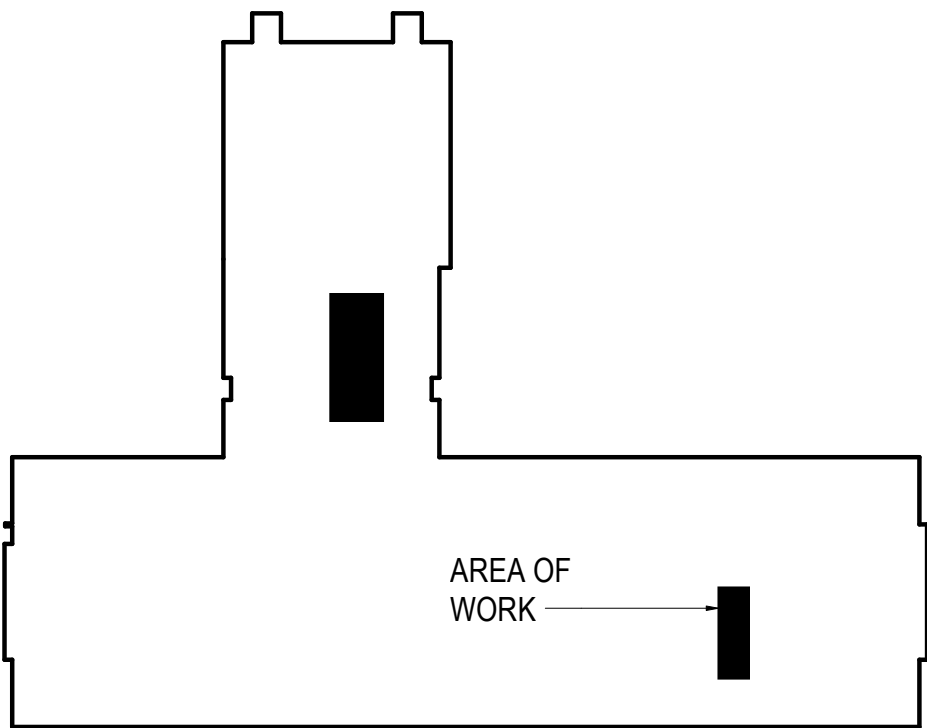

KEY PLAN
N.T.S.

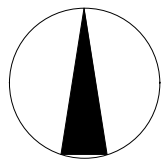

1 PLUMBING PLAN - REMODEL 103 & 105
1/4" = 1'-0"


REVIEWED BY:
PROJECT MGR: CMR
DRAWN BY: CMR
DATE: 11/15/2017
REVISIONS:

STATE OF ALASKA
49th
BRIAN P. PEKAR
ME-11249
12/6/17
REGISTERED PROFESSIONAL ENGINEER


MCCOOL CARLSON GREEN
ARCHITECTURE • PLANNING • INTERIORS
HISTORIC ANCHORAGE TRAIN DEPOT
421 W. 1ST AVENUE • SUITE 300 • ANCHORAGE, AK 99501
907.563.6474 PHONE • 907.563.4572 FAX • WWW.MCGALASKA.COM

VCS RESTROOM RENOVATION
VOLUME 2 HHES
1009 W Klutina St, Valdez, AK 99686
CITY OF VALDEZ
PLUMBING PLAN - 103 & 105


SHEET NO.
M202-2

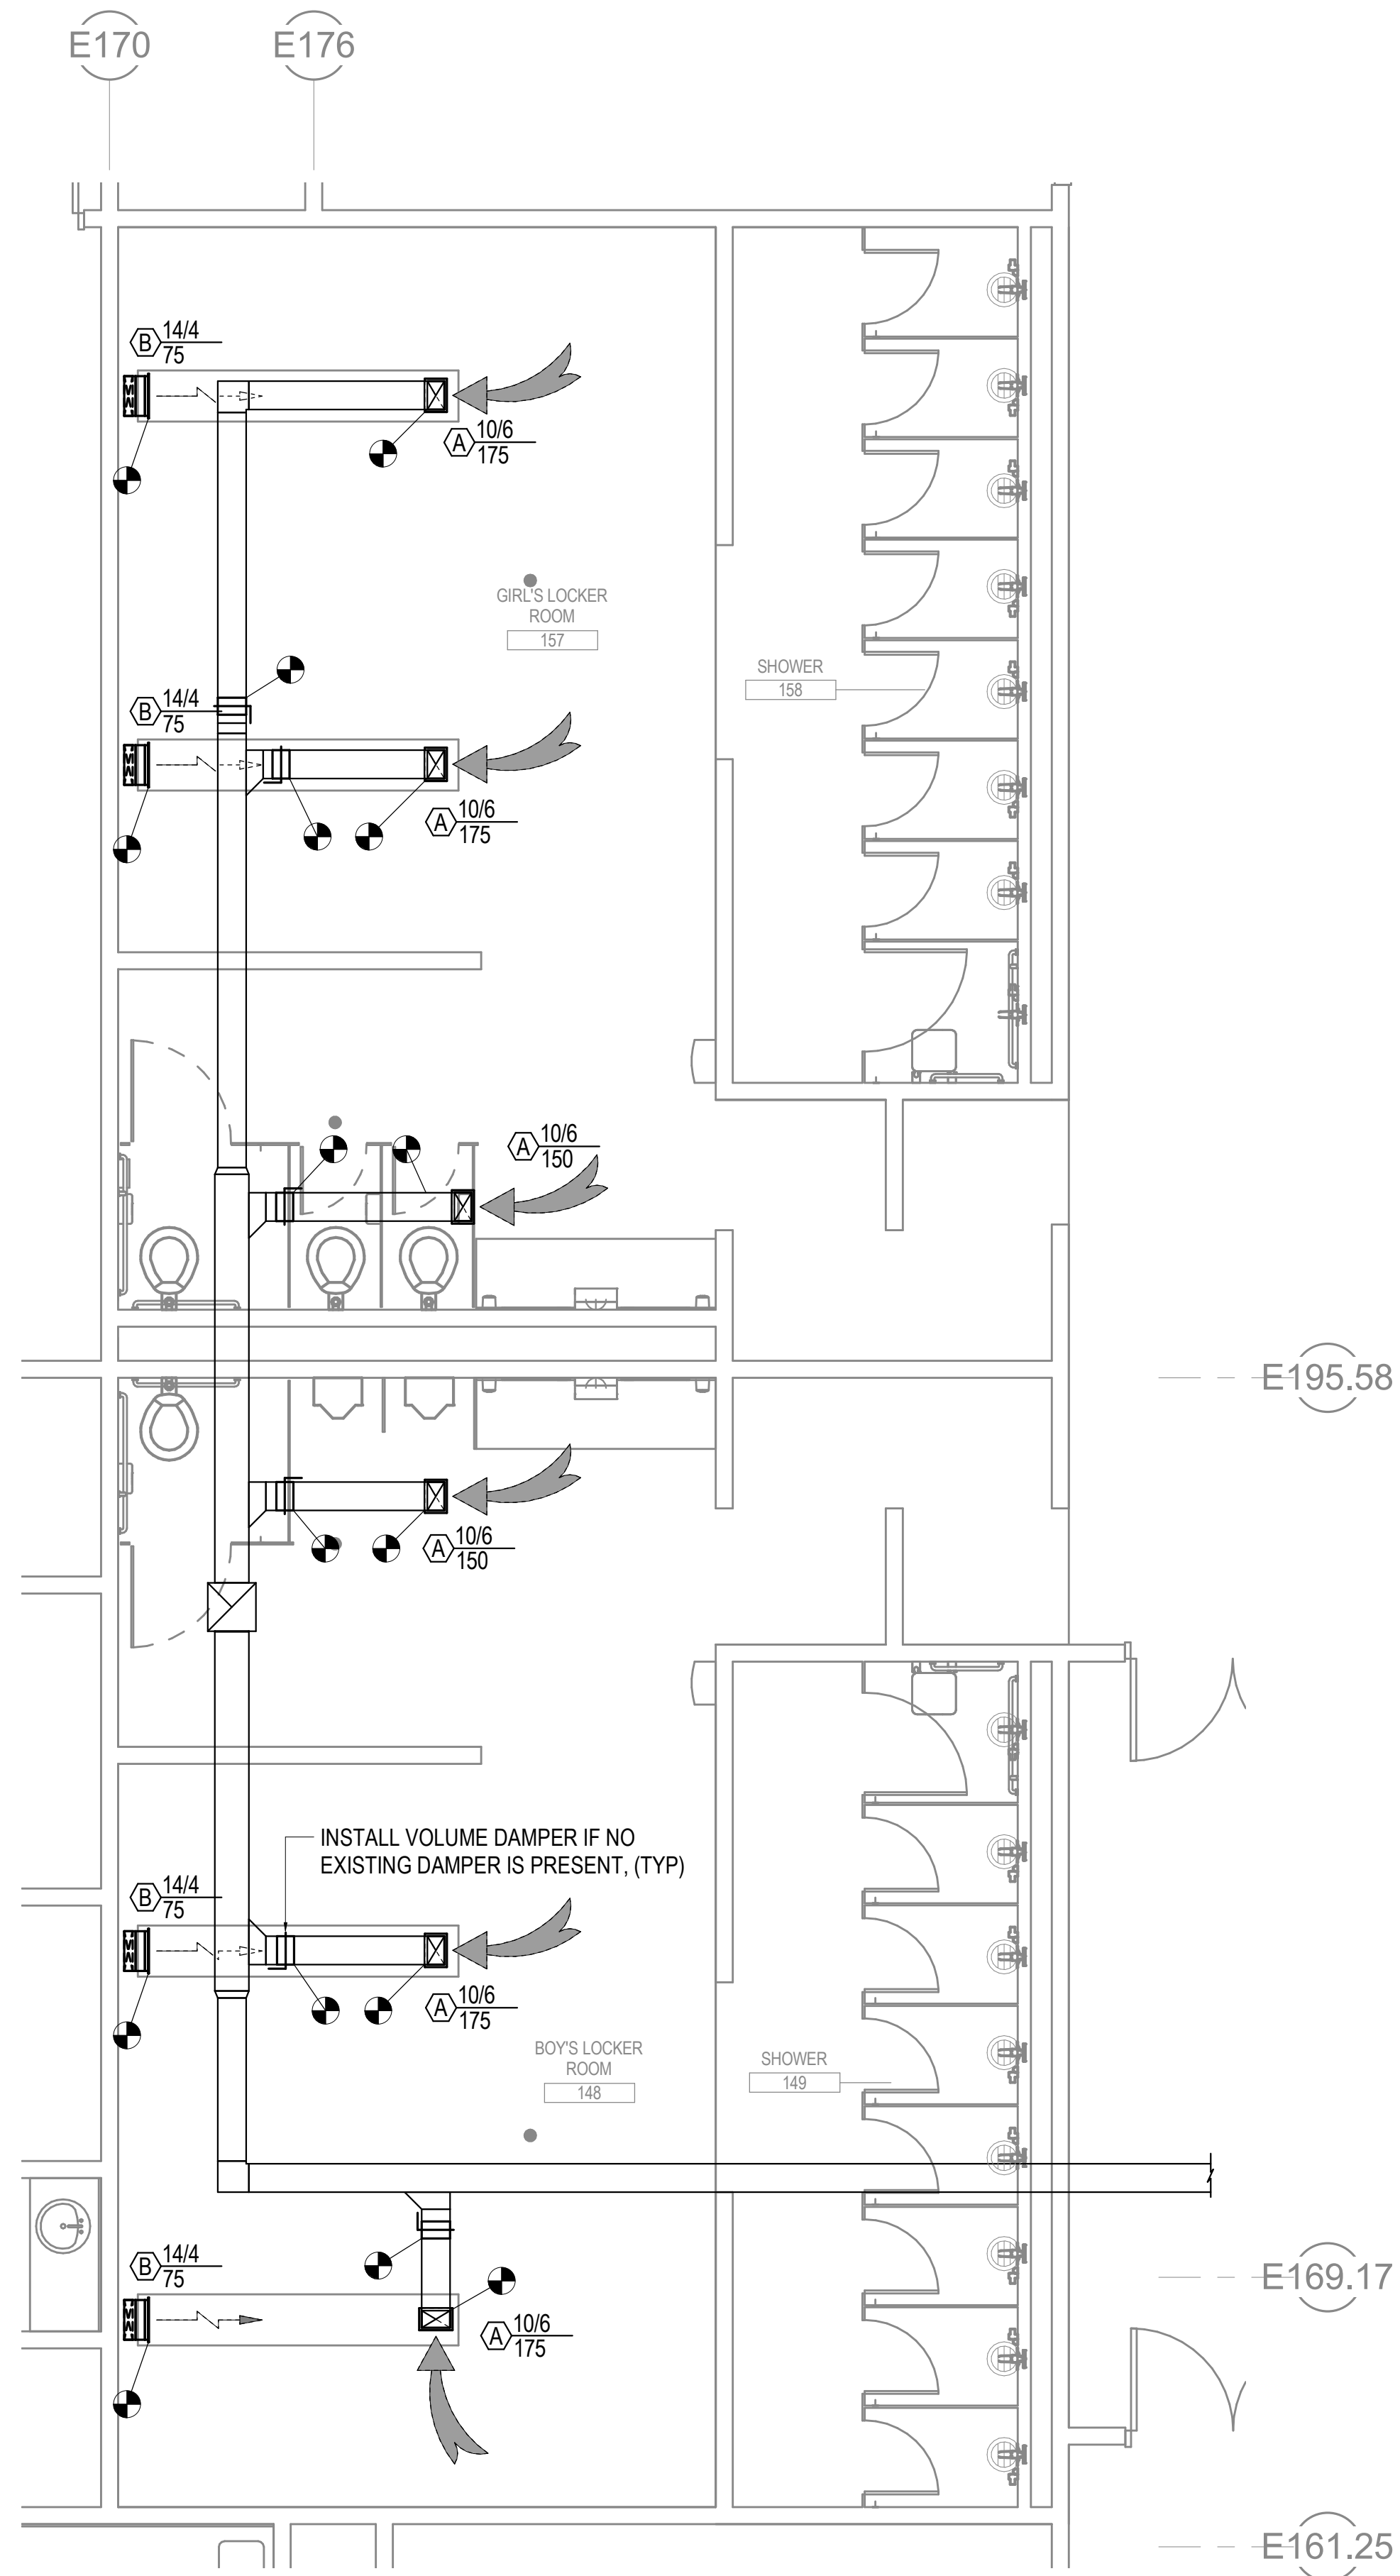

1 VENTILATION PLAN - REMODEL 148 & 157
1/4" = 1'-0"

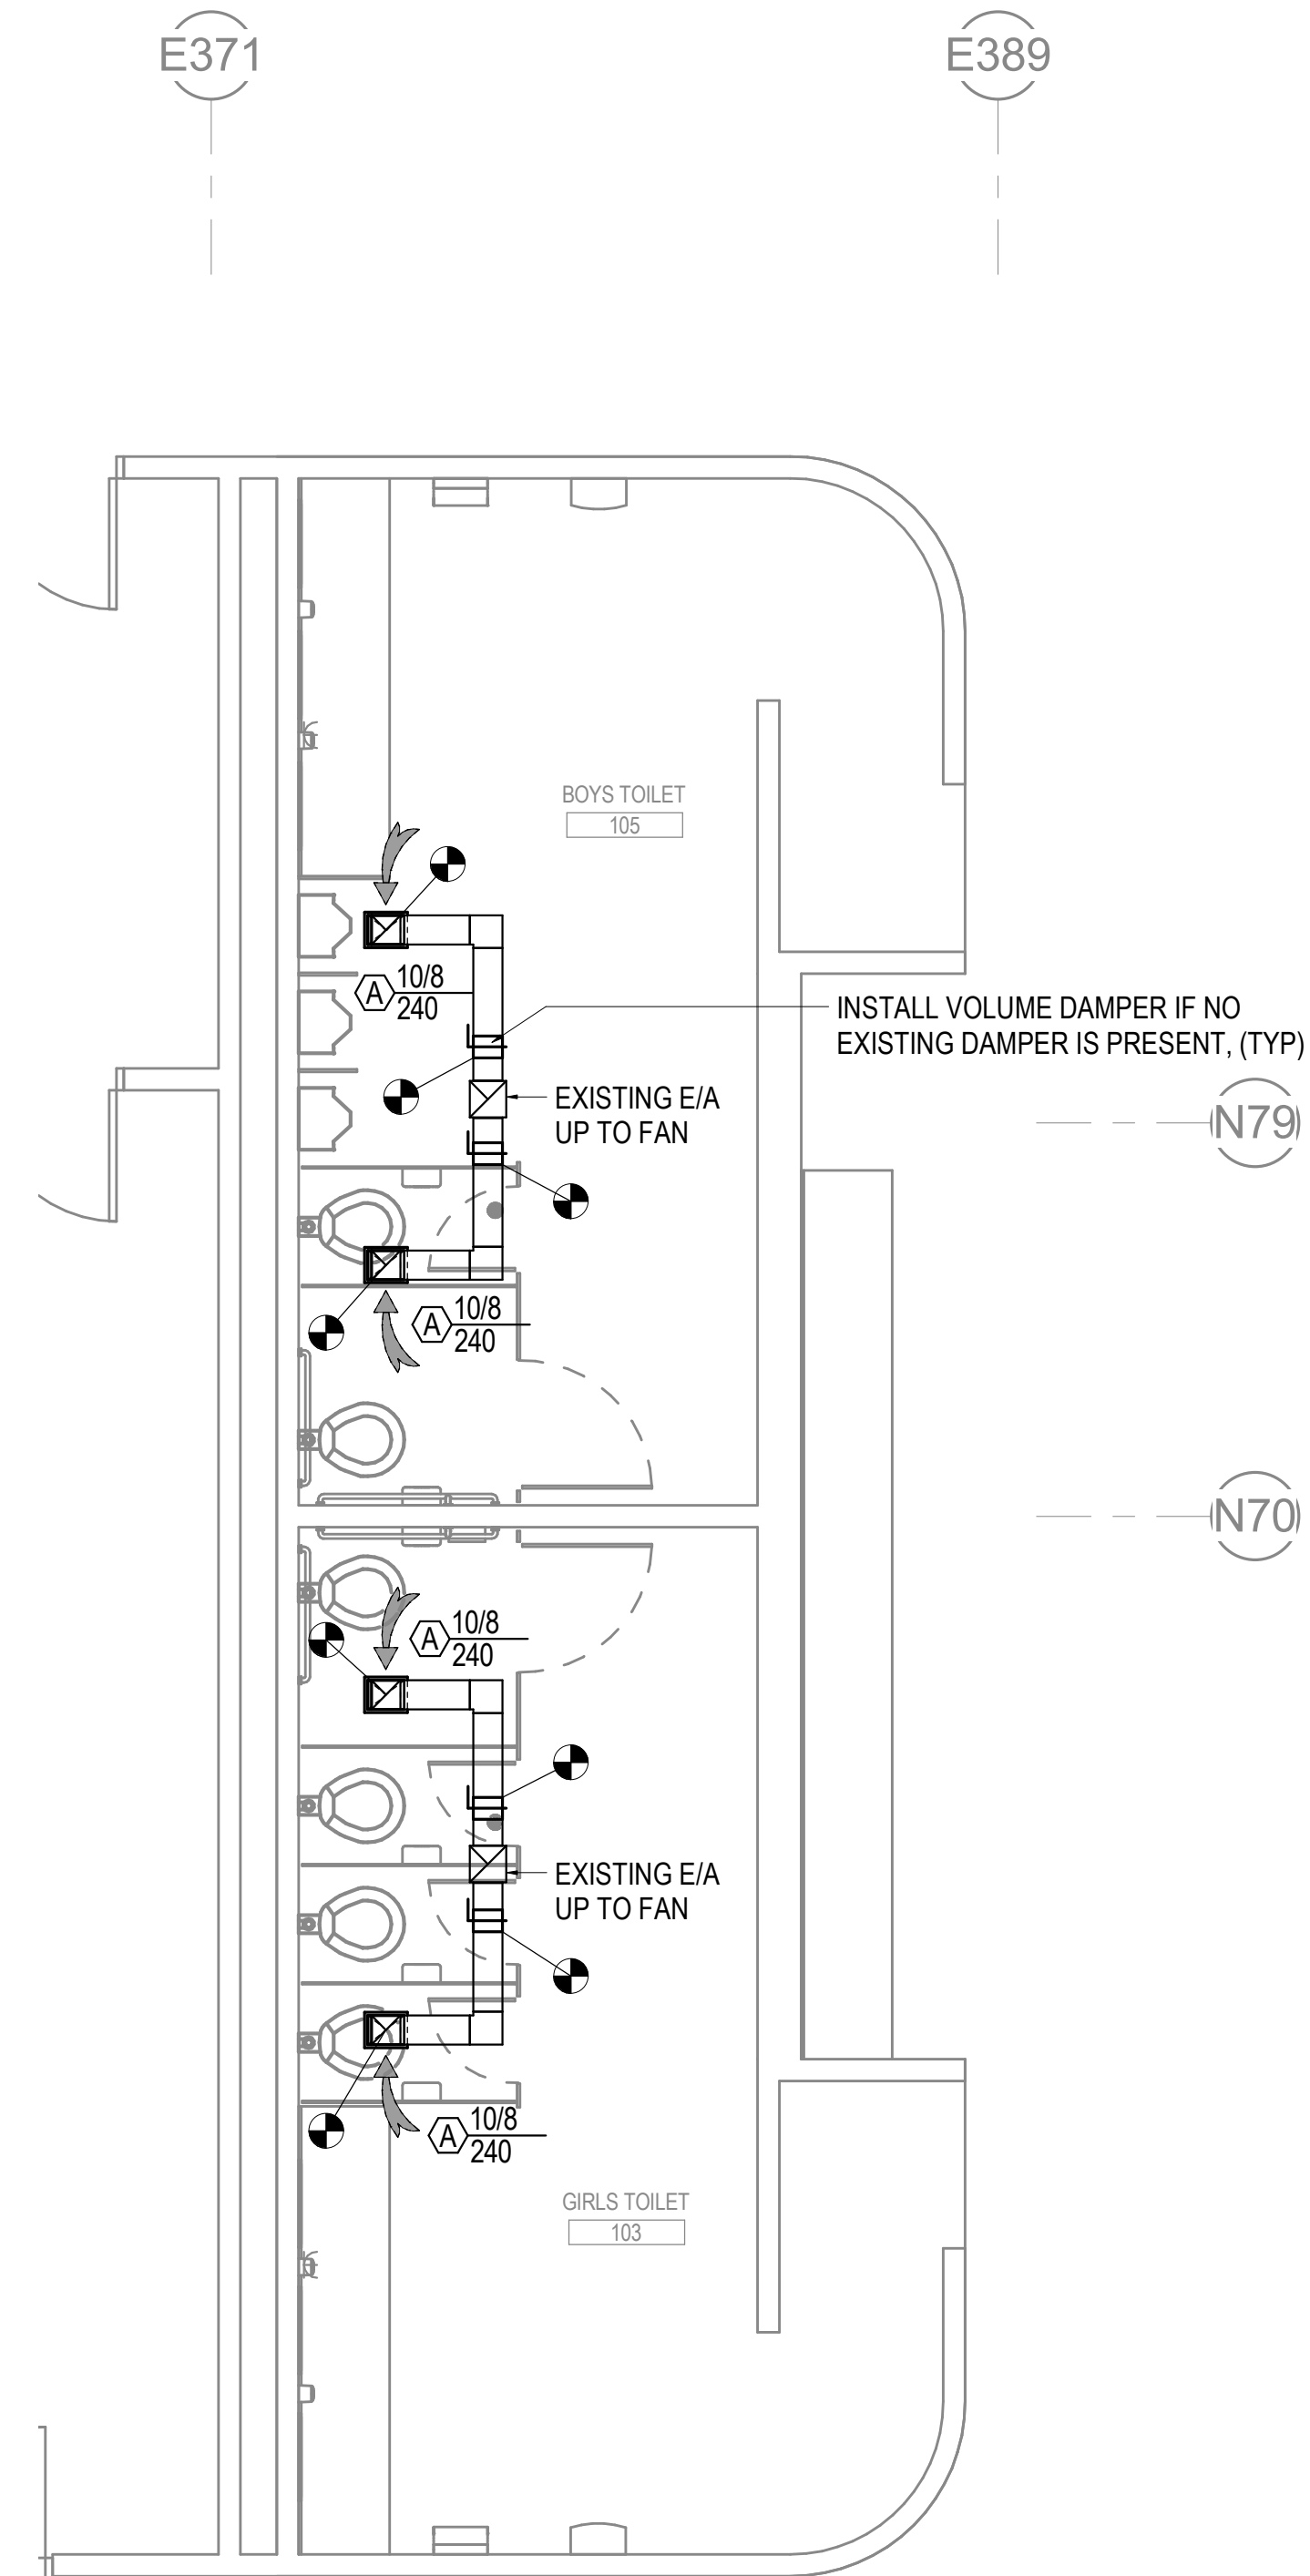


2 VENTILATION PLAN - REMODEL 103 & 105
1/4" = 1'-0"

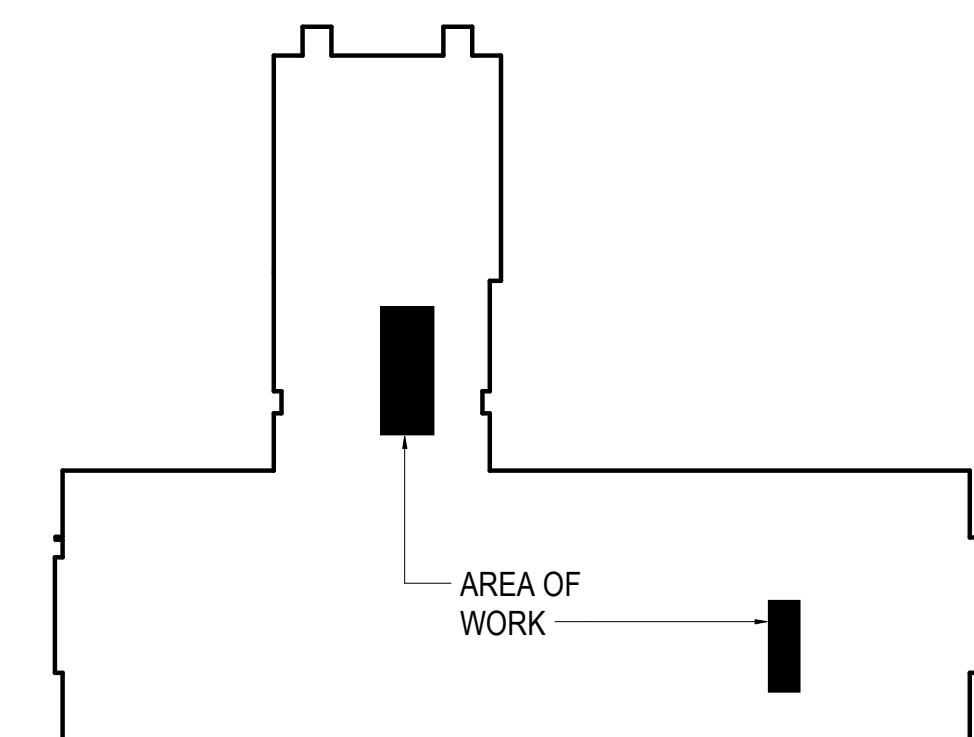

KEY PLAN
N.T.S.

RSA Engineering, Inc.
MECHANICAL AND ELECTRICAL CONSULTING ENGINEERS
670 West Fireweed Lane, Suite 200 - Anchorage, AK 99503 - (907) 276-0821
191 East Swanson Ave., Suite 101 - Wasilla, AK 99654 - (907) 357-1521
Corporate No.: AECC542

SHEET NO. M301-2	VCS RESTROOM RENOVATION VOLUME 2 HHES 1009 W Klutina St, Valdez, AK 99686 CITY OF VALDEZ VENTILATION PLANS			JOB NO. L7052.00 PROJ. MGR CMR DRAWN BY CMR DATE: 11/15/2017 REVISIONS:	REVIEWED BY: Brian P. Pekar
	MCCOOL CARLSON GREEN ARCHITECTURE • PLANNING • INTERIORS HISTORIC ANCHORAGE TRAIN DEPOT 421 W. 1ST AVENUE • SUITE 300 • ANCHORAGE, AK 99501 907.563.8474 PHONE • 907.563.4572 FAX • WWW.MCGALASKA.COM				

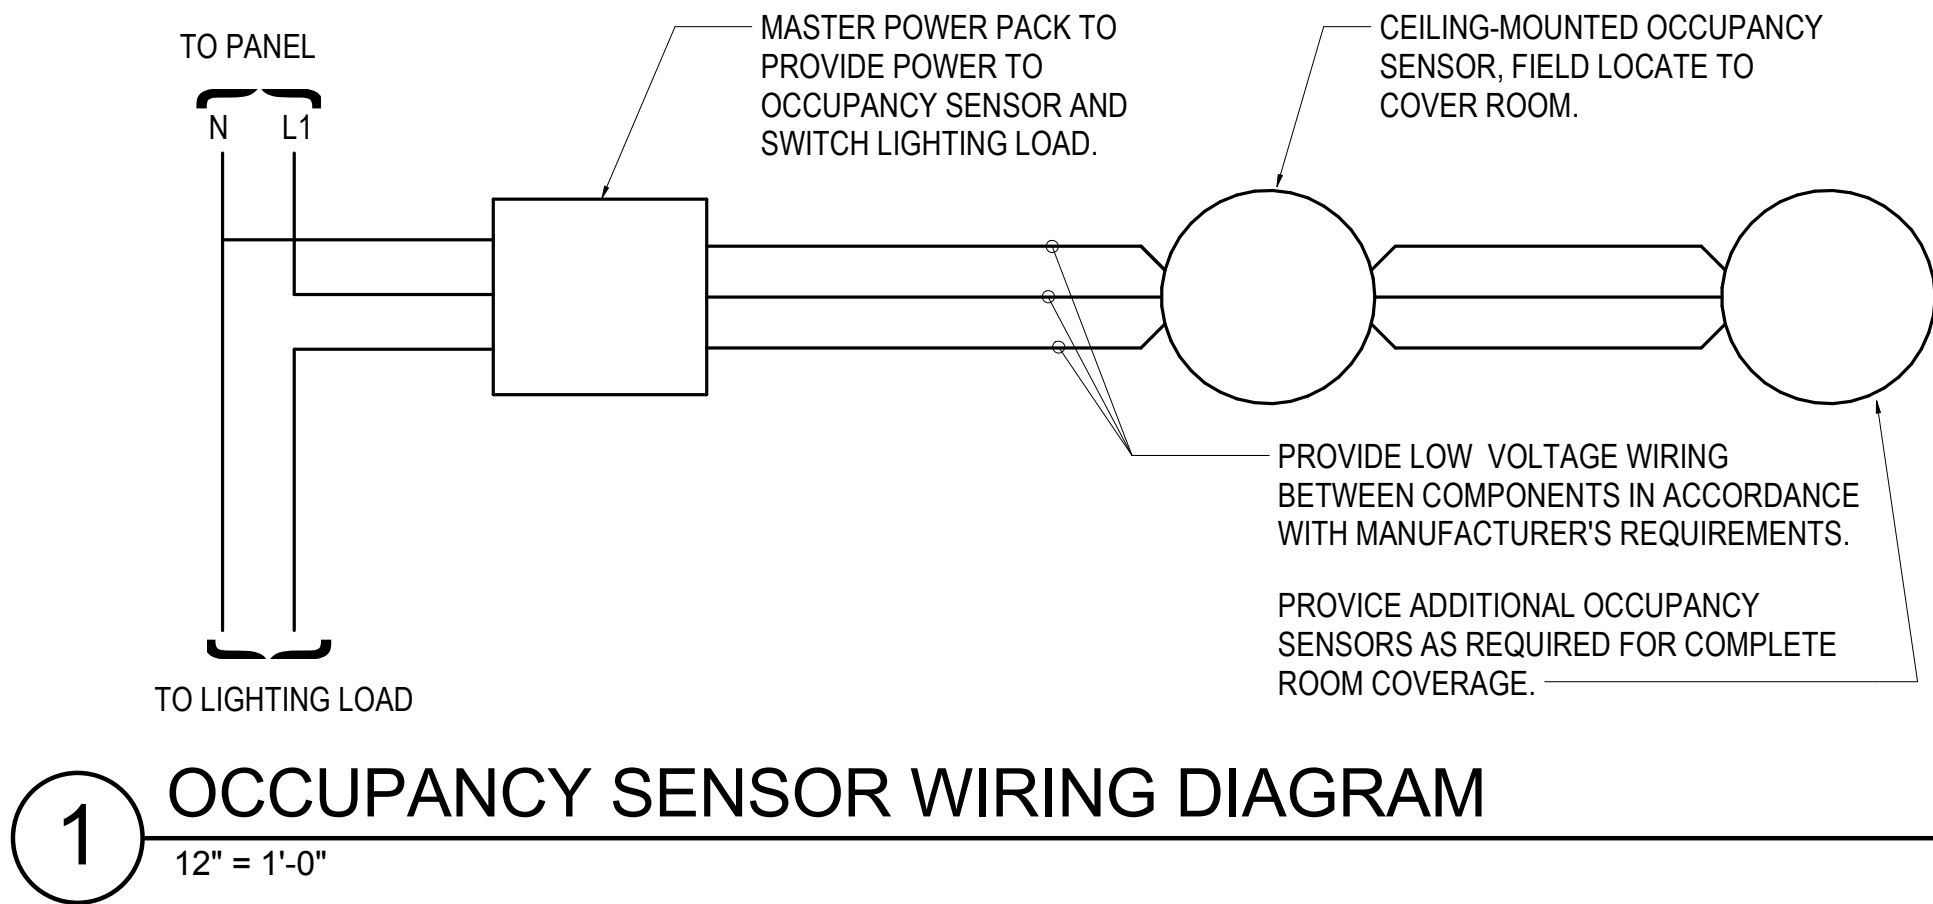

ELECTRICAL LEGEND			
	LIGHT FIXTURE - SURFACE MOUNTED CEILING		DUPLEX RECEPTACLE TO BE REMOVED (DASHED OR DOTTED LINES INDICATE ITEMS TO BE REMOVED.TYPICAL)
	LIGHT FIXTURE - RECESS MOUNTED CEILING		NOTE TAG (No. INDICATES NOTE)
	EMERGENCY LIGHT FIXTURE - RECESS MOUNTED CEILING	AFF	ABOVE FINISHED FLOOR
	NEW FIXTURE TAG (LETTER INDICATES TYPE)	GFCI	GROUND FAULT CIRCUIT INTERRUPTER
	EXISTING FIXTURE TAG (LETTER INDICATES TYPE)	GRSC	GALVANIZED RIGID STEEL CONDUIT
\$	SINGLE POLE SWITCH	LED	LIGHT EMITTING DIODE
	OCCUPANCY SENSOR - CEILING MOUNTED	LM	LUMENS
	DUPLEX RECEPTACLE WITH GROUND FAULT CIRCUIT INTERRUPTER	NEC	NATIONAL ELECTRICAL CODE
	SPEAKER - CEILING MOUNTED	R	DENOTES EXISTING ITEM THAT HAS BEEN RELOCATED
	FIRE ALARM HORN (CEILING-MOUNTED)	TYP	TYPICAL
	FIRE ALARM HORN/STROBE LIGHT (CEILING-MOUNTED)	UON	UNLESS OTHERWISE NOTED
	FIRE ALARM STROBE LIGHT (CEILING-MOUNTED)	T	TAMPER RESISTANT
		E	DENOTES EXISTING ITEM

GENERAL NOTES

- A. EXISTING LIGHTING FIXTURES ARE BEING REPLACED WITH MORE EFFICIENT LED TYPE FIXTURES AND NO OTHER NEW LOADS ARE BEING ADDED TO THE FACILITY. THEREFORE, THERE IS AN OVERALL REDUCTION OF LOAD ON THE EXISTING BRANCH CIRCUITS AND ELECTRICAL DISTRIBUTION SYSTEM.

SHEET NOTES

1. PROVIDE EMERGENCY BATTERY BACKUP OPTION -LEL FOR FIXTURES WHERE REQUIRED. SEE REMODEL PLAN 1/E201 FOR FIXTURES REQUIRING EMERGENCY BATTERIES.

EXISTING LIGHT FIXTURE SCHEDULE							
TYPE	LOCATION	LUMINAIRE DESCRIPTION	MOUNTING		LAMPS	BALLAST/DRIVER	TOTAL INPUT WATTS
			TYPE	HEIGHT			
A	LOCKER ROOMS, SHOWERS	4' FIBERGLASS HOUSING, FULLY GASKETED, LISTED FOR WET LOCATIONS AND POLYCARBONATE HOUSING.	SURFACE	CEILING	(2) T8	277V ELECTRONIC BALLAST	60
B	RESTROOMS	2'x2' LENSED TROFFER, A19 ACRYLIC LENS	RECESSED	CEILING	(2) T12 U-LAMP	277V ELECTRONIC BALLAST	72


LIGHT FIXTURE SCHEDULE								
TYPE	LOCATION	MANUFACTURER AND CATALOG NUMBER (OR APPROVED EQUAL)	LUMINAIRE DESCRIPTION	MOUNTING		LAMPS	BALLAST/DRIVER	TOTAL INPUT WATTS
				TYPE	HEIGHT			
A	LOCKER ROOM, RESTROOMS	KENALL #RMCA-4-FL/TR-0/0-45L40K-DCC -DV-1/G-1	48"Lx11.875"Wx4.875"H RECESSED, ROUGH SERVICE FIXTURE, FLANGE FOR HARD CEILING MOUNTING, PRIMATIC ACRYLIC INNER LENS WITH CLEAR POLYCARBONATE OUTER LENS, AND SECURITY FASTENERS.	RECESSED	CEILING	4,000K LED 2,928LM	120-277V, 0-10 VOLT DIMMING DRIVER	50
A1	SHOWERS	KENALL #RMCA-4-FL/TR-0/0-45L40K-DCC -DV-1/G-1-WL	SAME AS TYPE 'A' EXCEPT LISTED FOR WET LOCATIONS.	RECESSED	CEILING	4,000K LED 2,928LM	120-277V, 0-10 VOLT DIMMING DRIVER	50

REVIEWED BY:
JOB NO. L7082
PROJ. MGR.: PCC
DRAWN BY: PCC
DATE: 11-15-2017
REVISIONS:
JAM, XPT


MCCOOL CARLSON GREEN
ARCHITECTURE • PLANNING • INTERIORS
HISTORIC ANCHORAGE TRAIN DEPOT
421 W. 1ST AVENUE • SUITE 300 • ANCHORAGE, AK 99501
907.563.8474 PHONE • 907.563.4572 FAX • WWW.MCGALASKA.COM

VCS RESTROOM RENOVATION
VOLUME 2 HHES
1009 W Klutina St. Valdez, AK 99686
CITY OF VALDEZ
ELECTRICAL LEGEND, DETAILS,
AND FIXTURE SCHEDULES

SHEET NO.
E001-2

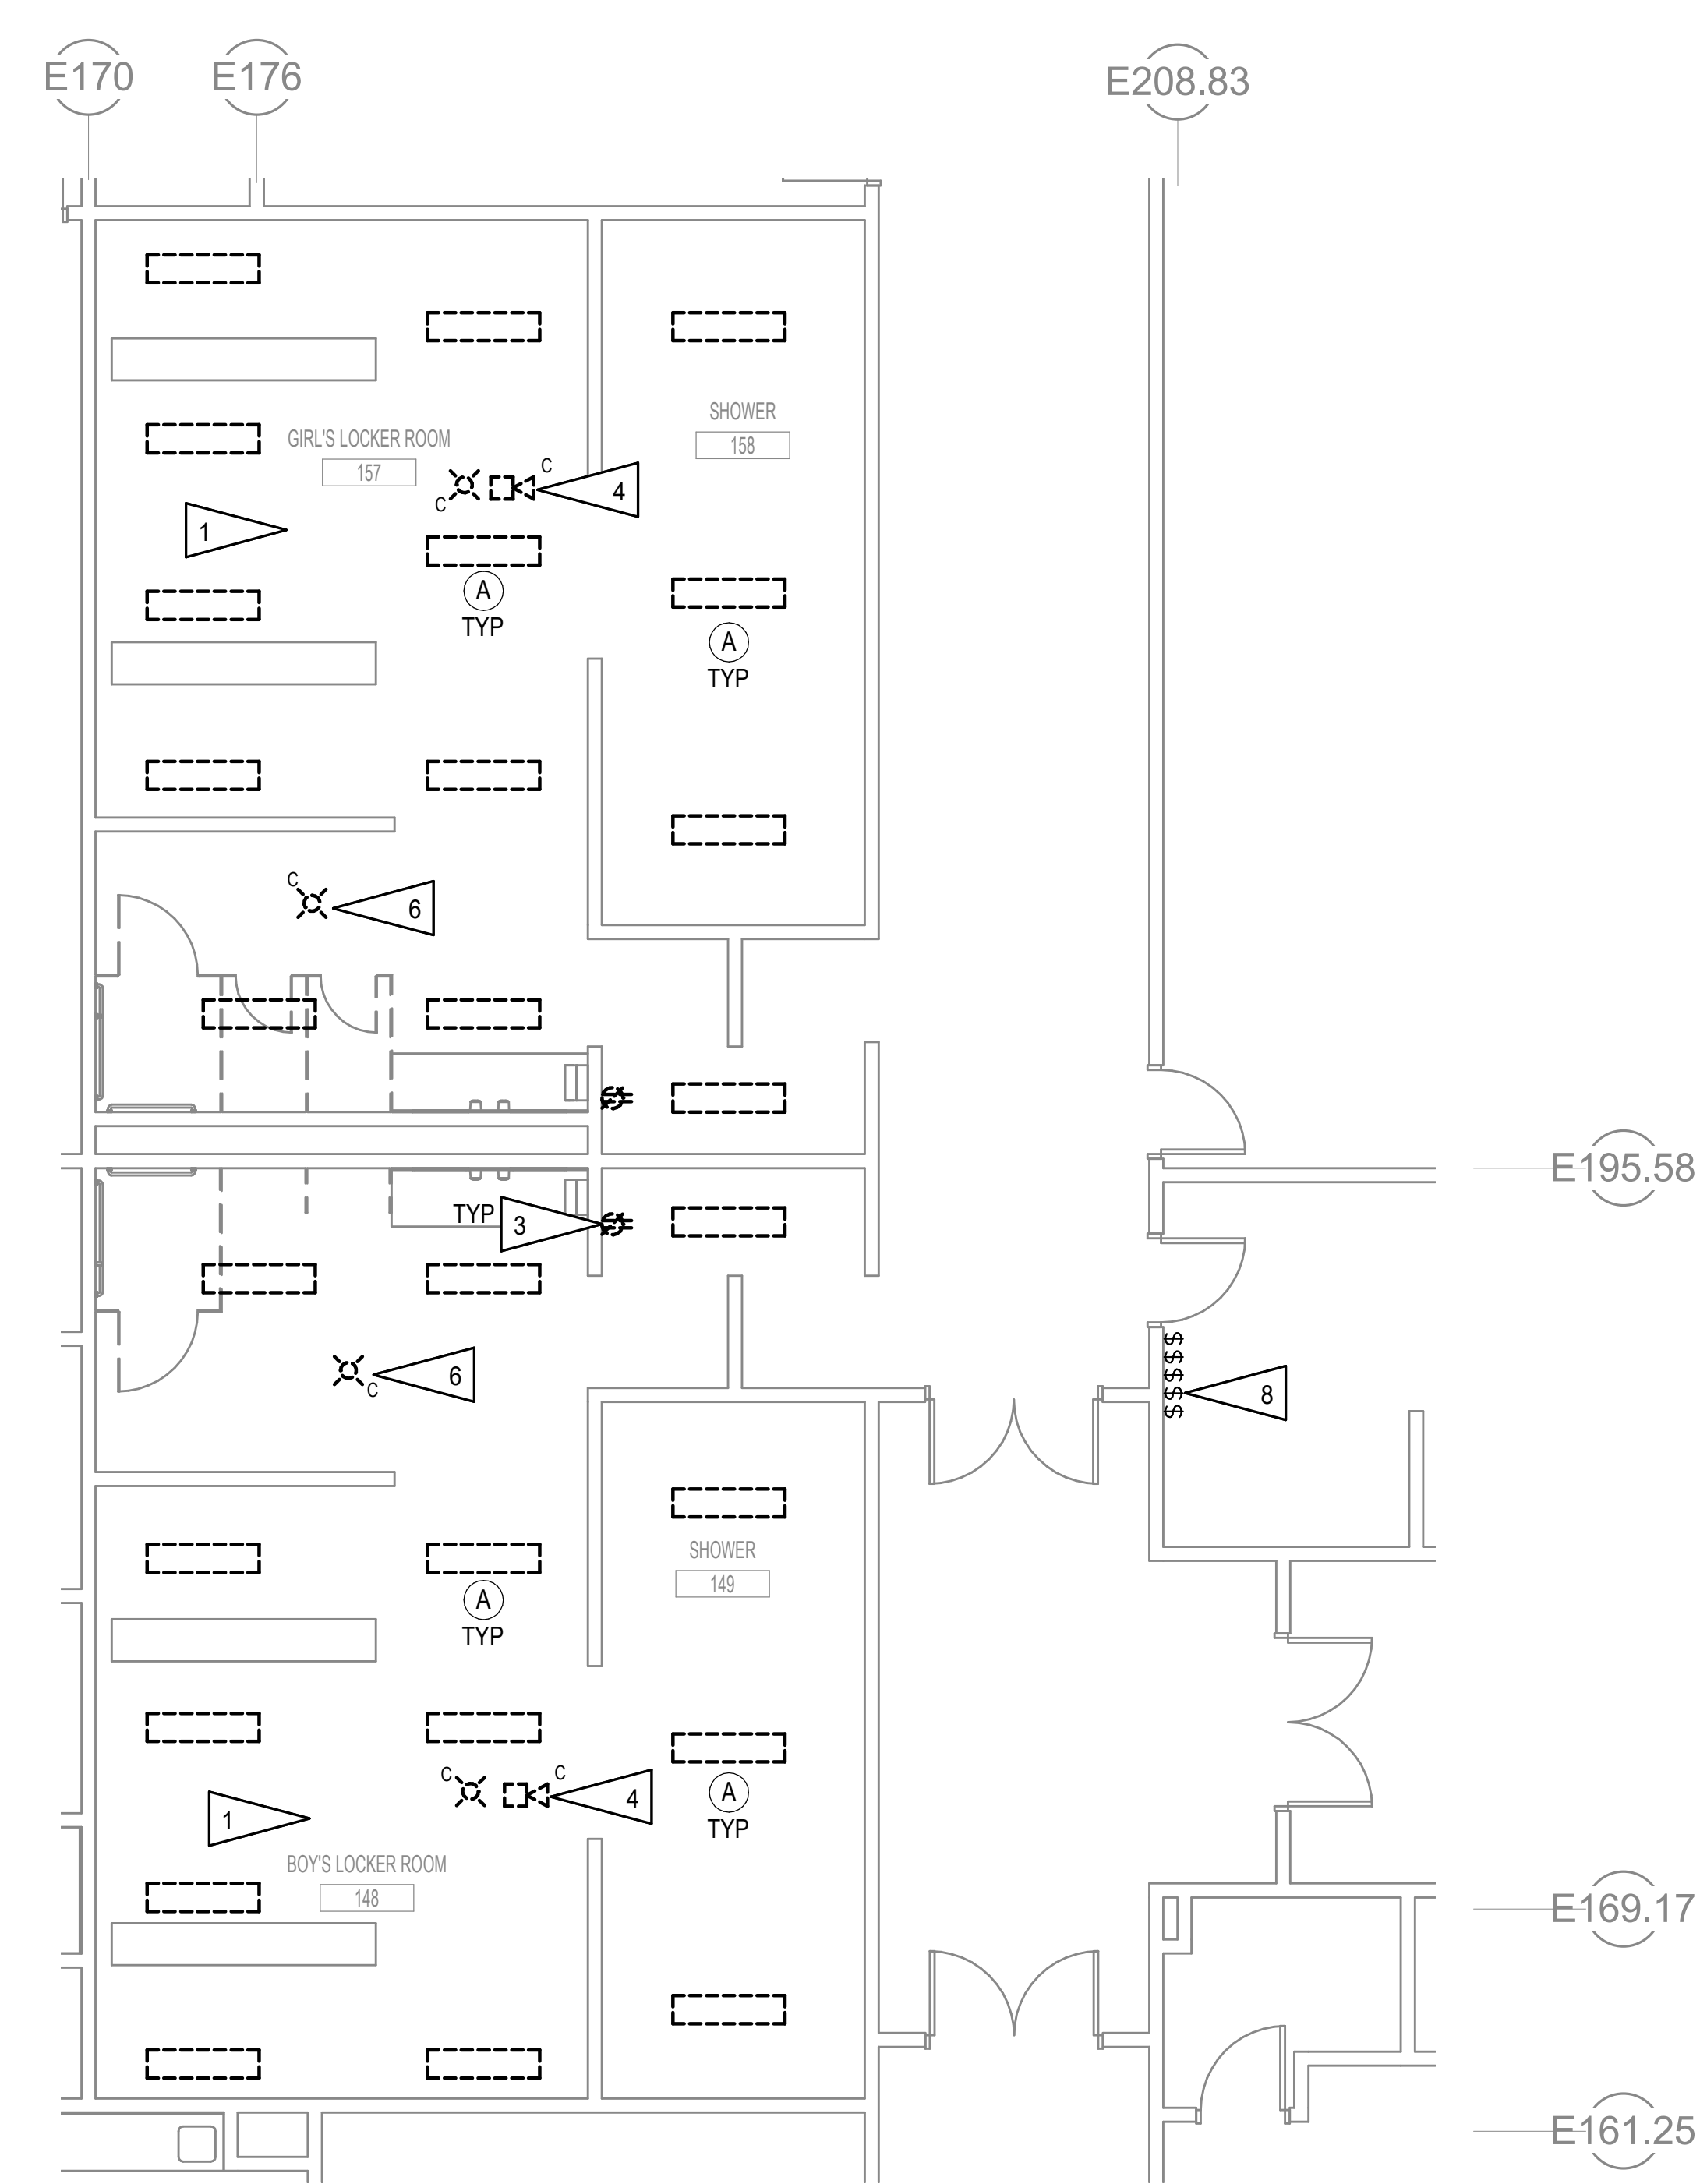

1 ELECTRICAL DEMOLITION PLAN - LOCKERS 148 & 157
3/16" = 1'-0"

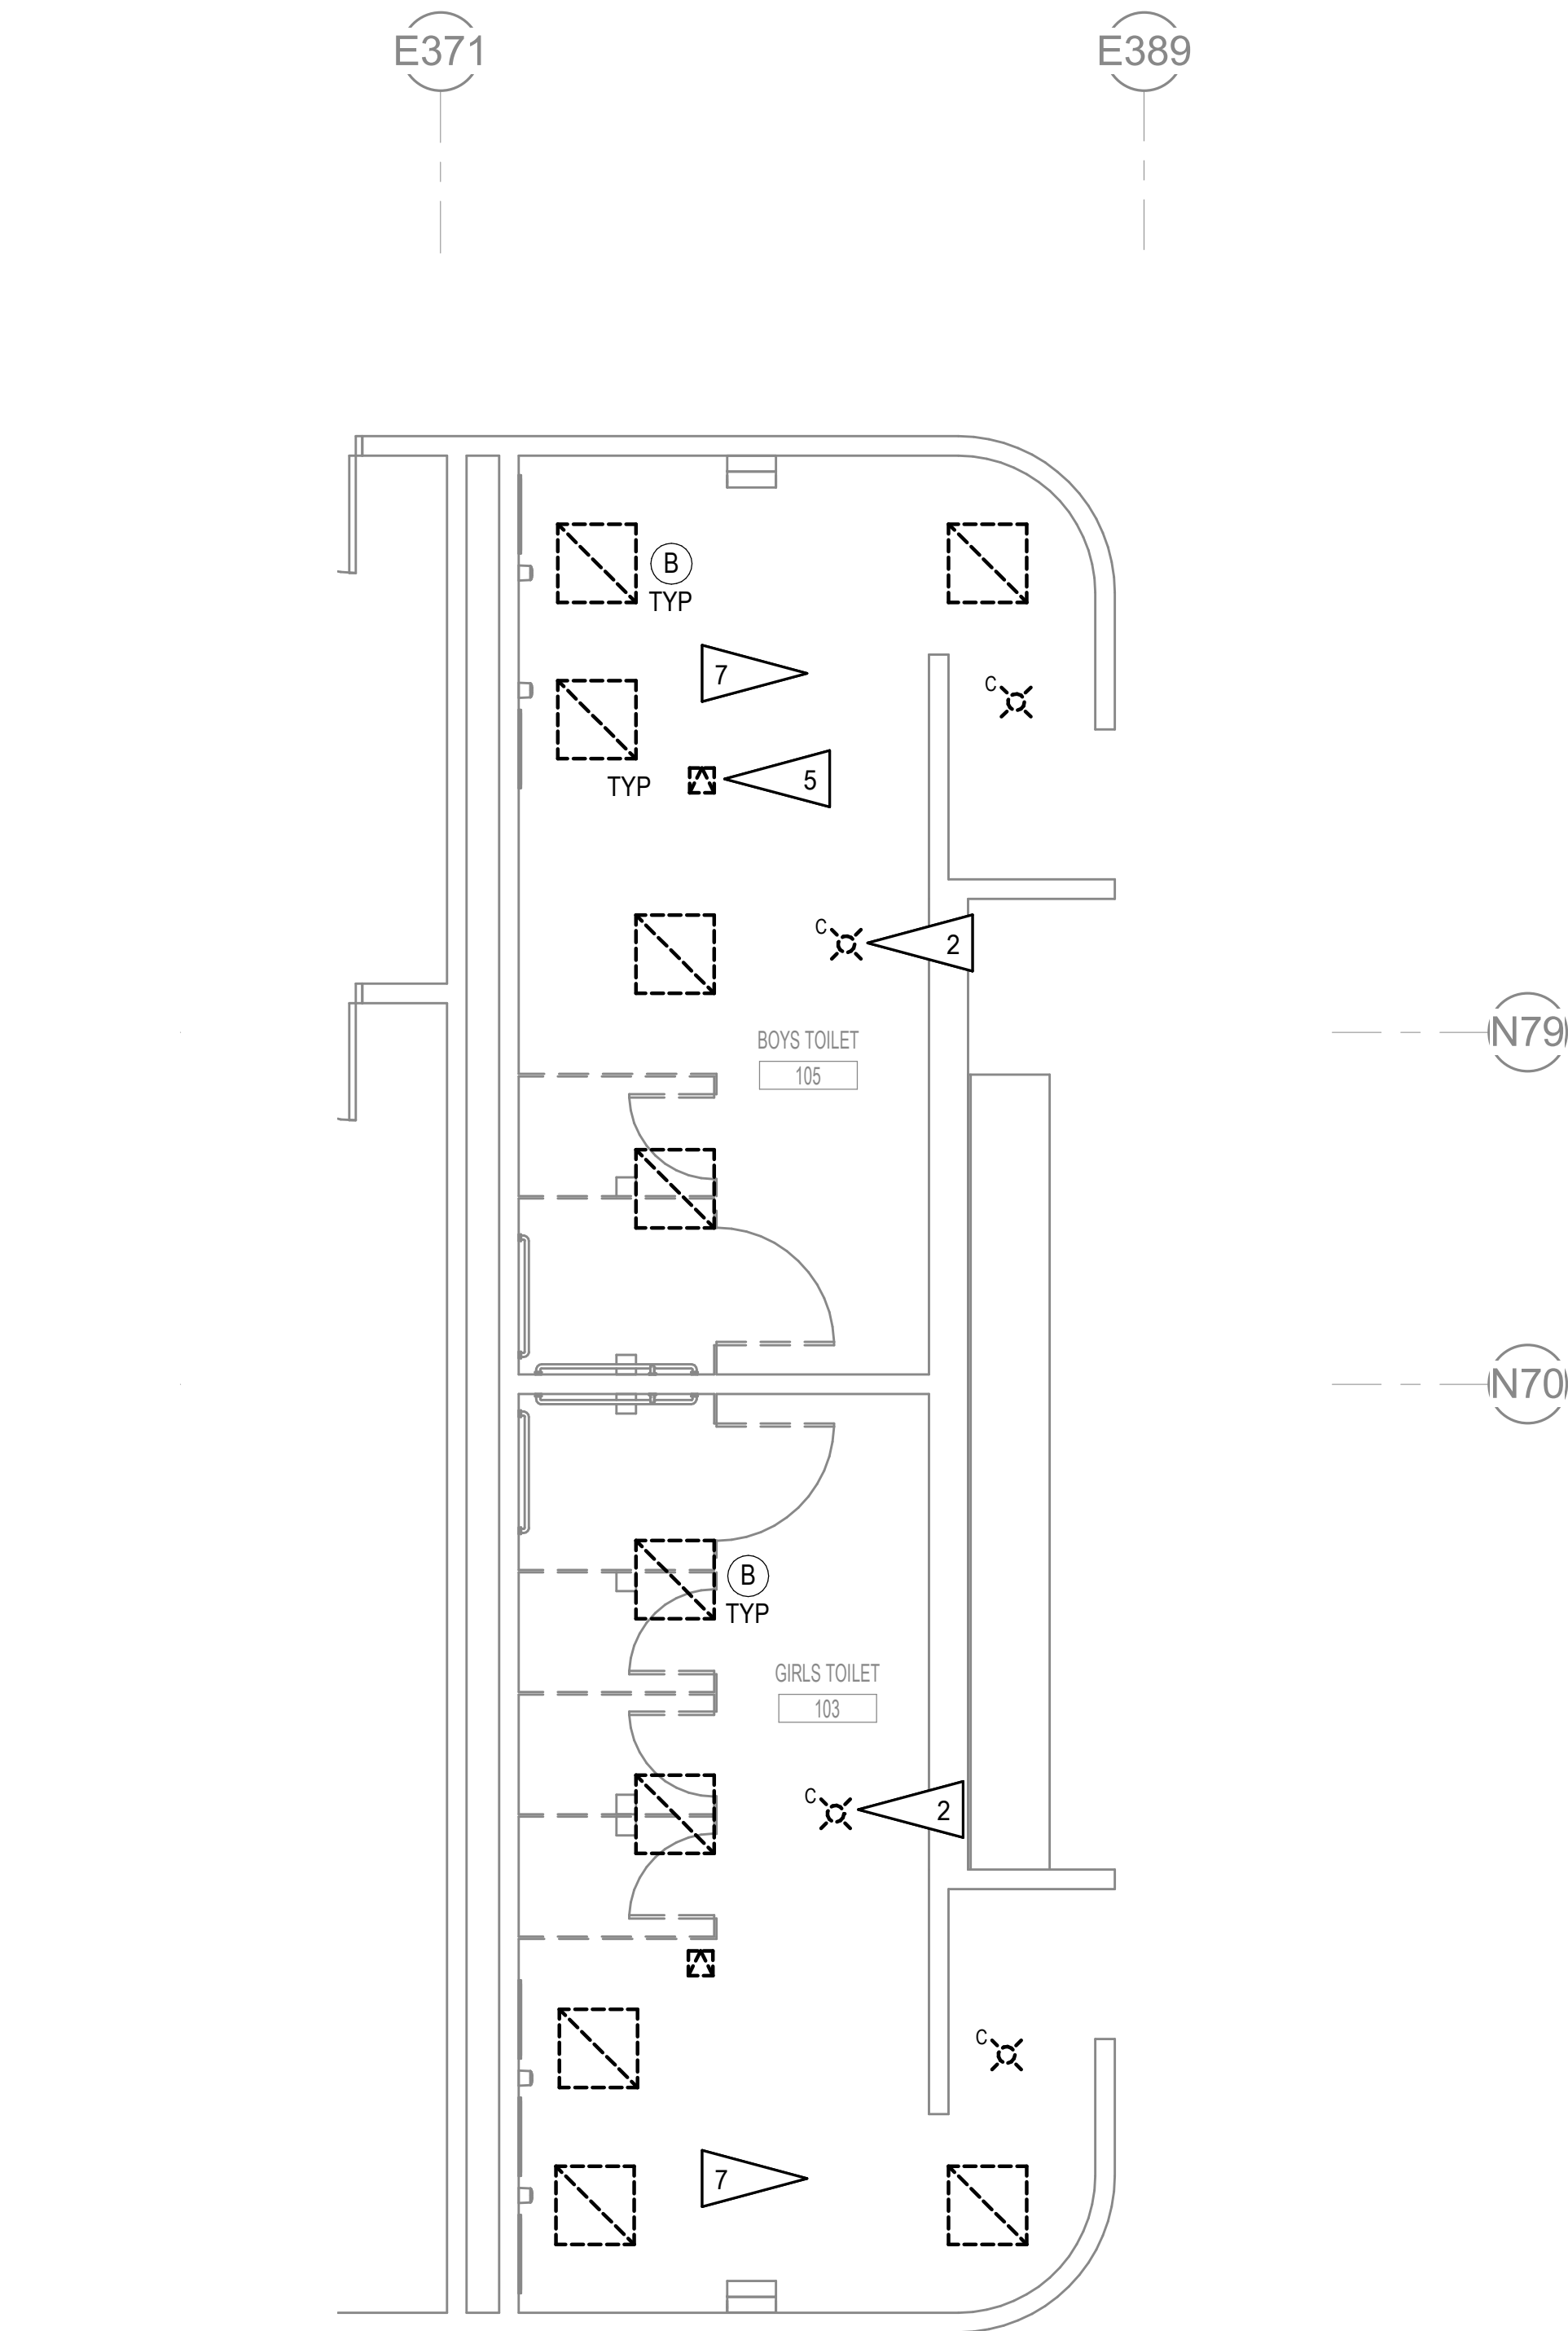


2 ELECTRICAL DEMOLITION PLAN - RESTROOM 103 & 105
1/4" = 1'-0"

GENERAL NOTES:

- THE INFORMATION SHOWN ON THE DEMOLITION PLAN IS BASED ON FIELD OBSERVATION AND EXISTING RECORD DRAWINGS. THERE IS NO GUARANTEE AS TO THE ACCURACY OF THE INFORMATION SHOWN THE CONTRACTOR SHALL FIELD VERIFY ALL ITEMS PRIOR TFO THE START OF WORK.
- THE OWNER SHALL HAVE FIRST RIGHT OF REFUSAL ON ALL SALVAGABLE MATERIALS. THE CONTRACTOR SHALL DELIVER MATERIAL TO A WAREHOUSE AS DIRECTED BY THE OWNER. THE CONTRACTOR SHALL DISPOSE OF ALL UNWANTED MATERIALS OFF SITE.
- UNLESS OTHERWISE NOTED, DOTTED OR DASHED LINES INDICATE ITEMS TO BE REMOVED.

SHEET NOTES

- SALVAGE LIGHTING CIRCUIT FOR CONNECTION TO NEW FIXTURES IN EXISTING LOCATIONS. SEE REMODEL PLAN 1/E201 FOR NEW FIXTURE LOCATIONS.
- SALVAGE FIRE ALARM DEVICE AND CIRCUIT FOR INSTALLATION IN NEW CEILING SYSTEM. SEE REMODEL PLAN 2/E201 FOR DEVICE LOCATION.
- SALVAGE CIRCUIT FOR INSTALLATION OF NEW DEVICE IN EXISTING CIRCUIT LOCATION. SEE REMODEL PLAN 1/E201 FOR NEW DEVICE LOCATION.
- SALVAGE FIRE ALARM CIRCUIT FOR CONNECTION TO NEW DEVICE IN EXISTING LOCATION. SEE REMODEL PLAN 1/E201 FOR DEVICE LOCATION.
- SALVAGE SPEAKER AND CIRCUIT FOR INSTALLATION IN NEW CEILING SYSTEM. SEE 2/E201 FOR SPEAKER LOCATION.
- SALVAGE FIRE ALARM DEVICE AND CIRCUIT FOR INSTALLATION IN EXISTING LOCATION. SEE REMODEL PLAN 1/E201.
- SALVAGE LIGHTING CIRCUIT FOR CONNECTION TO NEW FIXTURES IN NEW LOCATIONS. SEE REMODEL PLAN 2/E201.
- DISCONNECT SWITCH FROM LOCKER ROOM LIGHTS. MAINTAIN CONTROL OF EXISTING CORRIDOR LIGHTS TO REMAIN. SEE REMODEL PLAN 1/E201.

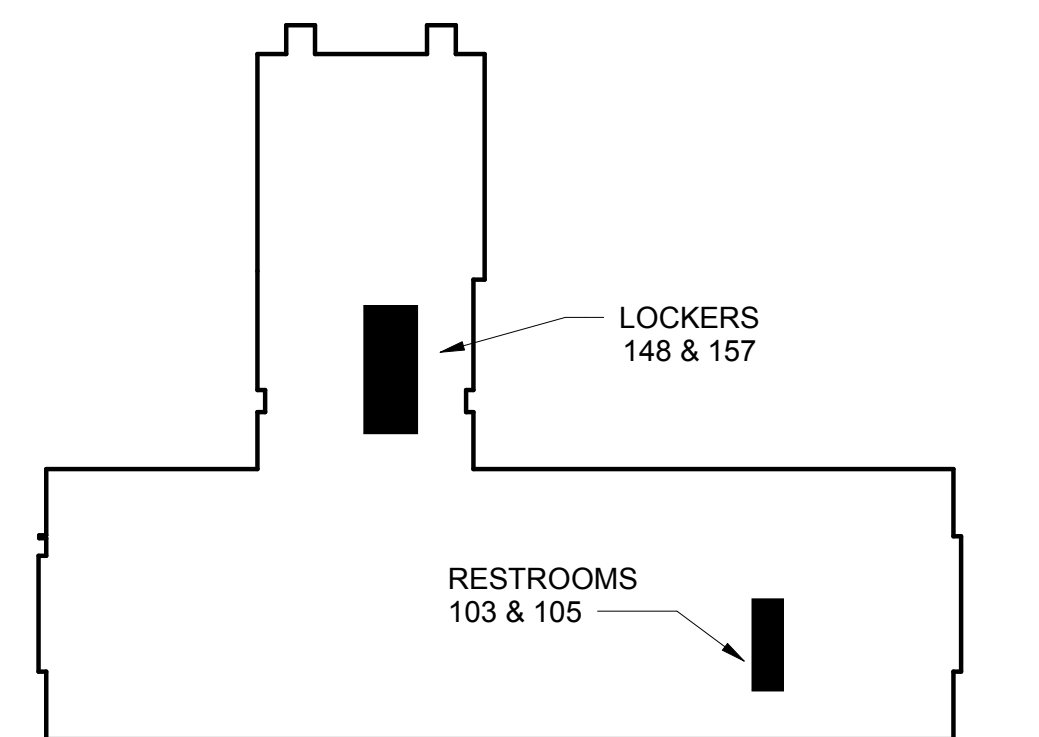

KEY PLAN

NO SCALE

CONSTRUCTION DOCUMENTS

SHEET NO.

E101-2

VCS RESTROOM RENOVATION


VOLUME 2 HHES

1009 W Klutina St. Valdez, AK 99686

CITY OF VALDEZ


HHES LOCKER AND RESTROOM
ELECTRICAL DEMOLITION PLAN

MCCOOL CARLSON GREEN
ARCHITECTURE • PLANNING • INTERIORS
HISTORIC ANCHORAGE TRAIN DEPOT
421 W. 1ST AVENUE • SUITE 300 • ANCHORAGE, AK 99501
907.563.8474 PHONE • 907.563.4572 FAX • WWW.MCGALASKA.COM

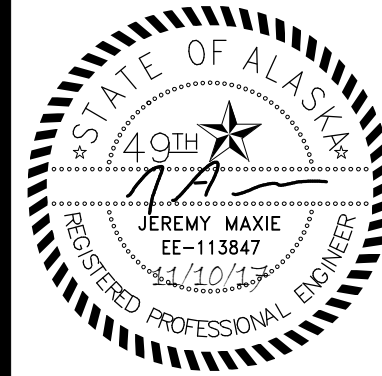


REVIEWED BY:	DATE: 11-15-2017
PROJ. MGR: PCC	REVISIONS:
DRAWN BY: PCC	
JAM, XPT	

1 ELECTRICAL REMODEL PLAN - LOCKERS 148 & 157
3/16" = 1'-0"

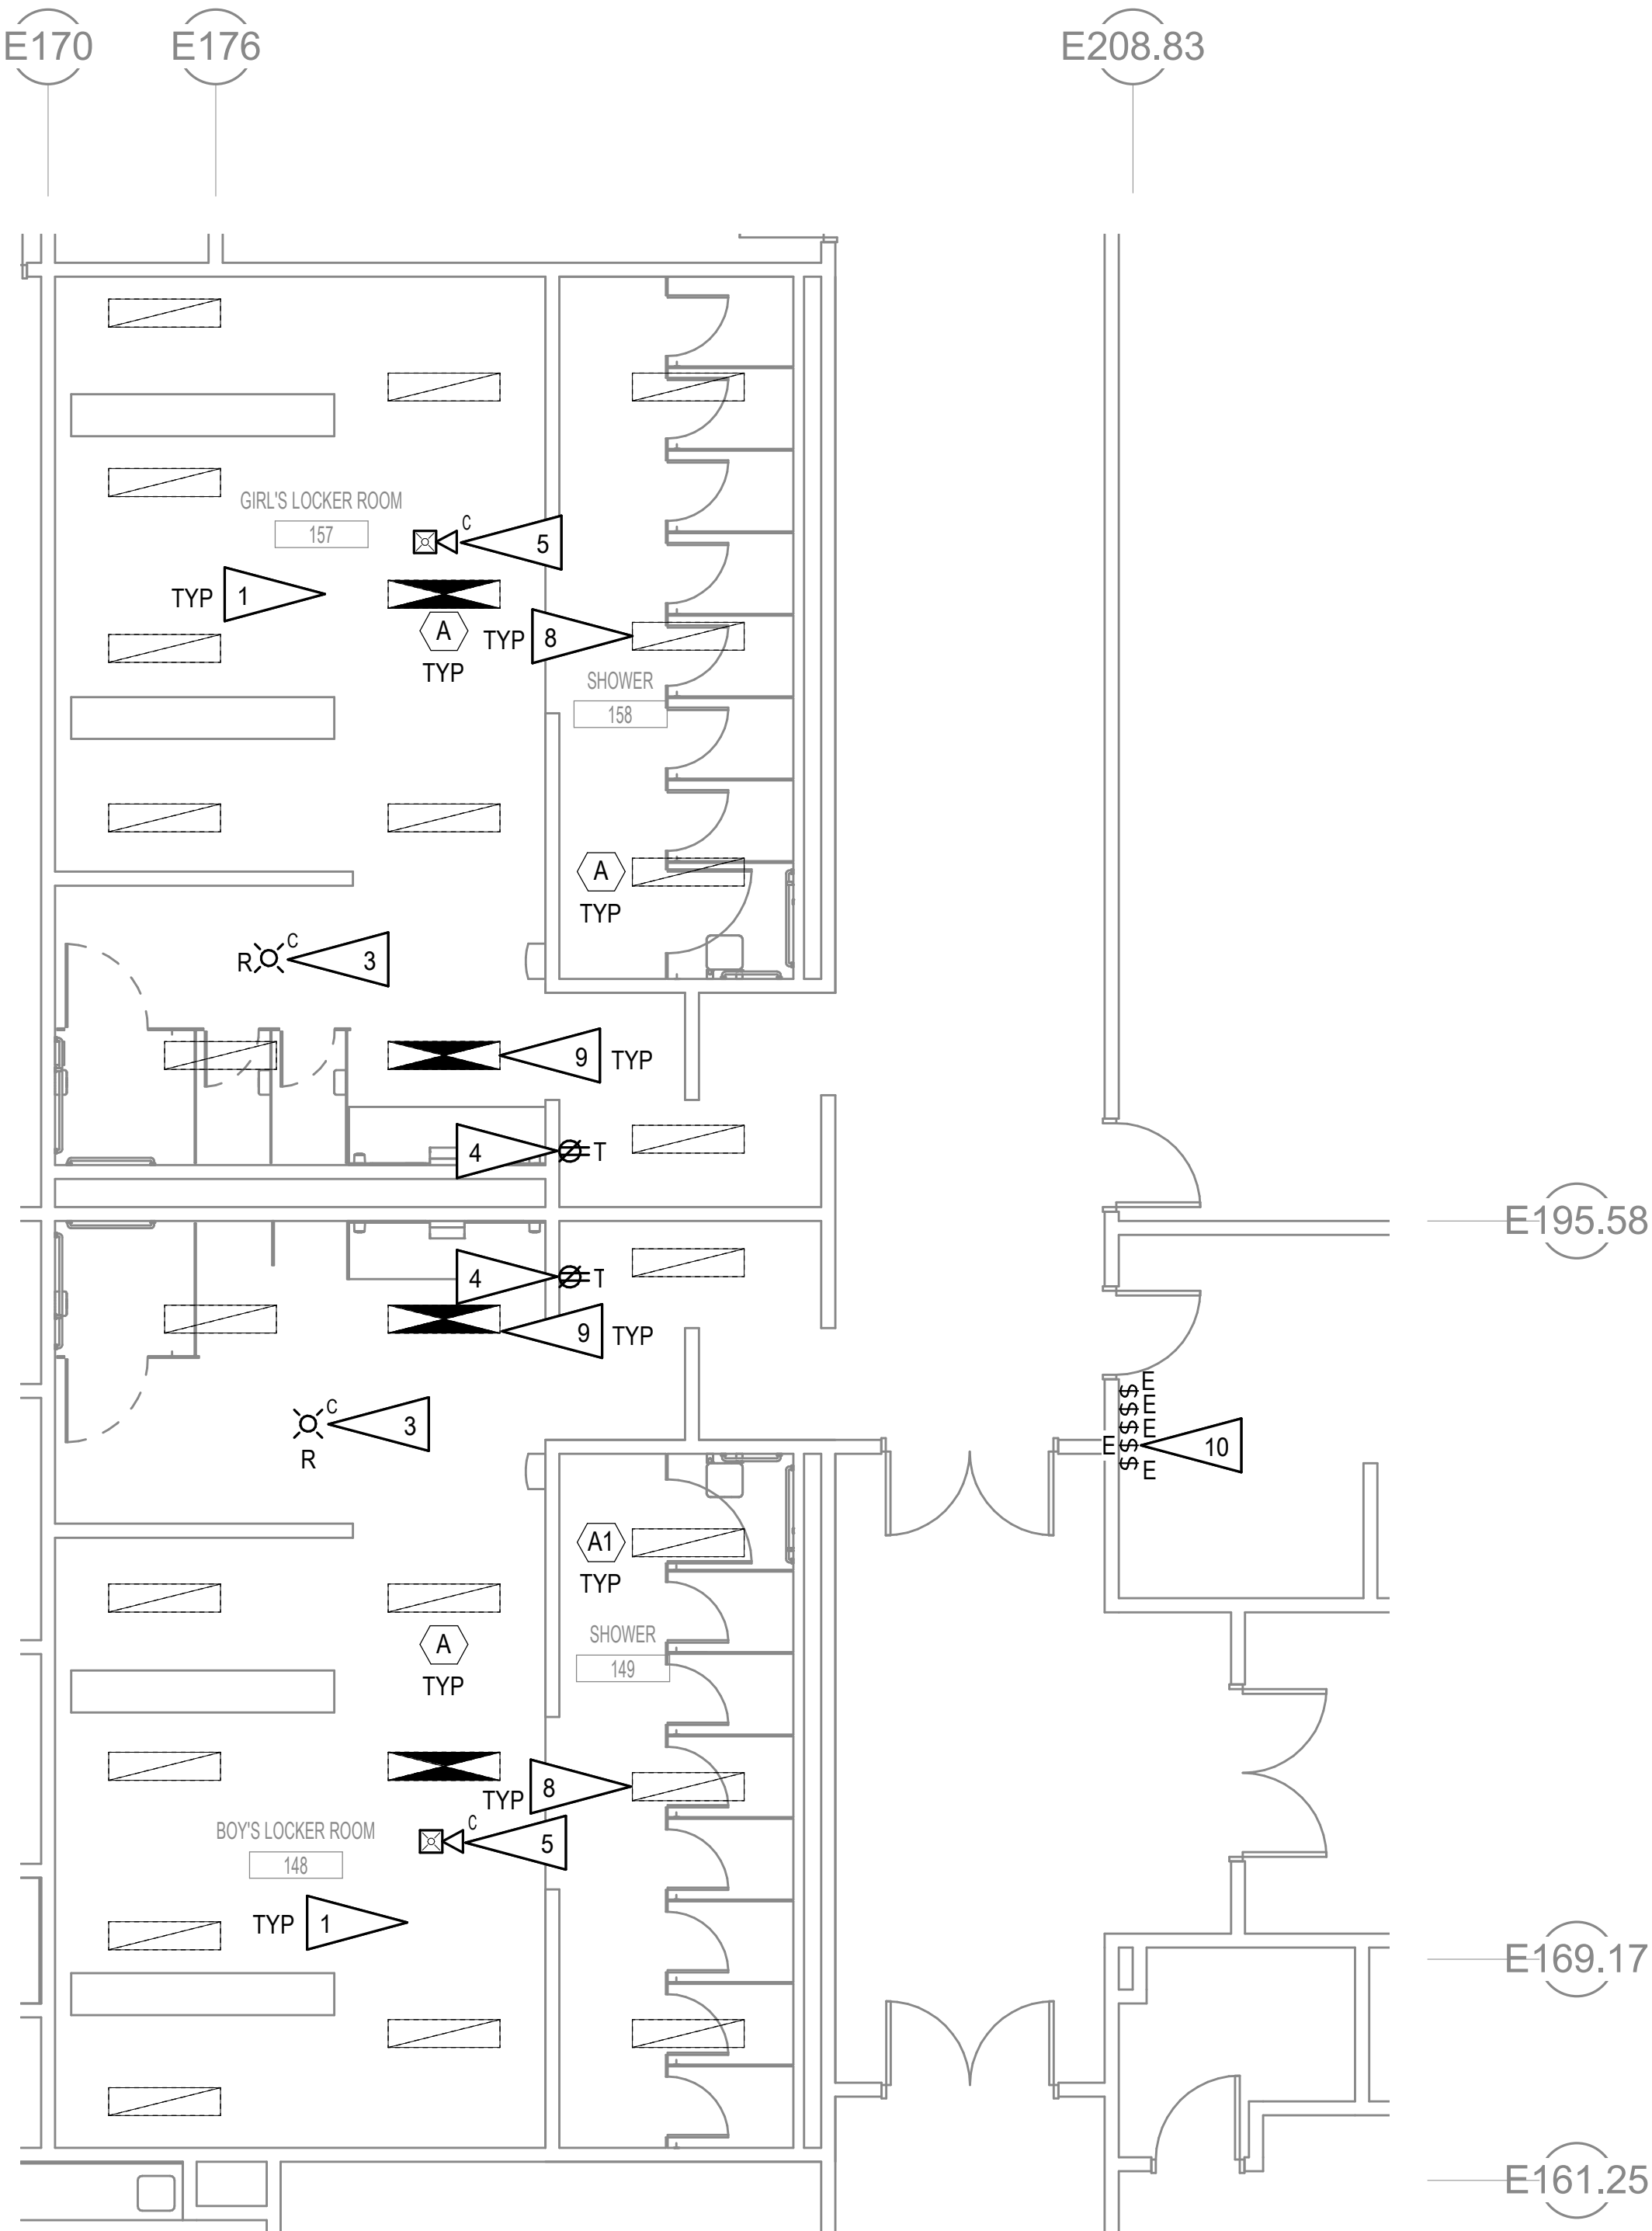

2 ELECTRICAL REMODEL PLAN - RESTROOM 103 & 105
1/4" = 1'-0"

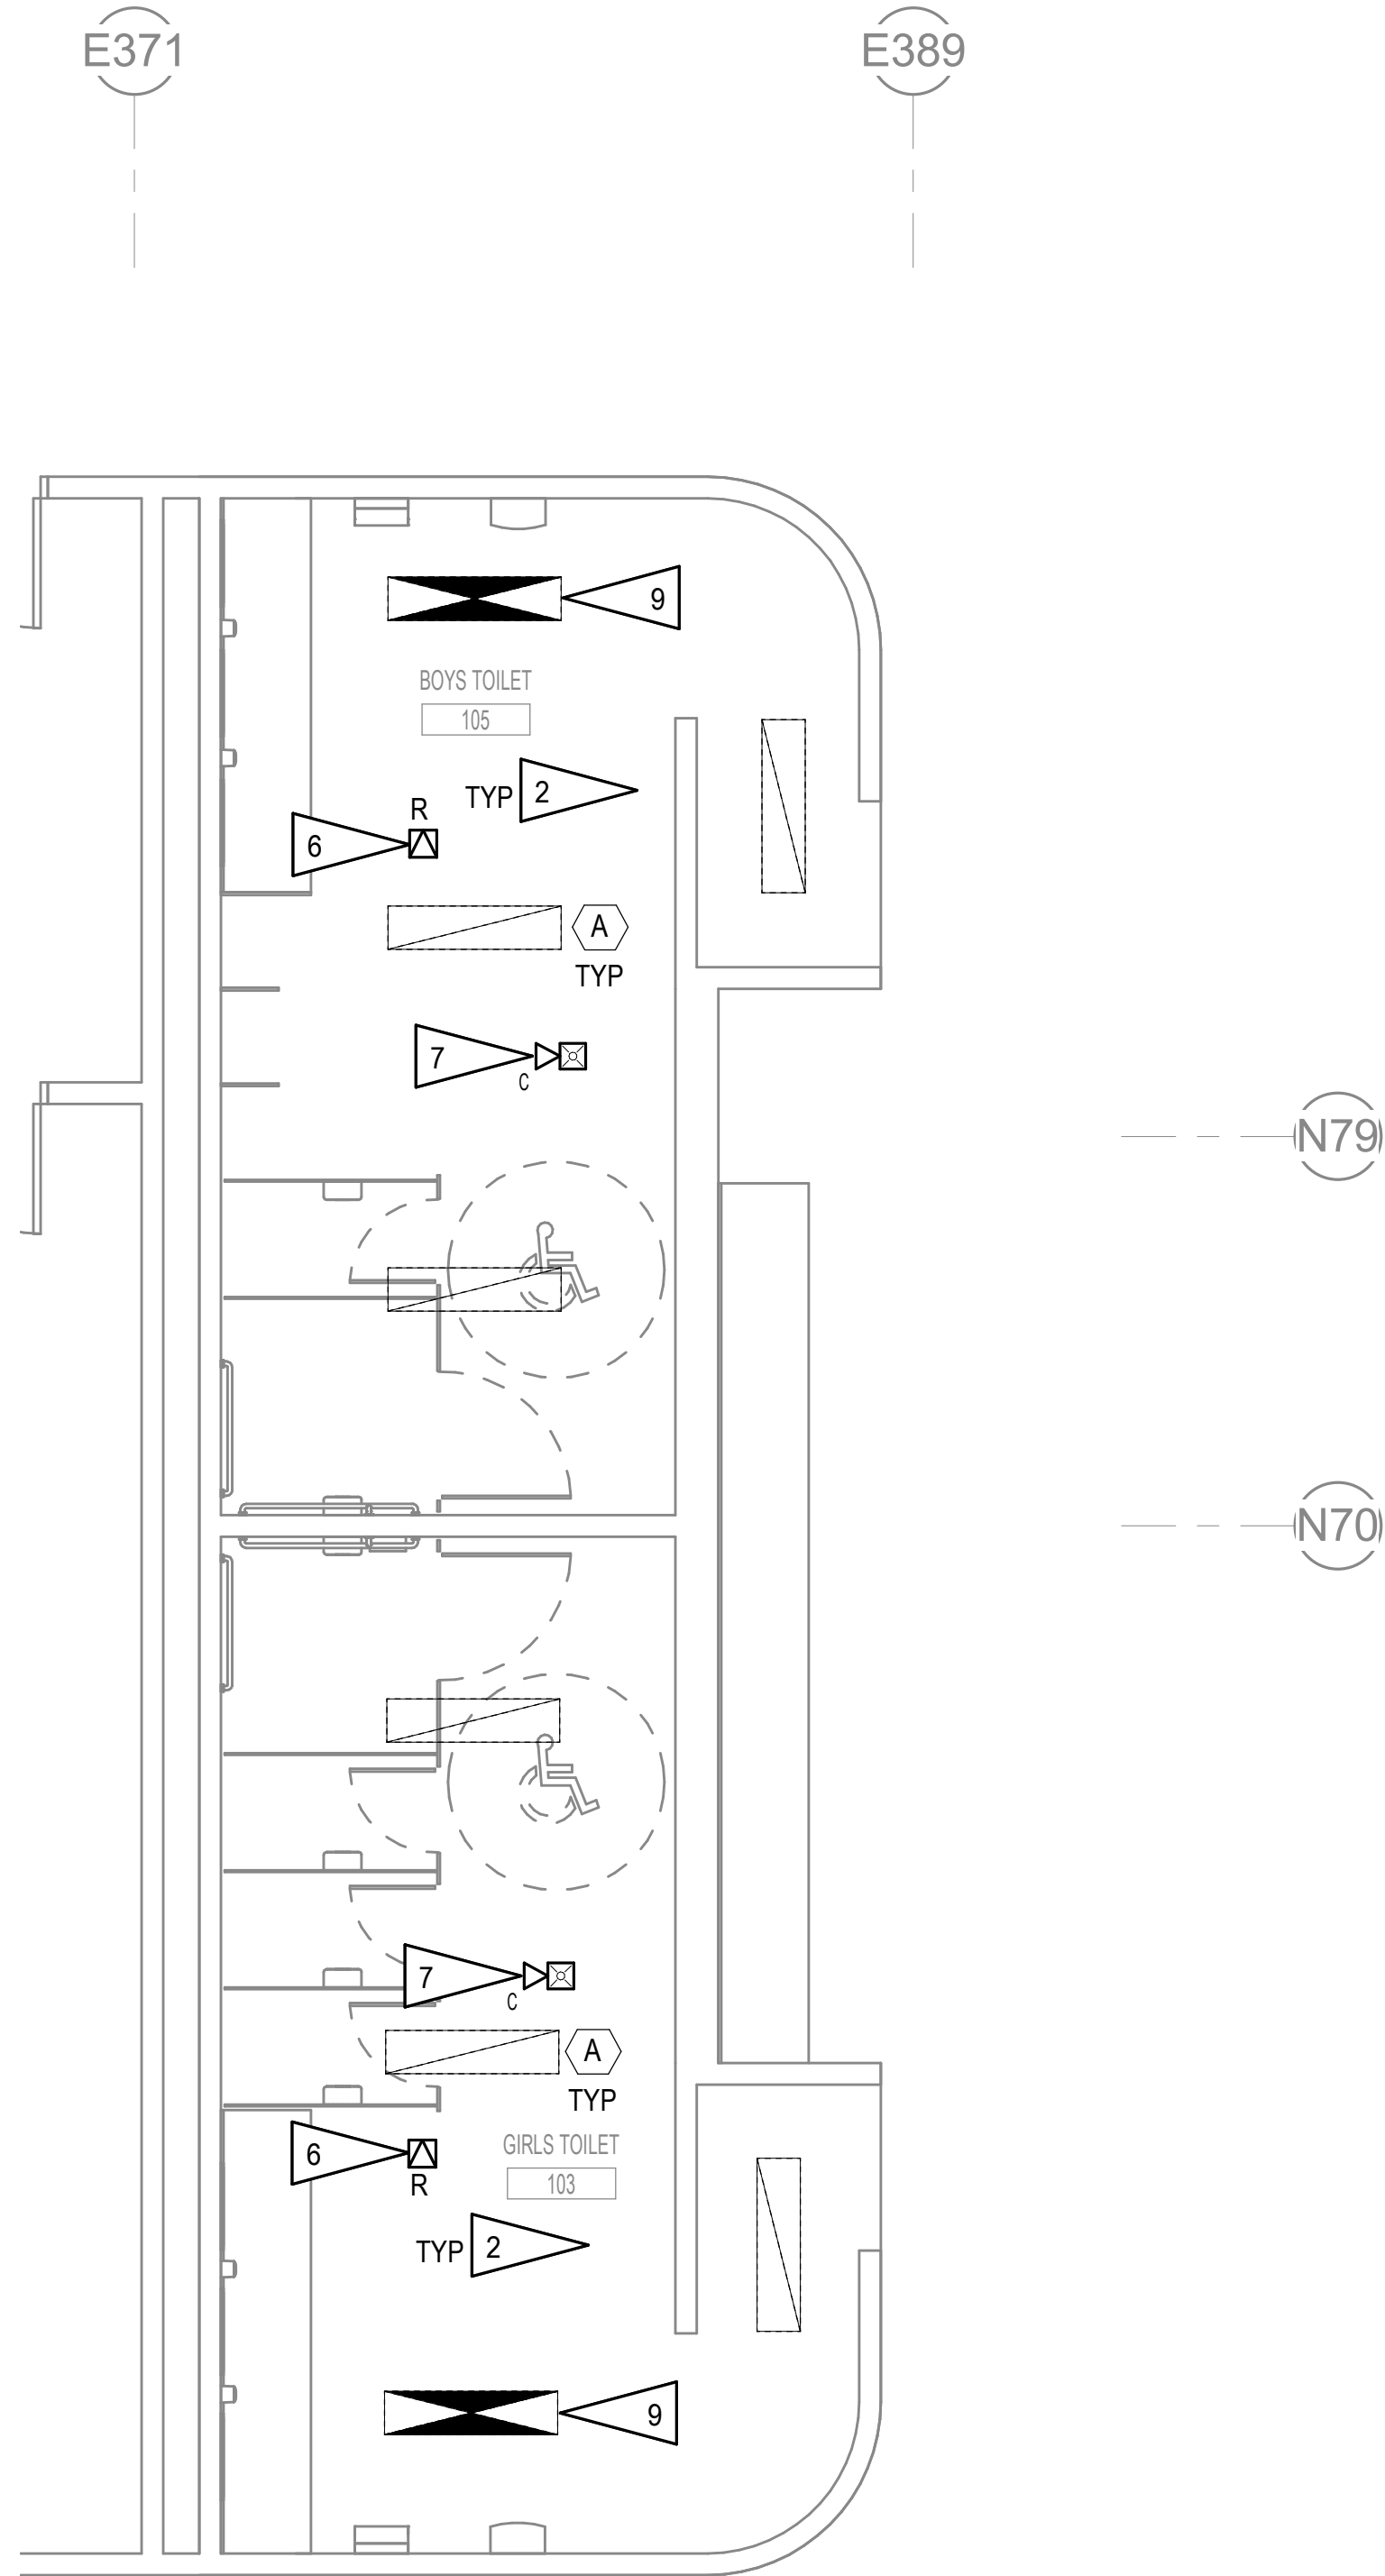


GENERAL NOTES

- A. CONTRACTOR TO PROVIDE ACCESS PANELS IN NEW CEILING SYSTEM TO PROVIDE ACCESS TO ALL EXISTING AND NEW JUNCTION BOXES PER NEC OR REWIRE EXISTING ELECTRICAL SYSTEMS TO ELIMINATE ACCESS REQUIREMENT.

SHEET NOTES

1. INSTALL NEW FIXTURES IN EXISTING CIRCUIT LOCATION. SEE DEMOLITION PLAN 1/E101 FOR EXISTING CIRCUIT LOCATION. PROVIDE JUNCTION BOXES, CONDUIT, AND WIRE AS REQUIRED TO ACCOMMODATE NEW CEILINGS.
2. INSTALL NEW FIXTURES IN NEW LOCATION. SEE DEMOLITION PLAN 2/E101 FOR EXISTING CIRCUIT LOCATION. PROVIDE JUNCTION BOXES, CONDUIT, AND WIRE AS REQUIRED.
3. INSTALL RELOCATED FIRE ALARM DEVICE IN EXISTING CIRCUIT LOCATION. SEE DEMOLITION PLAN 1/E101 FOR EXISTING CIRCUIT LOCATION. PROVIDE JUNCTION BOXES, CONDUIT, AND WIRE AS REQUIRED.
4. INSTALL NEW DEVICE IN EXISTING CIRCUIT LOCATION. SEE DEMOLITION PLAN 1/E101 FOR EXISTING CIRCUIT LOCATION. PROVIDE JUNCTION BOXES, CONDUIT, AND WIRE AS REQUIRED.
5. INSTALL NEW FIRE ALARM DEVICE IN EXISTING CIRCUIT LOCATION. SEE DEMOLITION PLAN 1/E101 FOR EXISTING CIRCUIT LOCATION. PROVIDE JUNCTION BOXES, CONDUIT, AND WIRE AS REQUIRED.
6. INSTALL RELOCATED SPEAKER IN EXISTING CIRCUIT LOCATION. SEE DEMOLITION PLAN 2/E101 FOR EXISTING CIRCUIT LOCATION. PROVIDE NEW SPEAKER BACK BOX AND MOUNTING HARDWARE FOR INSTALLATION IN NEW GYP BOARD CEILING. PROVIDE JUNCTION BOXES, CONDUIT, AND WIRE AS REQUIRED.
7. INSTALL NEW FIRE ALARM DEVICE IN NEW LOCATION. SEE DEMOLITION PLAN 2/E101 FOR EXISTING CIRCUIT LOCATION. PROVIDE JUNCTION BOXES, CONDUIT, AND WIRE AS REQUIRED.
8. INSTALL NEW FIXTURES IN EXISTING CIRCUIT LOCATION. SEE DEMOLITION PLAN 1/E101 FOR EXISTING CIRCUIT LOCATION. PROVIDE JUNCTION BOXES, CONDUIT, AND WIRE AS REQUIRED.
9. PROVIDE EXTENSION OF UNSWITCHED LEG OF LOCAL LIGHTING CIRCUIT TO FIXTURE INDICATED. ASSUME FOR BIDDING PURPOSES THAT NEAREST UNSWITCHED LEG IS LOCATED IN ADJACENT HALL. PROVIDE JUNCTION BOXES, CONDUIT, AND WIRE AS REQUIRED.
10. PROVIDE EXTENSION OF UNSWITCHED LEG OF LIGHTING CIRCUIT TO LOCKER ROOM LIGHTS. MAINTAIN SWITCH TO OPERATE EXISTING CORRIDOR LIGHTS TO REMAIN. SEE DEMOLITION PLAN 1/E101. PROVIDE JUNCTION BOXES, CONDUIT, AND WIRE AS REQUIRED.

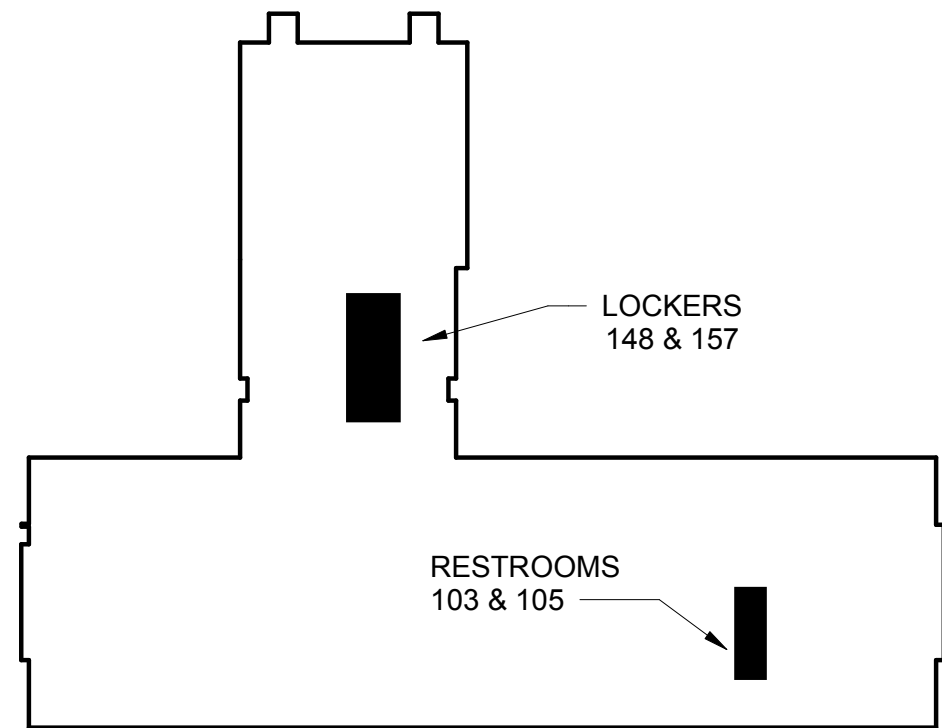

KEY PLAN


NO SCALE

CONSTRUCTION DOCUMENTS

SHEET NO.
E201-2

VCS RESTROOM RENOVATION
VOLUME 2 HHES
1009 W Klutina St. Valdez, AK 99686
CITY OF VALDEZ
HHES LOCKER AND RESTROOM
ELECTRICAL REMODEL PLANS

MCCOOL CARLSON GREEN
ARCHITECTURE • PLANNING • INTERIORS
HISTORIC ANCHORAGE TRAIN DEPOT
421 W. 1ST AVENUE • SUITE 300 • ANCHORAGE, AK 99501
907.563.8474 PHONE • 907.563.4572 FAX • WWW.MCGALASKA.COM

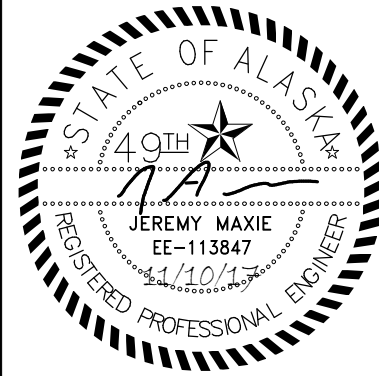

JOB NO. L7082	REVIEWED BY:
PROJ. MGR. PCC	
DRAWN BY: PCC	
DATE: 11-15-2017	JAM, XPT
REVISIONS:	